



SCATCHET HEAD WATER DISTRICT

WATER SYSTEM IMPROVEMENTS

AREA MAP - NOT TO SCALE

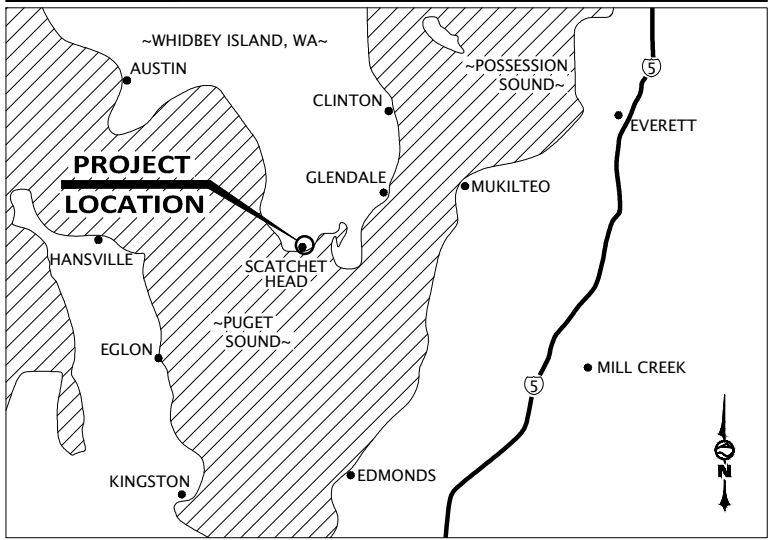

VICINITY MAP - NOT TO SCALE

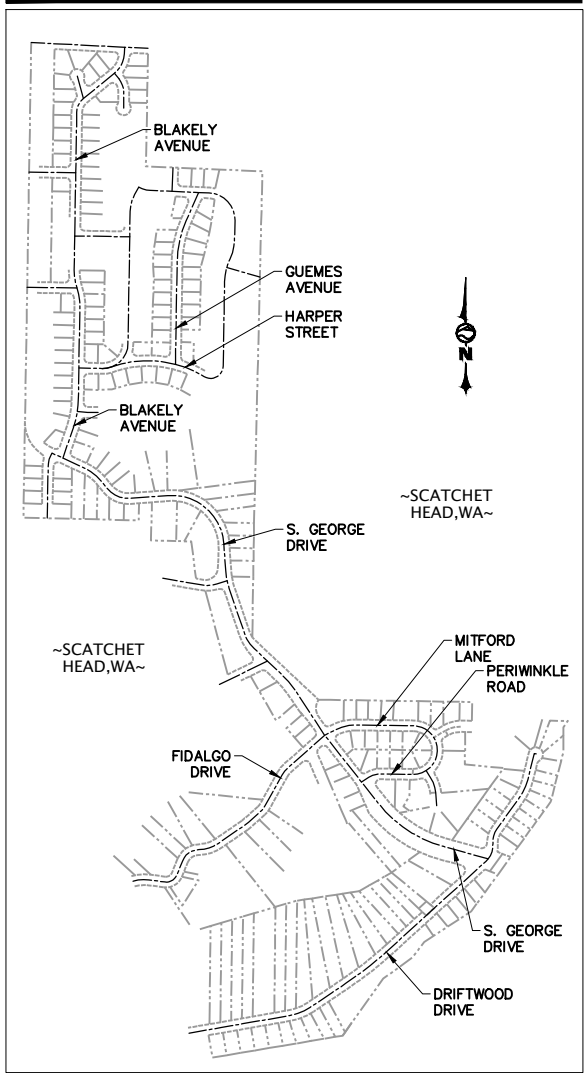

INDEX TO DRAWINGS

1.	SHEET C0.1	COVER SHEET
2.	SHEET C0.2	LEGEND AND ABBREVIATIONS
3.	SHEET C1.1	W.A.C. 332-130 COMPLIANCE SHEET
4.	SHEET C1.2	OVERALL CONTROL MAP
5.	SHEET C1.3	SHEET LAYOUT MAPS
6.	SHEET C2.1	EXISTING CONDITIONS
7.	SHEET C2.2	EXISTING CONDITIONS
8.	SHEET C2.3	EXISTING CONDITIONS
9.	SHEET C2.4	EXISTING CONDITIONS
10.	SHEET C2.5	EXISTING CONDITIONS
11.	SHEET C2.6	EXISTING CONDITIONS
12.	SHEET C2.7	EXISTING CONDITIONS
13.	SHEET C2.8	EXISTING CONDITIONS
14.	SHEET C2.9	EXISTING CONDITIONS
15.	SHEET C2.10	EXISTING CONDITIONS
16.	SHEET C2.11	EXISTING CONDITIONS
17.	SHEET C2.12	EXISTING CONDITIONS
18.	SHEET C2.13	EXISTING CONDITIONS
19.	SHEET C3.1	TESC NOTES
20.	SHEET C3.2	TESC DETAILS
21.	SHEET C4.1	BLAKELY AVENUE NORTH - STA 100+00 TO STA 104+67
22.	SHEET C4.2	BLAKELY AVENUE NORTH - STA 104+67 TO STA 109+25
23.	SHEET C4.3	BLAKELY AVENUE SOUTH - STA 200+00 TO STA 205+00
24.	SHEET C4.4	BLAKELY AVENUE SOUTH - STA 205+00 TO STA 209+73
25.	SHEET C4.5	BLAKELY AVENUE SOUTH - STA 209+73 TO STA 2011+07
26.	SHEET C4.6	GUEMES AVENUE - STA 300+00 TO STA 305+00
27.	SHEET C4.7	GUEMES AVENUE - STA 305+00 TO STA 310+00
28.	SHEET C4.8	HARPER STREET - STA 400+00 TO STA 404+00
29.	SHEET C4.9	HARPER STREET - STA 404+00 TO STA 407+56
30.	SHEET C4.10	S. GEORGE DRIVE - STA 500+00 TO STA 504+78
31.	SHEET C4.11	S. GEORGE DRIVE - STA 504+78 TO STA 509+66
32.	SHEET C4.12	S. GEORGE DRIVE - STA 509+66 TO STA 514+20
33.	SHEET C4.13	S. GEORGE DRIVE - STA 514+20 TO STA 518+80
34.	SHEET C4.14	S. GEORGE DRIVE - STA 518+80 TO STA 523+46
35.	SHEET C4.15	S. GEORGE DRIVE - STA 523+46 TO STA 528+38
36.	SHEET C4.16	S. GEORGE DRIVE - STA 528+38 TO STA 532+26
37.	SHEET C4.17	S. GEORGE DRIVE - STA 532+26 TO STA 536+71
38.	SHEET C4.28	FIDALGO DRIVE - STA 600+00 TO STA 605+00
39.	SHEET C4.19	FIDALGO DRIVE - STA 605+00 TO STA 610+00
40.	SHEET C4.20	FIDALGO DRIVE - STA 610+00 TO STA 613+62
41.	SHEET C4.21	MITFORD LANE - STA 613+62 TO STA 618+12
42.	SHEET C4.22	MITFORD LANE - STA 618+12 TO STA 621+40
43.	SHEET C4.23	PERIWINKLE ROAD - STA 621+40 TO STA 625+15
44.	SHEET C4.24	DRIFTWOOD DRIVE - STA 700+00 TO STA 704+81
45.	SHEET C4.25	DRIFTWOOD DRIVE - STA 704+81 TO STA 709+62
46.	SHEET C4.26	DRIFTWOOD DRIVE - STA 709+62 TO STA 714+52
47.	SHEET C4.27	DRIFTWOOD DRIVE - STA 714+52 TO STA 719+52
48.	SHEET C4.28	DRIFTWOOD DRIVE - STA 719+52 TO STA 724+04
49.	SHEET C5.1	PUMP HOUSE & TREATMENT IMPROVEMENTS - OVERALL SITE PLAN
50.	SHEET C5.2	PUMP HOUSE & TREATMENT IMPROVEMENTS - PUMP HOUSE BUILDING PLANS
51.	SHEET C5.3	PUMP HOUSE & TREATMENT IMPROVEMENTS - BUILDING ELEVATION
52.	SHEET C5.4	PUMP HOUSE & TREATMENT IMPROVEMENTS - TREATMENT DETAILS
53.	SHEET C5.5	PUMP HOUSE & TREATMENT IMPROVEMENTS - BACKWASH POND DETAILS
54.	SHEET C6.1	WELL SITE IMPROVEMENTS - OVERALL SITE PLAN
55.	SHEET C6.2	WELL SITE IMPROVEMENTS - BUILDING PLANS
56.	SHEET C6.3	WELL SITE IMPROVEMENTS - BUILDING ELEVATIONS
57.	SHEET C6.4	WELL SITE IMPROVEMENTS - WELL DETAIL
58.	SHEET C7.1	TRAFFIC CONTROL PLAN
59.	SHEET C8.1	CIVIL DETAILS
60.	SHEET C8.2	CIVIL DETAILS
61.	SHEET C8.3	CIVIL DETAILS
62.	SHEET C8.4	CIVIL DETAILS



DESIGNED BY	CDS
DRAWN BY	JGS
CHECKED BY	CDS

SCATCHET HEAD WATER DISTRICT	WASHINGTON
WATER SYSTEM IMPROVEMENTS	
COVER SHEET	

SHEET	DATE	SCALE	JOB NUMBER
C0.1	12-8-22	AS SHOWN	2022-013
PAGE		OF	
X		X	



PRELIMINARY

LEGEND & ABBREVIATIONS— SIZE & SCALE MAY VARY	
EXISTING HATCH PATTERNS	
	EXIST. CONCRETE
	EXIST. BUILDING
	EXIST. EARTH
	EXIST. GRAVEL
	EXIST. SAND
PROPOSED HATCH PATTERNS	
	PROP. CONCRETE
	PROP. TOP COURSE GRAVEL
	PROP. GRAVEL
	PROP. SAND
	PROP. QUARRY SPALLS
	WETLAND HATCH
SURFACE FEATURES	
EXISTING PLAN LINETYPES	
	BRIDGE
	BUILDING LINE
	BUILDING COLUMN
	BUILDING OVERHANG
	BULKHEAD
	CONCRETE EDGE
	CREEK EDGE
	CROWN OF ROAD
	CURB
	DITCH CENTERLINE
	DECK
	DOCK
	EDGE OF SAWCUT
	EDGE OF PAVEMENT
	FENCE
	GATE
	GRADE
	GRAVEL
	GUARDRAIL
	JERSEY BARRIER
	LAKE/POND WATER EDGE
	LIP OF CURB
	MISC SURFACE FEATURE
	MISC TRAFFIC
	PLANTER
	PATH
	RAILROAD
	RAMP (WOOD)
	HANDRAIL
	RETAINING WALL
	ROAD STRIPING
	ROCKERY
	RIVERBANK/ShORELINE
	THALWEG LINE
	TOP OF BANK/SLOPE
	TOE OF BANK/SLOPE
	VEGETATION/SHRUB LINE
	WETLAND/SWAMP PERIMETER
	WETLAND BUFFER
SURFACE FEATURES	
PROPOSED PLAN LINETYPES	
	BRIDGE
	BUILDING LINE
	CONCRETE
	CURB
	DITCH CENTERLINE
	EDGE OF BIKE LANE
	EDGE OF PAVEMENT
	FENCE
	GATE
	GRAVEL
	GUARDRAIL
	JERSEY BARRIER
	LIP OF CURB
	REBAR
	RETAINING WALL
	ROCKERY
	ROAD STRIPING
	HANDRAIL
	EDGE OF SAWCUT


UTILITIES EXISTING PLAN LINETYPES		DESCRIPTION
— TV —	— TV —	CABLE TELEVISION (AERIAL)
— TV —	— TV —	CABLE TELEVISION (BURIED)
— C —		SURVEILLANCE CAMERA (BURIED)
— FO —	— FO —	FIBER OPTIC/COMMUNICATIONS LINE (AERIAL)
— FO —	— FO —	FIBER OPTIC/COMMUNICATIONS LINE (BURIED)
— OHT —	— OHT —	TELEPHONE/COMMUNICATIONS (AERIAL)
— T —	— T —	TELEPHONE/COMMUNICATIONS (BURIED)
— SC —	— SC —	TRAFFIC SIGNAL CONDUIT LINE
— OHP —	— OHP —	POWER (AERIAL)
— P —	— P —	POWER (BURIED)
— UT —	— UT —	UTILITY (AERIAL)
— UT —	— UT —	UTILITY (BURIED)
— PDB —	— PDB —	POWER DUCT BANK (BURIED)
— DF —	— DF —	DRAIN FIELD
— S —	— S —	SANITARY SEWER
— S — S — S — S — S —		APPROXIMATE SANITARY SEWER
— FM —	— FM —	SANITARY SEWER (FORCE MAIN)
— FM — FM — FM — FM — FM —		APPROXIMATE SANITARY SEWER (FORCE MAIN)
— SD —	— SD —	STORM DRAINAGE
— SD — SD — SD — SD — SD —		APPROXIMATE STORM DRAINAGE
— C —		CULVERT (Ø WIDTH)
> <		CULVERT
— RW —	— RW —	RECLAIMED WATER
— IRR —	— IRR —	IRRIGATION
— W —	— W —	WATER
— W — W — W — W — W —		APPROXIMATE WATER
— BW —	— BW —	8" WATER
— OF —	— OF —	OVERFLOW
— STE —	— STE —	STEAM
— G —	— G —	GAS
		GAS TANK/STRUCTURE
— O —	— O —	OIL
— AIR —	— AIR —	AIR LINE
— — — — —		BURIED UTILITY APPROX. EXTENTS
— — — — —		MISC UTILITY (BURIED)
PROPOSED PLAN UTILITY LINETYPES		DESCRIPTION
WATER		
— W —	— W —	WATER
— BW —	— BW —	8" WATER
— IRR —	— IRR —	IRRIGATION
— RW — RW — RW — RW — RW —		RECLAIMED WATER
— PW — PW — PW — PW — PW —		POTABLE WATER
— W — W — W — W — W —		WATER SERVICE
		WATER STRUCTURE
— FDC —	— FDC —	FIRE DEPARTMENT CONNECTION
— FP —	— FP —	FIRE PROTECTION LINE
SANITARY SEWER		
— S —	— S —	SEWER
— BS —	— BS —	8" SEWER
— FM —	— FM —	FORCE MAIN
— DF —	— DF —	DRAIN FIELD
— S — S — S — S — S —		SEWER SERVICE
		SEWER STRUCTURE
STORM DRAIN		
— D —	— D —	STORM DRAIN
— SD —	— SD —	STORM DRAIN
— D — D — D — D — D —		STORM SERVICE
— FD — FD — FD — FD — FD —		FOOTING DRAIN
		STORM STRUCTURE
MISC. UTILITIES		
— G —	— G —	GAS
— P —	— P —	POWER
— T —	— T —	TELEPHONE/COMMUNICATIONS
EROSION CONTROL		DESCRIPTION
— TSD —	— TSD —	EROSION TRIANGULAR SILT DIKE
— CB —	— CB —	EROSION CONTROL COMPOST BERM
— 100 —		EROSION CONTROL MINOR CONTOUR
— OB —	— OB —	EROSION CONTROL MAJOR CONTOUR
— SF —	— SF —	ORANGE BARRIER FENCE
— SW —	— SW —	SILT FENCE
— > —	— > —	STRAW WATTLE
		EROSION CONTROL FLOWLINE
	SB	STRAW BALE
	IP	INLET PROTECTION
	CD	CHECK DAM

SURVEY PLAN LINETYPES	DESCRIPTION
	CENTERLINE (EXISTING)
	CENTERLINE (CONSTRUCTION)
	CENTERLINE (PROPOSED)
	CONTOUR (EXISTING MINOR)
	CONTOUR (EXISTING INDEX)
	HYDRO CONTOUR (EXISTING INDEX)
	CONTOUR (PROPOSED INDEX)
	CONTOUR (PROPOSED MINOR)
	DONATION LAND CLAIM (EXIST.)
	EASEMENT (PROPOSED)
	EASEMENT (EXISTING)
	MEANDER LINE
	ORDINARY HIGH WATER LINE
	MEAN LOW LEVEL WATER LINE
	OWNERSHIP LINE
	PROPERTY LINE (RECORD OR ADJACENT)
	PROPERTY LINE
	QUARTER SECTION LINE
	RANGE/TOWNSHIP LINE
	RESERVATION/PARK/FOREST (EX)
	RIGHT-OF-WAY (EX) (EXISTING)
	RIGHT-OF-WAY (EXISTING)
	RIGHT-OF-WAY (EXISTING USED)
	RIGHT-OF-WAY (PROPOSED)
	RIGHT-OF-WAY (EX. RECORD) (RECORD OR ADJACENT)
	RIGHT-OF-WAY (LIMITED ACCESS)
	RIGHT-OF-WAY (LIMITED ACCESS)
	SECTION LINE
	SETBACK LINE (EXISTING)
	SIXTEENTH SECTION LINE
	STATE/COUNTY/CORPORATE LIMIT
	VACATED RIGHT-OF-WAY
	EASEMENT (RECORD)
	RIGHT-OF-WAY CENTER (RECORD)
	DONATION LAND CLAIM (RECORD)
	MEANDER LINE (RECORD)
	PARK LINE (RECORD)
	SECTION LINE (RECORD)
	QUARTER SECTION LINE (RECORD)
	SIXTEENTH SECTION LINE (RECORD)
	STATE LINE (RECORD)
	RANGE LINE (RECORD)
PROFILE LINETYPES	DESCRIPTION
	PROFILE EX. GRND
	PROFILE FINISH GRND
	PROFILE GRID
	PROFILE VERTICAL GRID
	PROFILE EX. GROUND LEFT
	PROFILE EXISTING GROUND RIGHT
	FIBER OPTIC PROFILE (EXISTING)
	GAS PROFILE (EXISTING)
	POWER PROFILE (EXISTING)
	RAILROAD PROFILE (EXISTING)
	SANITARY PROFILE (EXISTING)
	SANITARY PROFILE (PROPOSED)
	STORM PROFILE (EXISTING)
	TELEPHONE PROFILE (EXISTING)
	STORM PROFILE (PROPOSED)
	TV PROFILE (EXISTING)
	UTILITY PROFILE (EXISTING)
	WATER PROFILE (EXISTING)
	WATER PROFILE (PROPOSED)
DEMOLITION	DESCRIPTION
	SURFACE FEATURE OR UTILITY TO BE REMOVED
	SAWCUT
	CLEARING LIMIT
	TREE OR BUSH TO BE REMOVED
GRADING	
	GRADE BREAK
	CATCHLINE
	CUT LINE
	FILL LINE
	SLOPE ARROWS
SECTION/DETAIL CALL-OUTS	
	SECTION CALL-OUTS: (A) REPRESENTS THE SECTION LABEL, (B) INDICATES THE SHEET ON WHICH THE SECTION APPEARS.
	DETAIL CALL-OUTS: (A) REPRESENTS THE DETAIL LABEL, (B) INDICATES THE SHEET ON WHICH THE DETAIL APPEARS.


MISC. SYMBOLS			WATER SYMBOLS		
EXISTING	PROPOSED	DESCRIPTION	EXISTING	PROPOSED	DESCRIPTION
		SOIL BORING			ARY VALVE
		MONITORING WELL			GLOBE VALVE, FL
		TEST WELL			BALL CHECK VALVE, FL
		TEST PIT			BLOW-OFF VALVE
		EMBANKMENT			SWING CHECK VALVE, FL
		MAIL BOX			BUTTERFLY VALVE, FL
		SIGN			DOUBLE LEAF CHECK VALVE, FL
		RIP RAP			PLUG VALVE
		BOULDER			BALL VALVE
		SHRUB			FLOAT VALVE
		TREE (Conifer)*			PINCH VALVE
		TREE (Deciduous)*			PRESSURE & VACUUM RELIEF VALVE
		STUMP-PLAN VIEW			VACUUM RELIEF VALVE
		YARD LIGHT			PRESSURE REGULATING VALVE (SELF CONTAINED)
		WELL			BACK PRESSURE REGULATING VALVE (SELF CONTAINED)
		PILE			IN-LINE SPRING LOADED RELIEF VALVE
		ROCKERY			CAP/PLUG
		WHEEL STOP			GUARD POST
		SPLASH BLOCK			THRUST BLOCK
		GAS METER			WATER METER
		GAS VALVE			FIRE DEPARTMENT CONNECTION
		PAD MOUNTED TRANSFORMER			WATER VALVE
		POWER VAULT			FIRE HYDRANT
		TRANSMISSION TOWER			WATER MANHOLE
		POWER CABINET OR PANEL			POST INDICATOR VALVE
		POWER METER			11-1/4 BEND, MJ-FL
		GUY POLE			22-1/2 BEND, MJ-FL
		UTILITY POLE			45 BEND, MJ-FL
		UTILITY POLE ANCHOR			90 BEND, MJ-FL
		TELE RISER			FLxMJ ADAPTER
		CABLE RISER			COUPLER
		FIBER OPTIC RISER			BLIND FLANGE
		FIBER OPTIC MANHOLE			GATE VALVE, FLxMJ
		TELEPHONE MANHOLE			GATE VALVE, MJ
		TELEPHONE VAULT			REDUCER, MJxFL
		STEAM MANHOLE			REDUCER, MJ
		PARKING METER			TEE, FL
		POST			TEE, MJ
		PUMP			TEE, MJxFL
					TEE, FLxMJ
					CROSS, FL
					CROSS, MJ

</

ABBREVIATIONS	
AB	=AS-BUILT (RECORD)
AC	=ASBESTOS CEMENT
AL	=ALIGNMENT
ANC	=UTILITY POLE ANCHOR
APPROX	=APPROXIMATE
ASPH or AC	=ASPHALT
ASSY	=ASSEMBLY
ASTM	=AMERICAN SOCIETY FOR TESTING & MATERIALS
BUILDG	=BUILDING
BMP	=BEST MANAGEMENT PRACTICE
BVC	=BEGIN VERTICAL CURVE STATION
BVCE	=BEGIN VERTICAL CURVE ELEVATION
CB	=CATCH BASIN
CK	=CHECK VALVE
C/L or $\mathbb{C}$	=CENTERLINE
CESCL	=CERTIFIED EROSION SEDIMENT CONTROL LEAD
COL	=COLUMN
CP	=CORRUGATED METAL PIPE
CMU	=CONCRETE MASONRY UNIT
C.O. or CO	=CLEAN OUT
CONC, C	=CONCRETE
COR	=CORNER
CRSI	=CONCRETE REINFORCING STEEL INSTITUTE
CPP	=CORRUGATED POLYETHYLENE PIPE
CSBC	=CRUSHED SURFACING BASE COURSE
CSTC	=CRUSHED SURFACING TOP COURSE
DCVA	=DOUBLE CHECK VALVE ASSEMBLY
DI or DIP	=DUCTILE IRON PIPE
DIAM	=DIAMETER
DO	=DISSOLVED OXYGEN
DR	=DIMENSION RATIO
DS	=DOWNSPOUT
EFFL	=EFFLUENT
EC	=EXISTING GRADE
ELEV, EL	=ELEVATION
EOG	=EDGE OF GRAVEL
EOP	=EDGE OF PAVEMENT
EP	=EXPLORATION PIT
EXISTG, EX	=EXISTING
EVCS	=END VERTICAL CURVE STATION
EVCE	=END VERTICAL CURVE ELEVATION
FDC	=FIRE DEPARTMENT CONNECTION
FF	=FINISH FLOOR
FG	=FINISH GRADE
FL	=FLOWLINE OR FLANGE (CONNECTION)
$\overline{\text{F}}$	=FLOWLINE
FLC	=FLOWLINE OF CURB
FM	=FOREMAIN
FNC	=FENCE
FRP	=FIBERGLASS REINFORCED PIPE
GB	=GRADE BREAK
GMET	=GAS METER
GP	=GUY POLE
GPM	=GALLONS PER MINUTE
GRVL, G	=GRAVEL
GV	=GATE VALVE
HB	=HOSE BIB
HDC	=HOT-DIP GALVANIZED
HDPE	=HIGH DENSITY POLYETHYLENE
HV	=HORIZONTAL-VERTICAL
HWL	=HIGH WATER LEVEL
HYD	=HYDRANT
IBC	=INTERNATIONAL BUILDING CODE
IN	=INVERT ELEVATION
INFO	=INFORMATION
INV	=INVERT
IPS	=IRON PIPE SIZE
LF	=LINEAR FEET
LUM	=LUMINAIRE
LT	=LEFT
MAX	=MAXIMUM
MB	=MAIL BOX
MFR	=MANUFACTURER
MH	=MANHOLE
MIN	=MINIMUM
MISC	=MISCELLANEOUS
MJ	=MECHANICAL JOINT
MW	=MONITORING WELL
N.C.	=NORMALLY CLOSED
N.O.	=NORMALLY OPEN
NPDES	=NATIONAL POLLUTANT DISCHARGE ELIMINATION SYSTEM
ON	=ON CENTER
O.C.E.W	=ON CENTER EACH WAY
OD	=OUTSIDE DIAMETER
OHF	=OVERHEAD POWER
OHT	=OVERHEAD TELEPHONE
OSHA	=OCCUPATIONAL SAFETY AND HEALTH ADMINISTRATION
PC	=POINT OF CURVATURE
PCC	=POINT OF CONTINUING CURVATURE
PE	=POLYETHYLENE OR PLAIN END
PVI	=POST INDICATOR VALVE
P/L or $\mathbb{P}$	=PROPERTY LINE
PLC	=PROGRAMMABLE LOGIC CONTROLLER
PLTR	=PLANTER
POL	=POINT ON LINE
PROP	=PROPOSED
PS	=PUMP STATION
PSI	=POUNDS PER SQUARE INCH
PT	=POINT OF TANGENCY
PVC	=POLYVINYL CHLORIDE
PVI	=POINT OF VERTICAL INTERSECTION
PW	=POTABLE WATER
R	=RADIUS
R	=ROCK/BOULDER
RET	=RETAINING
REC	=RECORD
REINF	=REINFORCEMENT
REQ'D	=REQUIRED
RI	=RAPID INFILTRATION
RPBA	=REDUCED PRESSURE BACKFLOW ASSEMBLY
RR	=RAILROAD
RT	=RIGHT
R/W or ROW	=RIGHT-OF-WAY
RW	=REUSE WATER
SCADA	=SUPERVISORY CONTROL AND DATA ACQUISITION
SCH	=SCHEDULE
SCDB	=STORM DRAIN CATCH BASIN
SD	=STORM DRAIN
SDMH	=STORM DRAIN MANHOLE
SFH	=SINGLE FAMILY HOUSING
SN	=SIGN
SPD	=STANDARD PROCTOR DENSITY
SPK	=SPIKE
SS	=SANITARY SEWER
SSCO	=SANITARY SEWER CLEAN-OUT
SSMH	=SANITARY SEWER MANHOLE
SST	=STAINLESS STEEL
STA	=STATION
STEP	=SEPTIC TANK EFFLUENT PUMP
S/W	=SIDEWALK
SYMM	=SYMMETRY/SYMMETRICAL
TBC	=TOP BACK OF CURB
TBD	=TO BE DETERMINED
TBM	=TEMPORARY BENCH MARK
T.O.W	=TOP OF WALL
TYP	=TYPICAL
UNK	=UNKNOWN
UP	=UTILITY POLE
VAC	=VACATED
VC	=VERTICAL CURVE
VEG	=VEGETATION
VFD	=VARIABLE FREQUENCY DRIVE
WA	=WATER
WL	=WATERLINE
WM	=WATER METER
WS	=WATER SURFACE
WSDOT	=WASHINGTON STATE DEPARTMENT OF TRANSPORTATION
WD	=WATER VALVE
YD	=YARD DRAIN
YL	=YARD LIGHT

 SHEET	C0.2	DATE	12-8-22		
		PAGE	AS SHOWN	JOB NUMBER	2022-013
X	OF	X			
SCATCHET HEAD WATER DISTRICT			WASHINGTON		
WHIDBEY ISLAND			WATER SYSTEM IMPROVEMENTS		
LEGEND & ABBREVIATIONS			DESIGNED BY		
			CDSS		
			DRAWN BY		
			JCS		
			CHECKED BY		
			CDSS		
 					
					
					
WILSONENGINEERING.COM					

PLOT SETTINGS: AutoCAD PDF (General Documentation).pc3, ANSI full bleed B (17.00 x 11.00 inches), Portrait, 1:2, WE APWA_UNSCREENED.ctb
W:\2022\2022-013 SCATCHET HEAD WD WATER IMPROVEMENTS.MXD\DWG_V2019_NAD083_NAD088\2022_013 C1.3 SHEET LAYOUT MAPS.DWG - 12/8/2022 1:52 PM - Jeff Smith

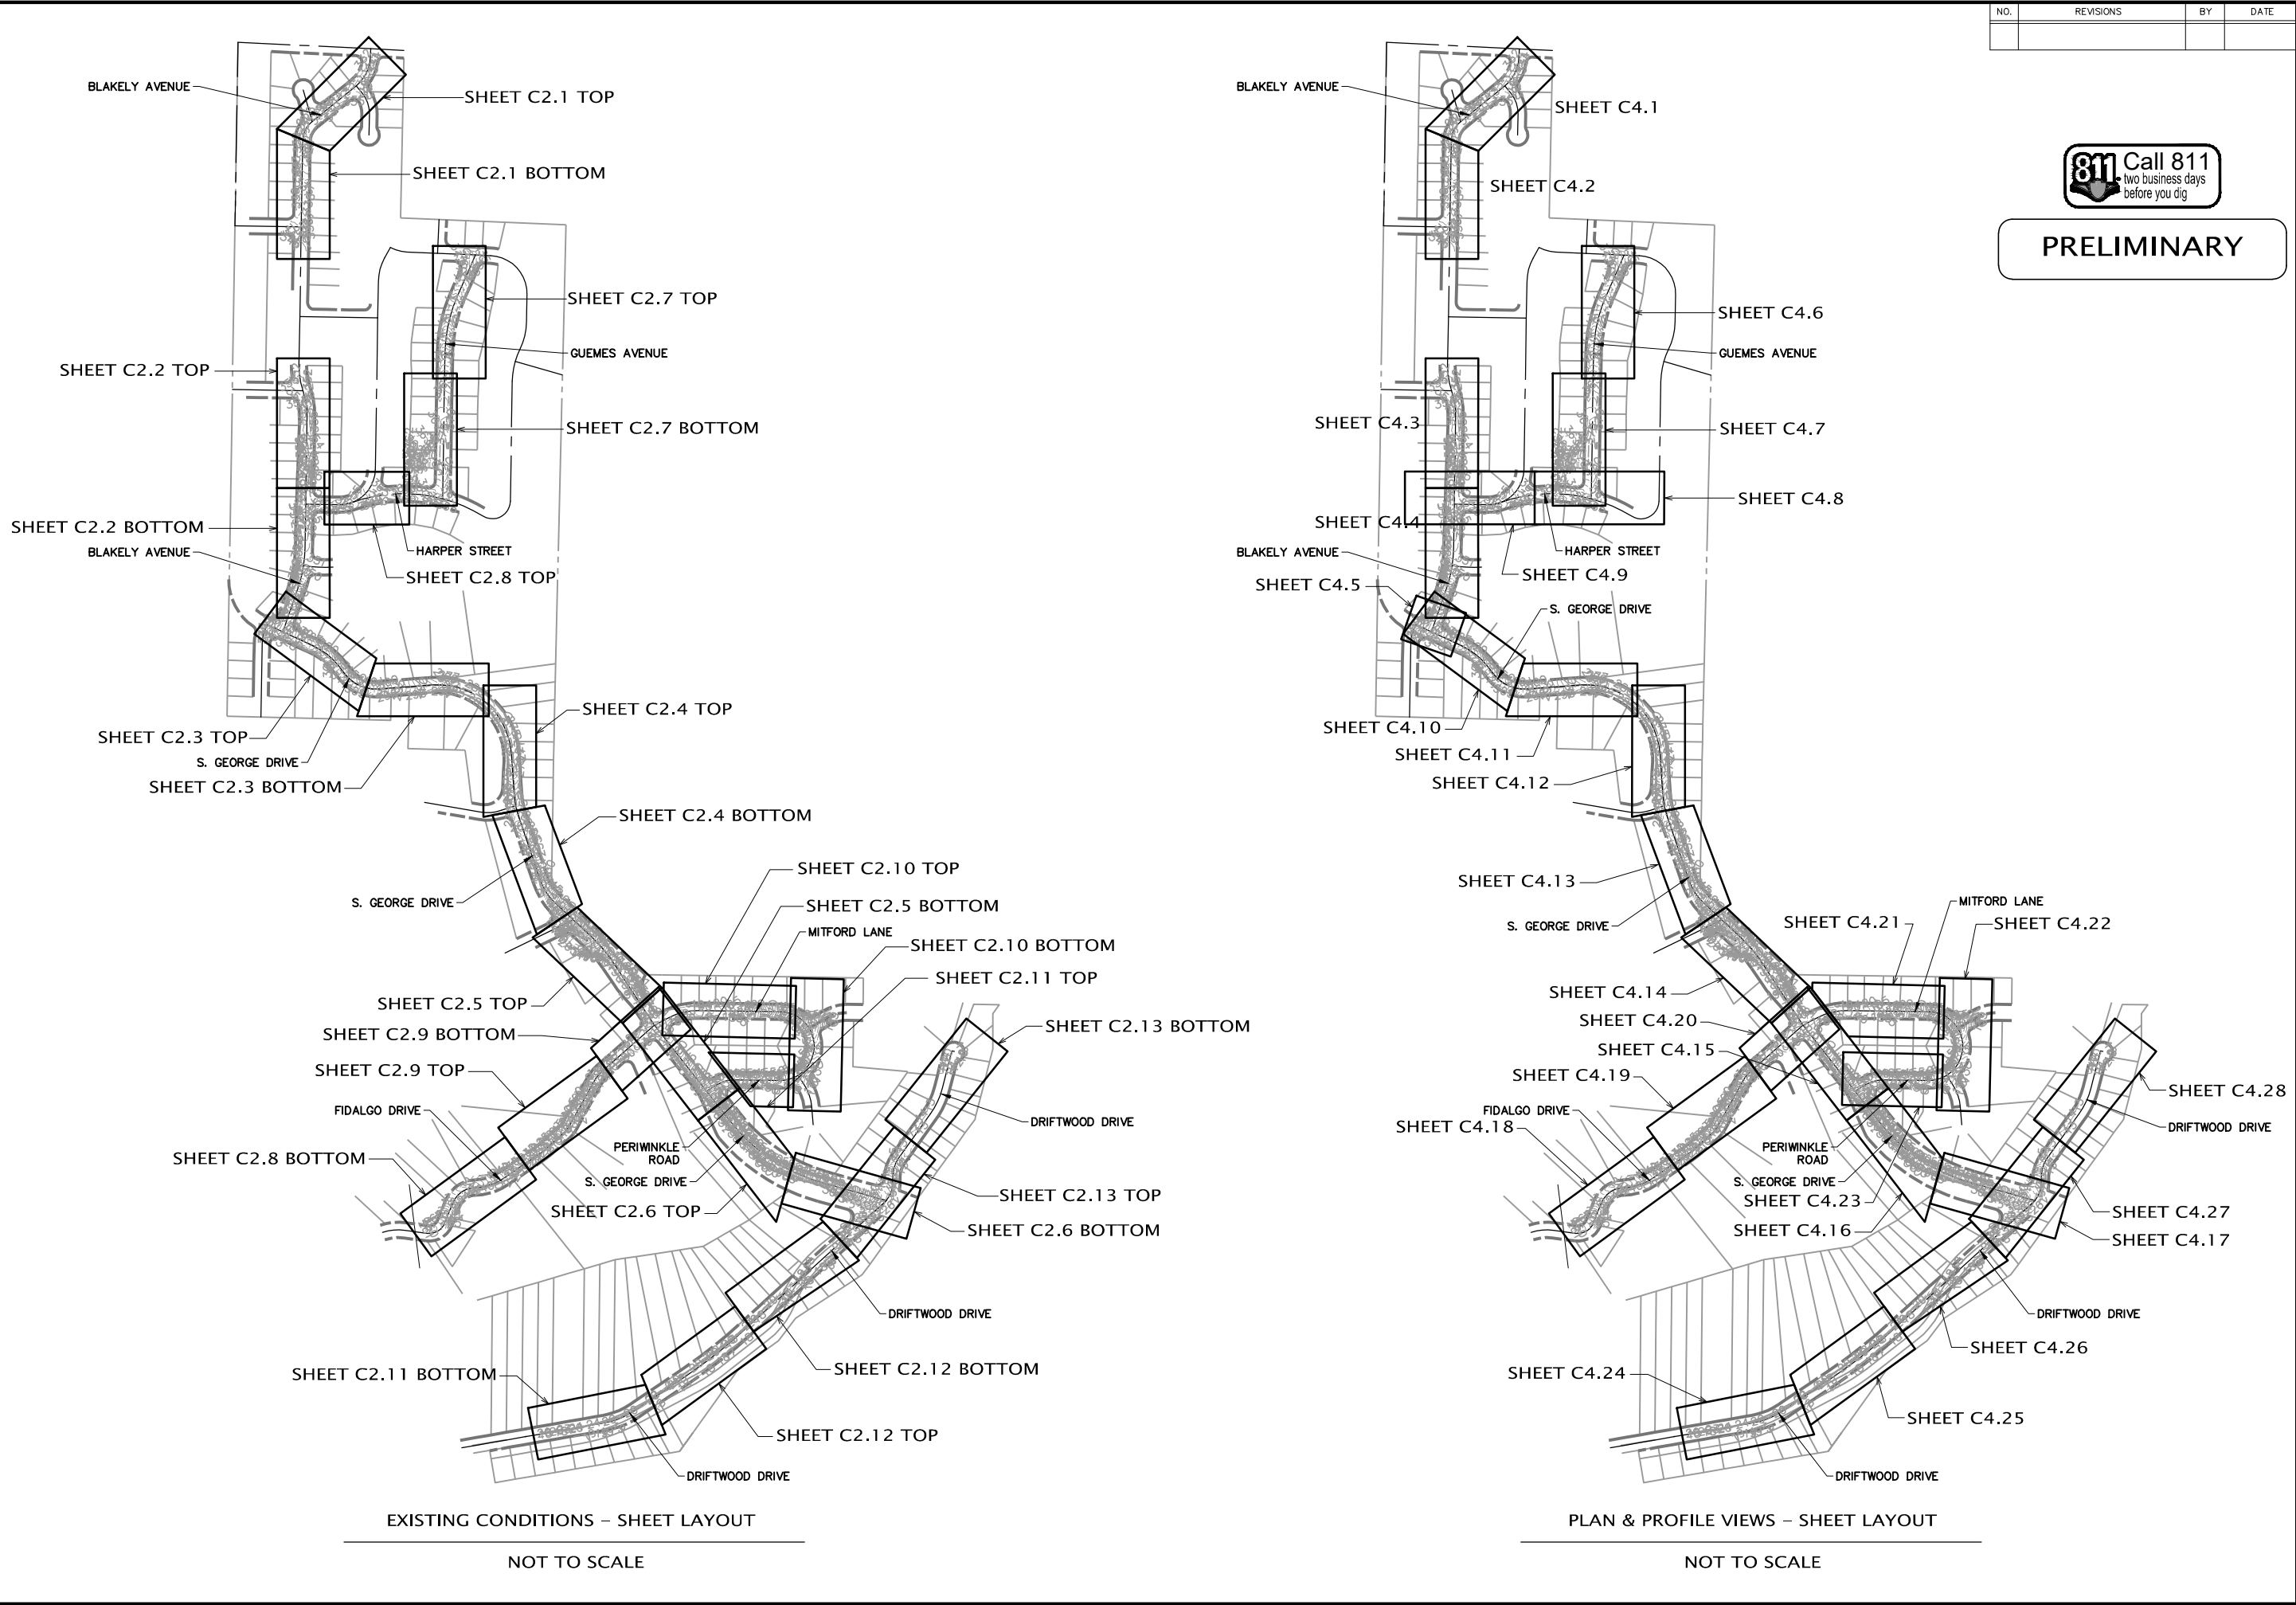

NO.		REVISIONS		BY	DATE


PRELIMINARY

WILSON
ENGINEERING
WILSONENGINEERING.COM

DESIGNED BY	CDS	DRAWN BY	JGS	CHECKED BY	CDS
-------------	-----	----------	-----	------------	-----

SHEET C1.3	DATE	12-8-22
	SCALE	AS SHOWN
	JOB NUMBER	2022-013
SCATCHET HEAD WATER DISTRICT		
WATER SYSTEM IMPROVEMENTS		
EXISTING CONDITIONS - SHEET LAYOUT MAPS		

PLOT SETTINGS: AutoCAD PDF (General Documentation).pc3, ANSI full bleed B (17.00 x 11.00 inches), Portrait, 1:2, WE APWA_UNSCREENED.ctb
W:\2022\2022-013 SCATCHET HEAD WD WATER IMPROVEMENTS.MXD\DWG_V2019_NAD83_NAD88\2022_2022-013 C2.1-C2.13 EXISTING CONDITIONS.DWG - 12/8/2022 1:52 PM - Jeff Smith

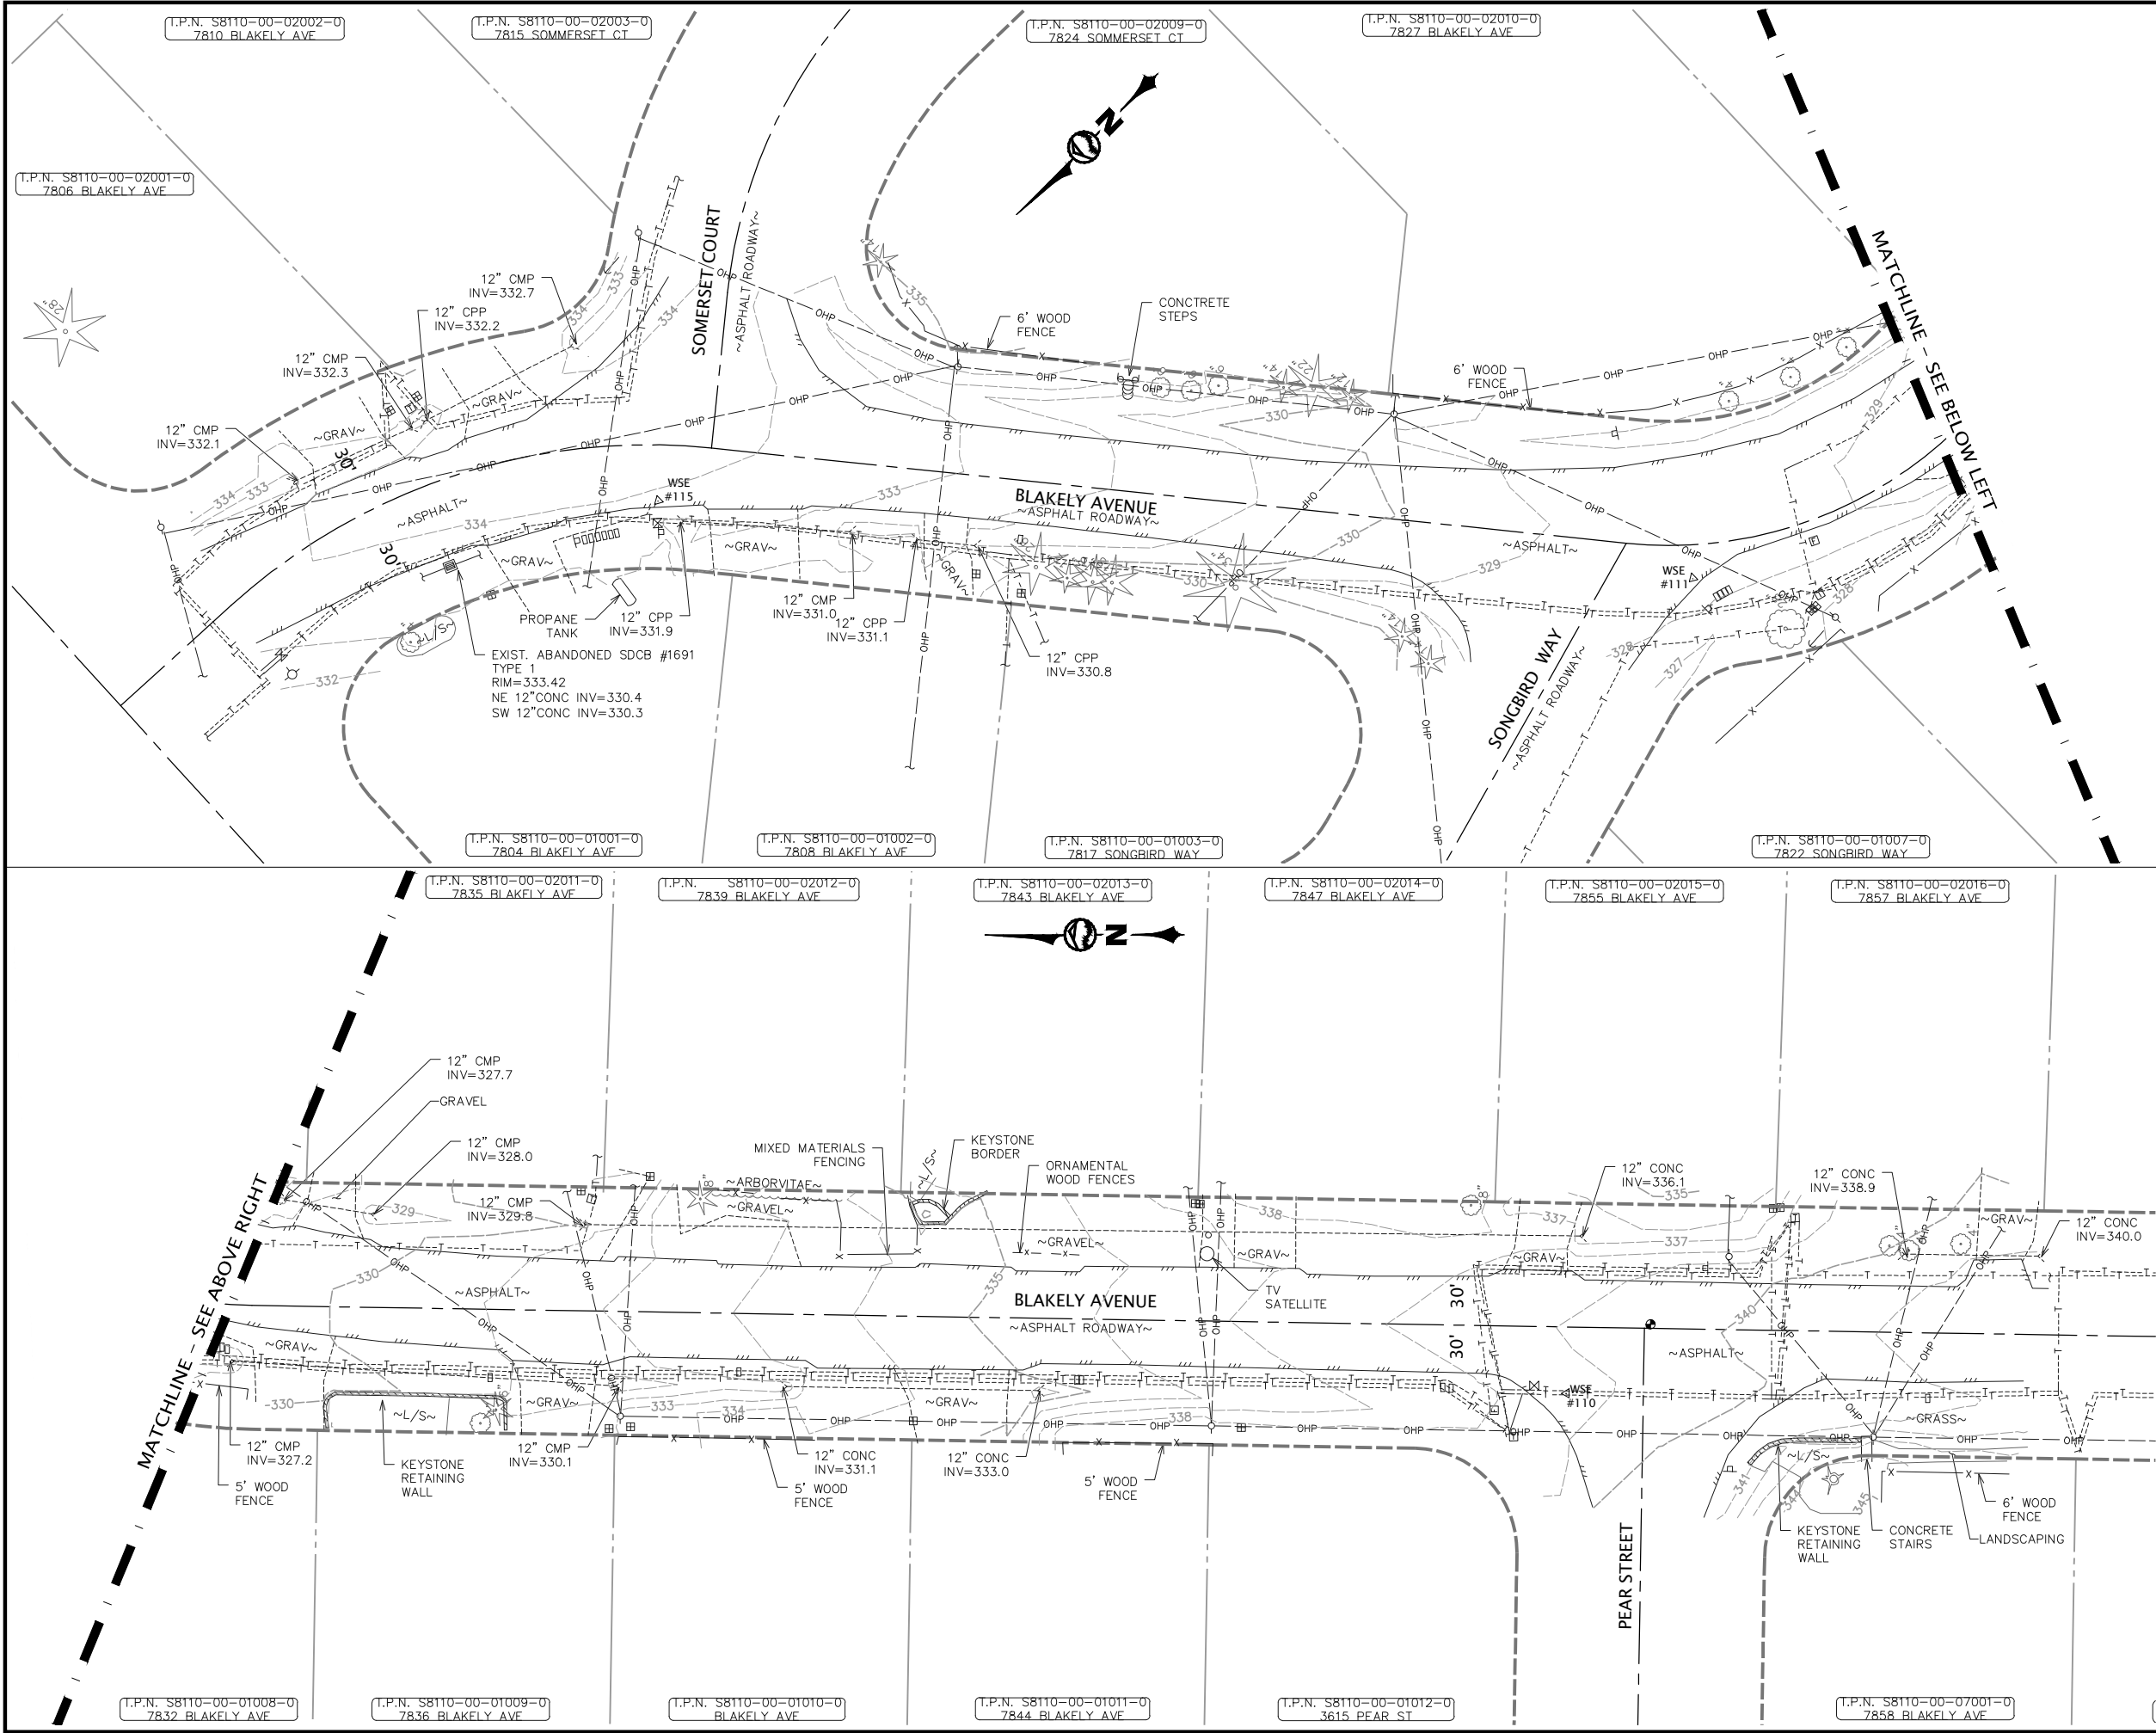

NO.	REVISIONS	BY	DATE

KEY MAP
NOT TO SCALE

LEGEND
= TOP VIEW, THIS SHEET
= BOTTOM VIEW, THIS SHEET

20 0 20 40
SCALE HORIZONTAL SCALE FEET

811 Call 811
two business days
before you dig

PRELIMINARY



SCATCHET HEAD WATER DISTRICT		WASHINGTON	
WATER SYSTEM IMPROVEMENTS <td colspan="2">EXISTING CONDITIONS</td>		EXISTING CONDITIONS	
WHIDBEY ISLAND <td colspan="2"> </td>			
DATE 12-8-22	SCALE AS SHOWN	JOB NUMBER 2022-013	
SHEET C2.1	PAGE X	OF X	

WILSON
ENGINEERING

WILSONENGINEERING.COM


PRELIMINARY

PLOT SETTINGS: AutoCAD PDF (General Documentation).pc3, ANSI full bleed B (17.00 x 11.00 inches), Portrait, 1:2, WE APWA_UNSCREENED.ctb
W:\2022\2022-013 SCATCHET HEAD WD WATER IMPROVEMENTS.MXD\2022-013 C2.1-C2.13 EXISTING CONDITIONS.DWG - 12/8/2022 1:52 PM - Jeff Smith

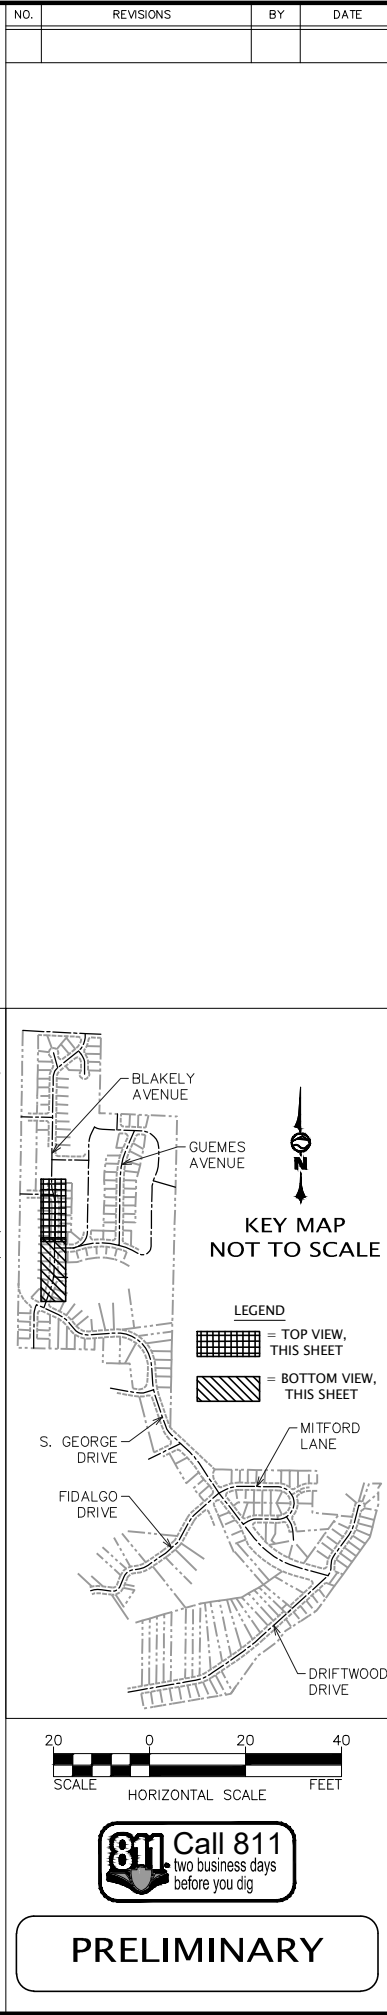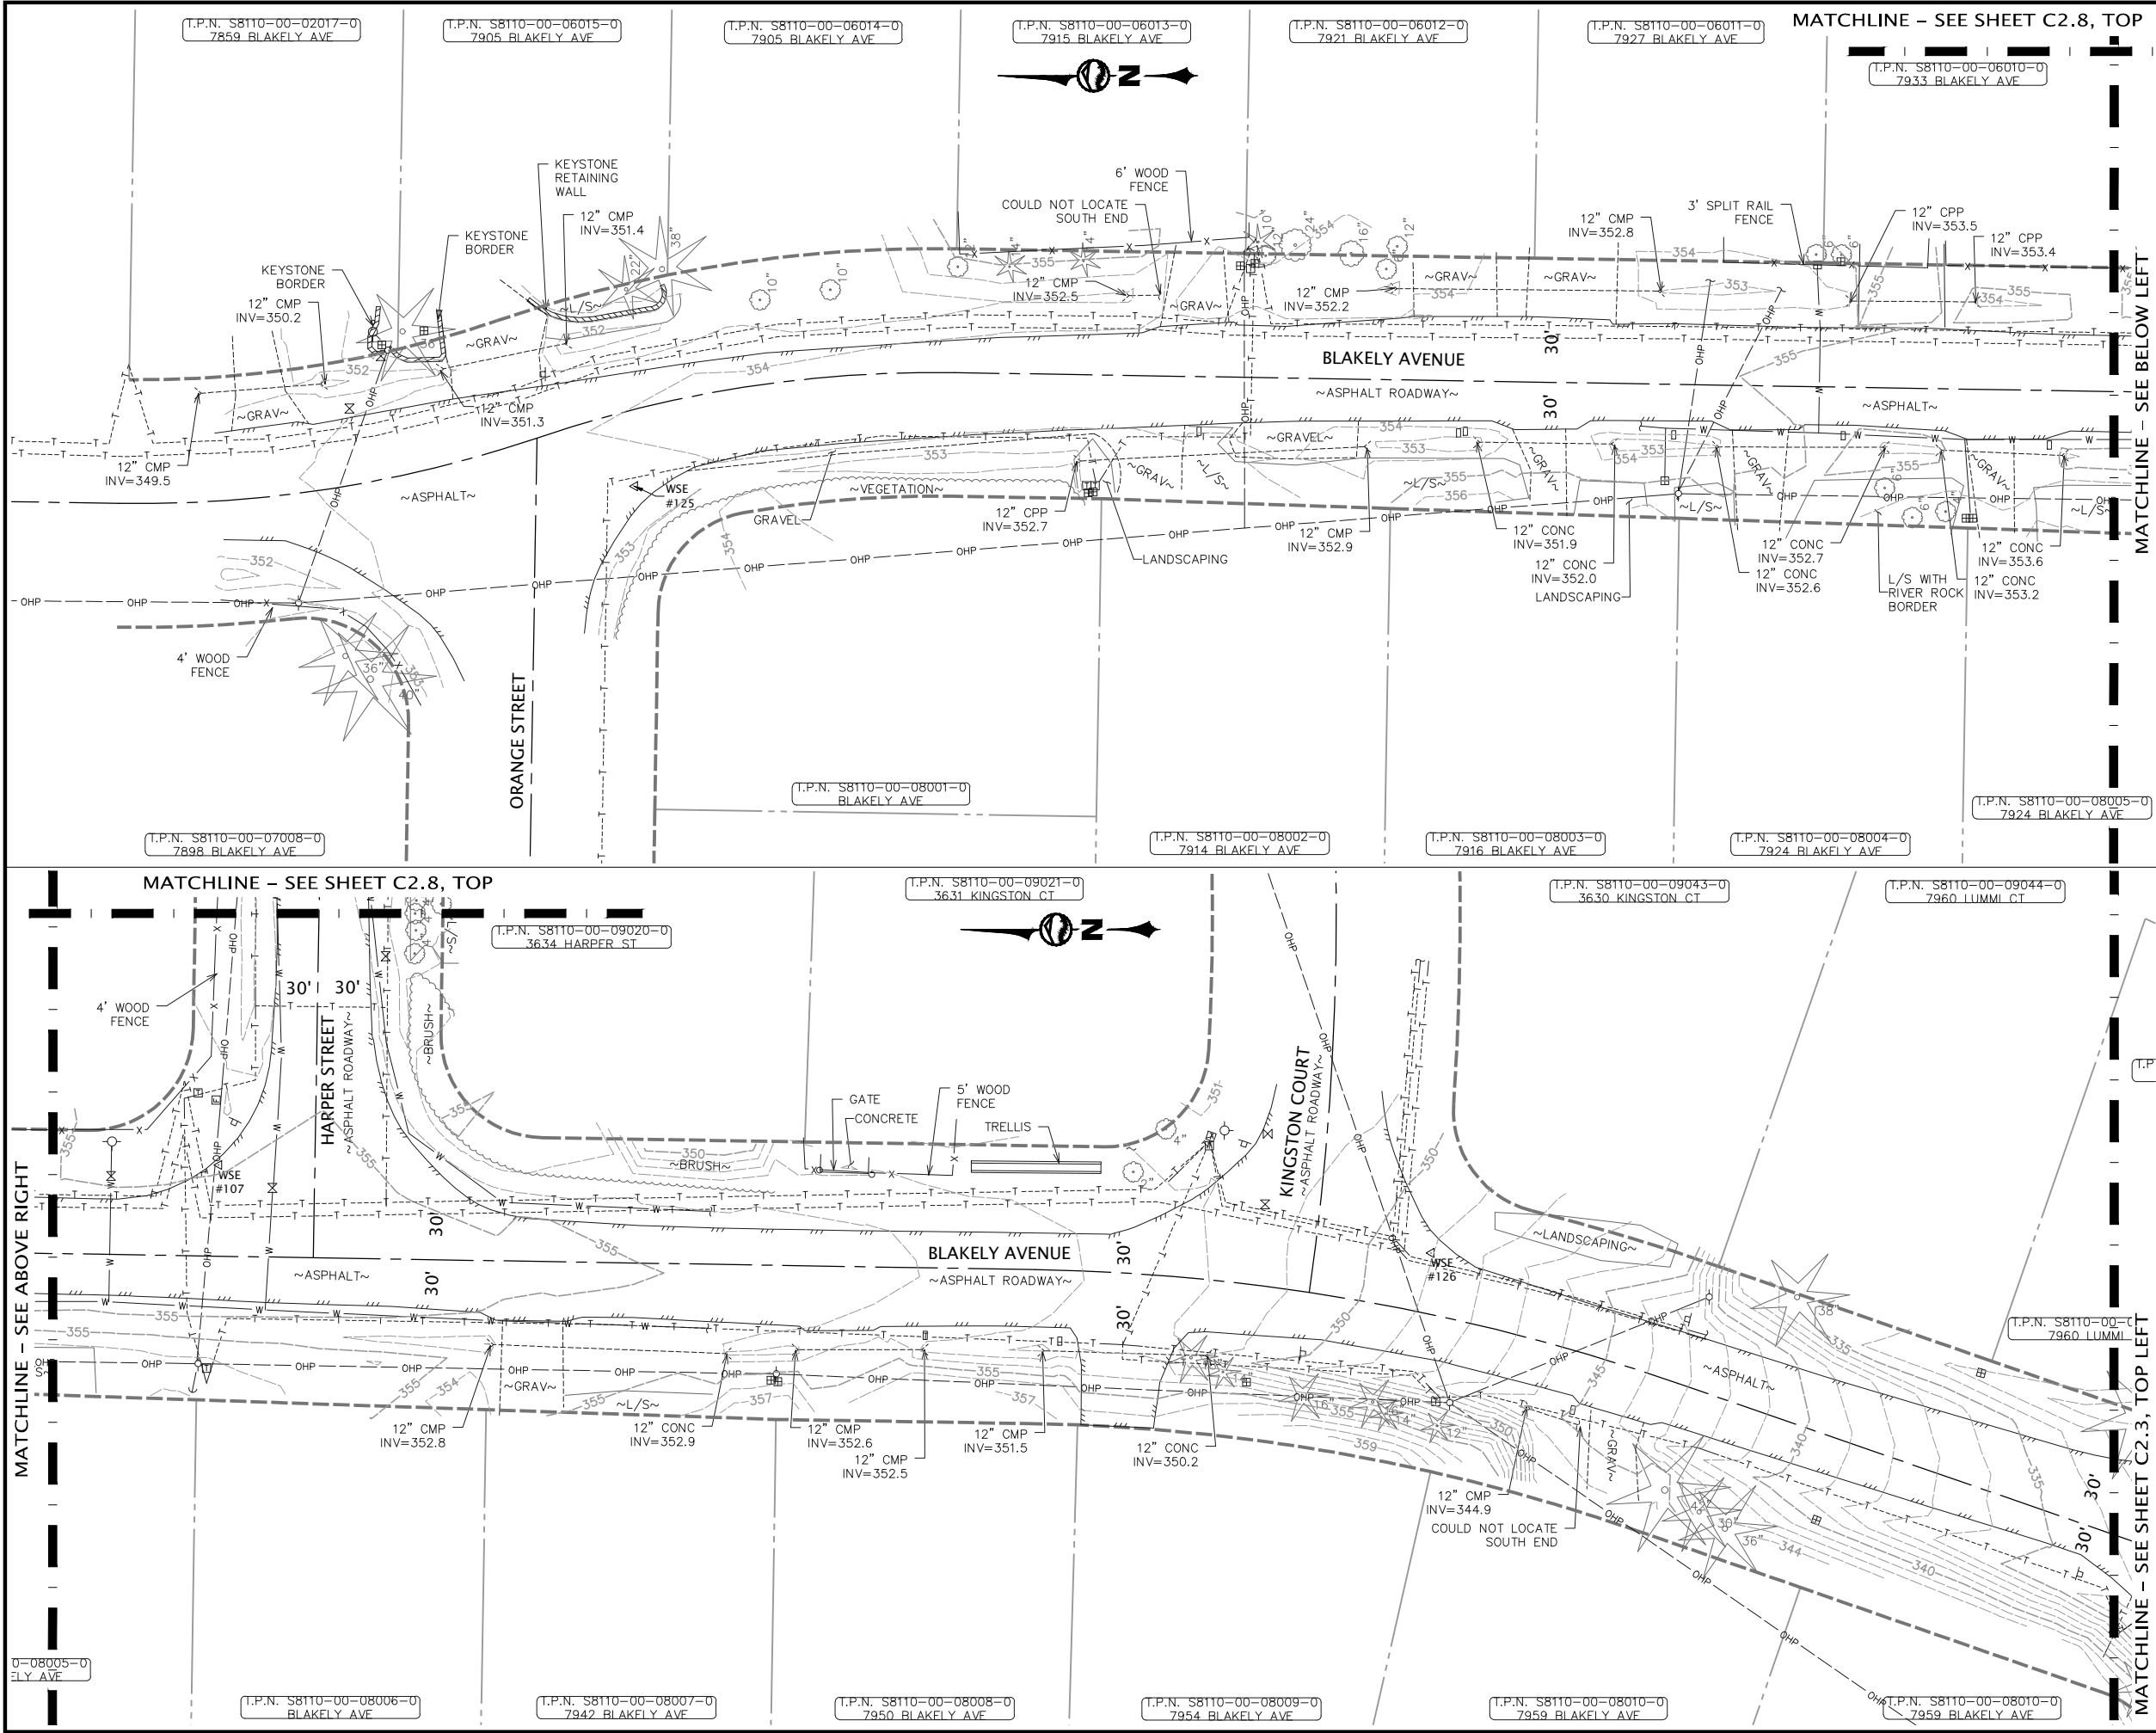

WILSON ENGINEERING WILSONENGINEERING.COM		NO.		REVISIONS		BY	DATE
		DRAWN BY		CLM/JGS		CHECKED BY	
		WASHINGTON				PID	
SCATCHET HEAD WATER DISTRICT		WATER SYSTEM IMPROVEMENTS					
		EXISTING CONDITIONS					
SHEET C2.2	DATE 12-8-22	SCALE AS SHOWN	JOB NUMBER 2022-013				
	PAGE		X	OF	X		

PLOT SETTINGS: AutoCAD PDF (General Documentation).pc3, ANSI full bleed B (17.00 x 11.00 inches), Portrait, 1:2, WE APWA_UNSCREENED.ctb
W:\2022\2022-013 SCATCHET HEAD WD WATER IMPROVEMENTS.MXD\DWG_V2019_NAD83_NAD88\2022_2022-013 C2.1-C2.13 EXISTING CONDITIONS.DWG - 12/8/2022 1:53 PM - Jeff Smith

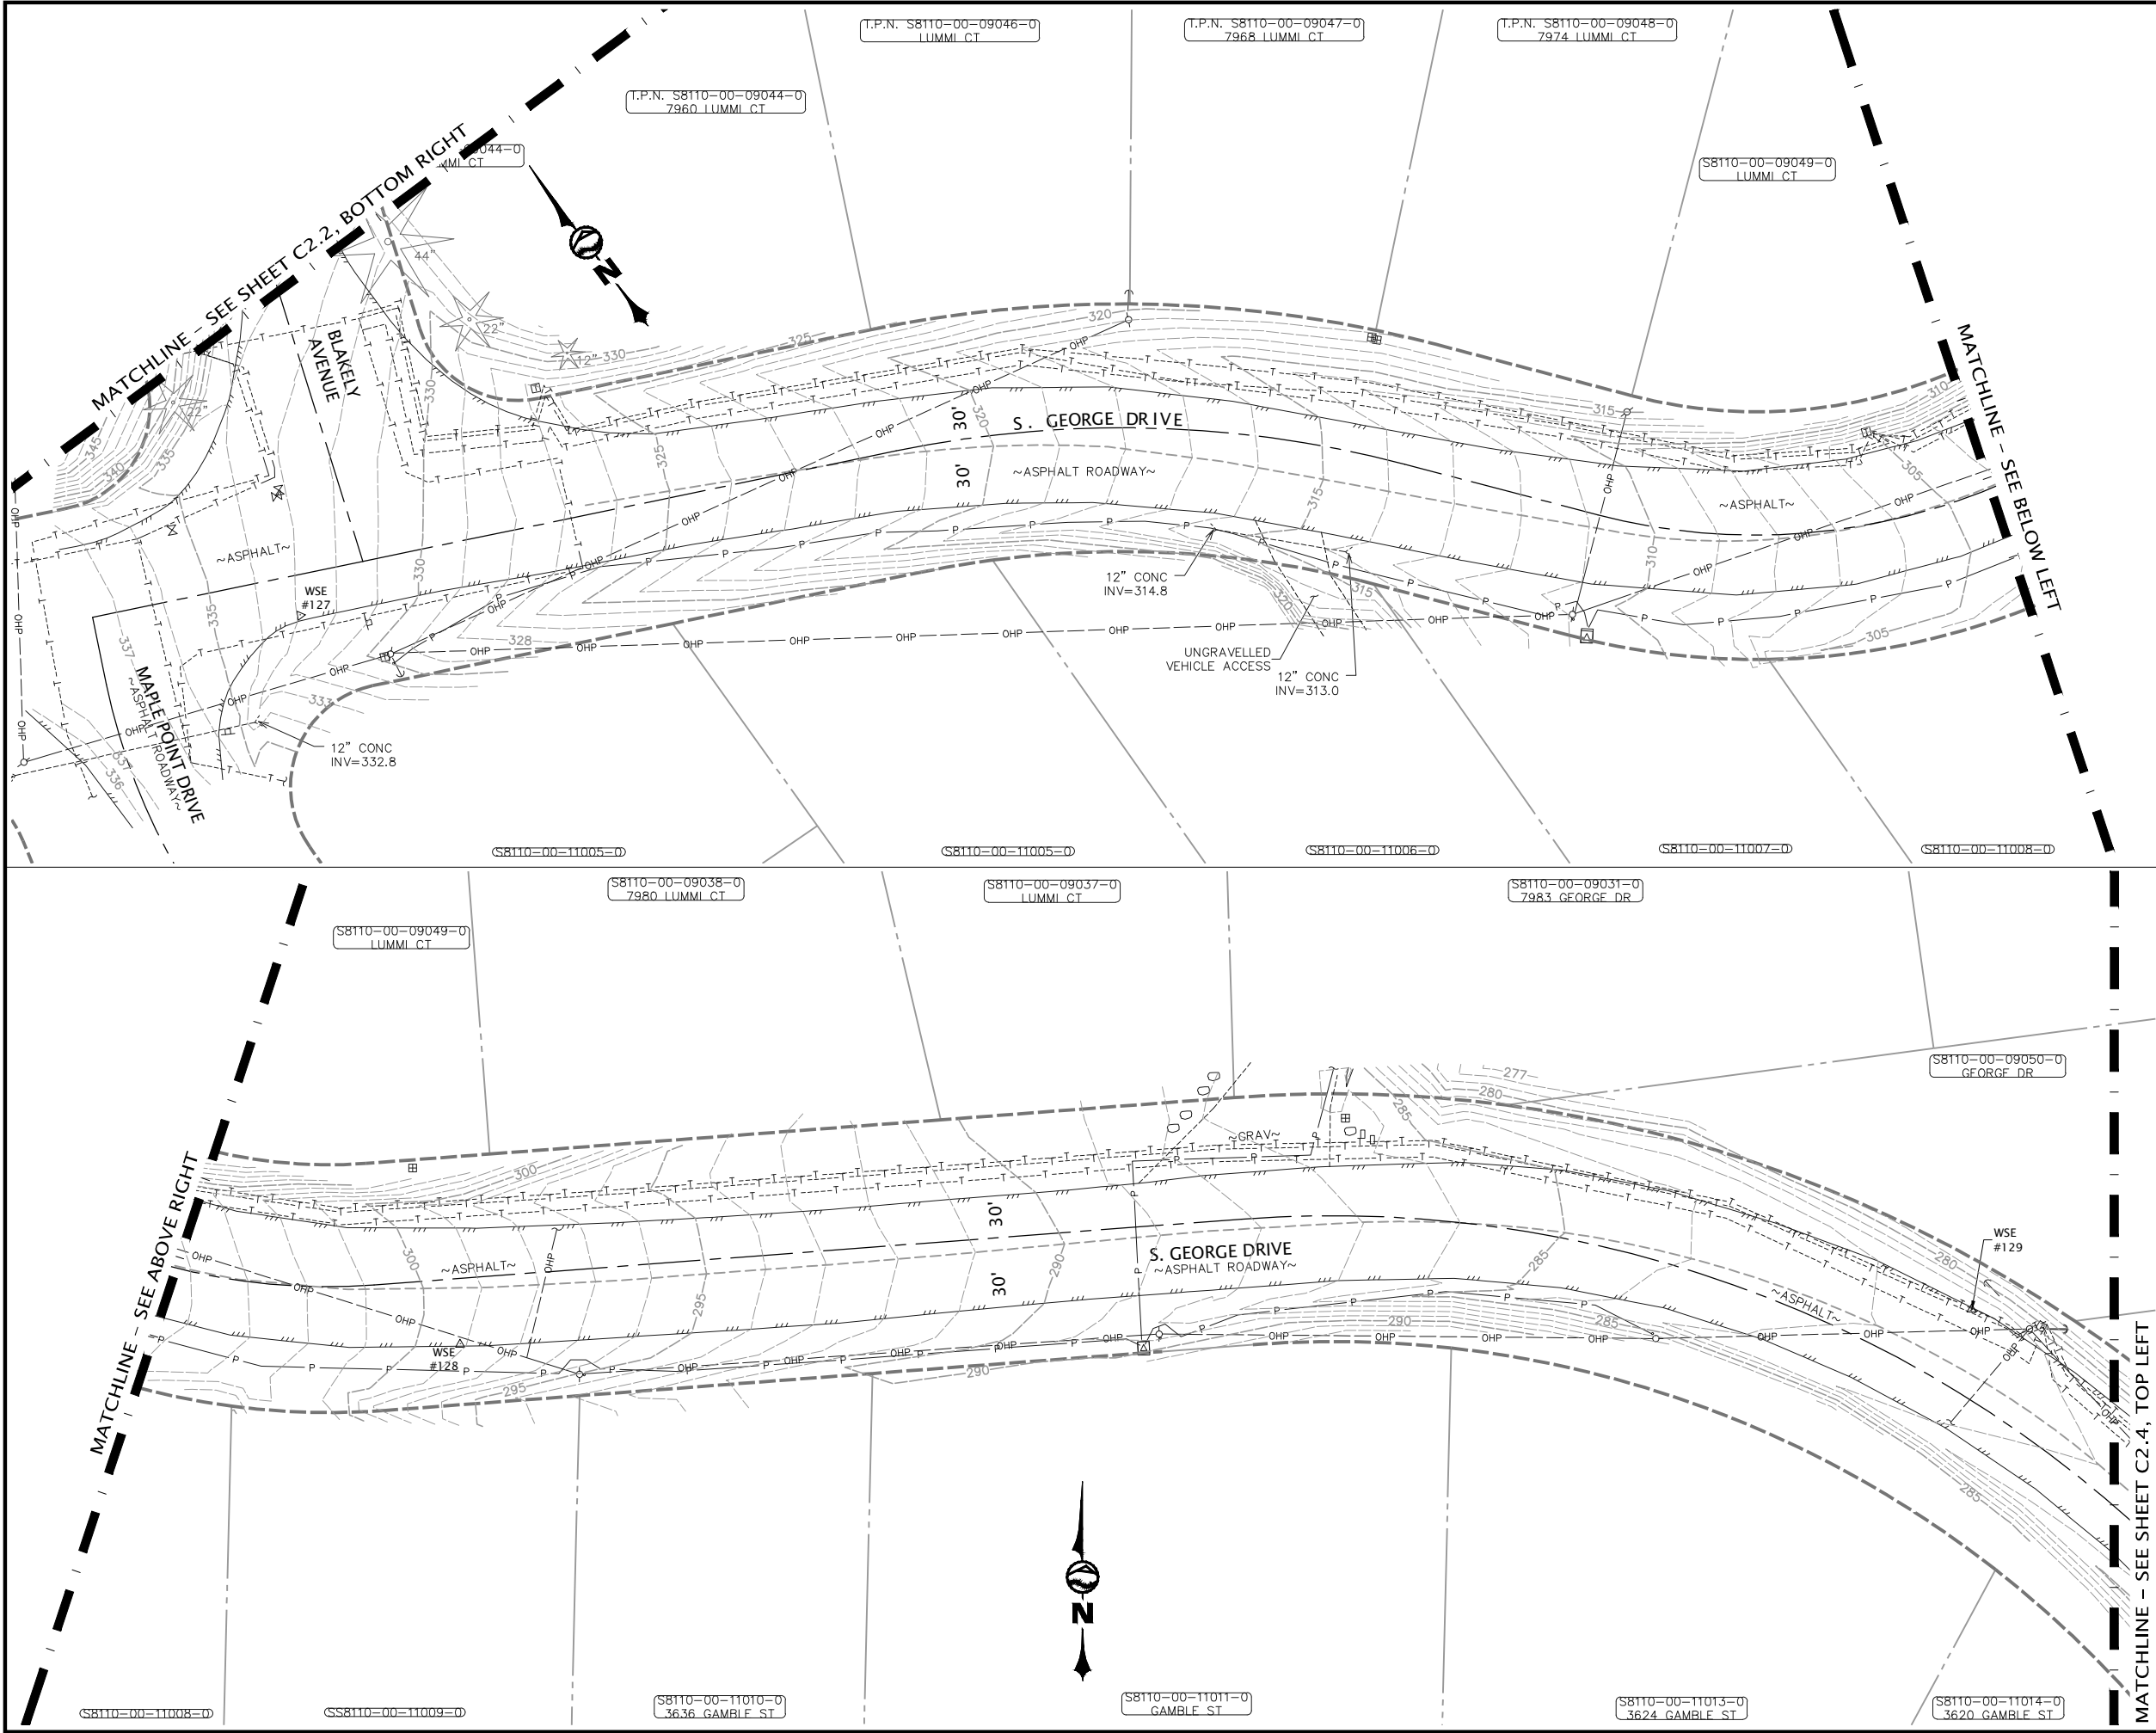

NO.		REVISIONS		BY	DATE

KEY MAP
NOT TO SCALE

LEGEND
[Hatched Box] = TOP VIEW, THIS SHEET
[Cross-hatched Box] = BOTTOM VIEW, THIS SHEET

20 0 20 40
SCALE HORIZONTAL SCALE FEET

811 Call 811
two business days
before you dig

PRELIMINARY

SCATCHET HEAD WATER DISTRICT		WASHINGTON		DRAWN BY	CLM/JGS	CHECKED BY	PID
DATE		12-8-22		SCALE		AS SHOWN	
SHEET		C2.3		JOB NUMBER		2022-013	
PAGE		X		OF		X	

WILSON ENGINEERING


WILSONENGINEERING.COM

PRELIMINARY

WATER SYSTEM IMPROVEMENTS

EXISTING CONDITIONS

PLOT SETTINGS: AutoCAD PDF (General Documentation).pc3, ANSI full bleed B (17.00 x 11.00 inches), Portrait, 1:2, WE APWA_UNSCREENED.ctb
W:\2022\2022-013 SCATCHET HEAD WD WATER IMPROVEMENTS_MM\DWG_V2019_NAD83_NAD88\2022_2022-013 C2.1-C2.13 EXISTING CONDITIONS.DWG - 12/8/2022 1:53 PM - Jeff Smith

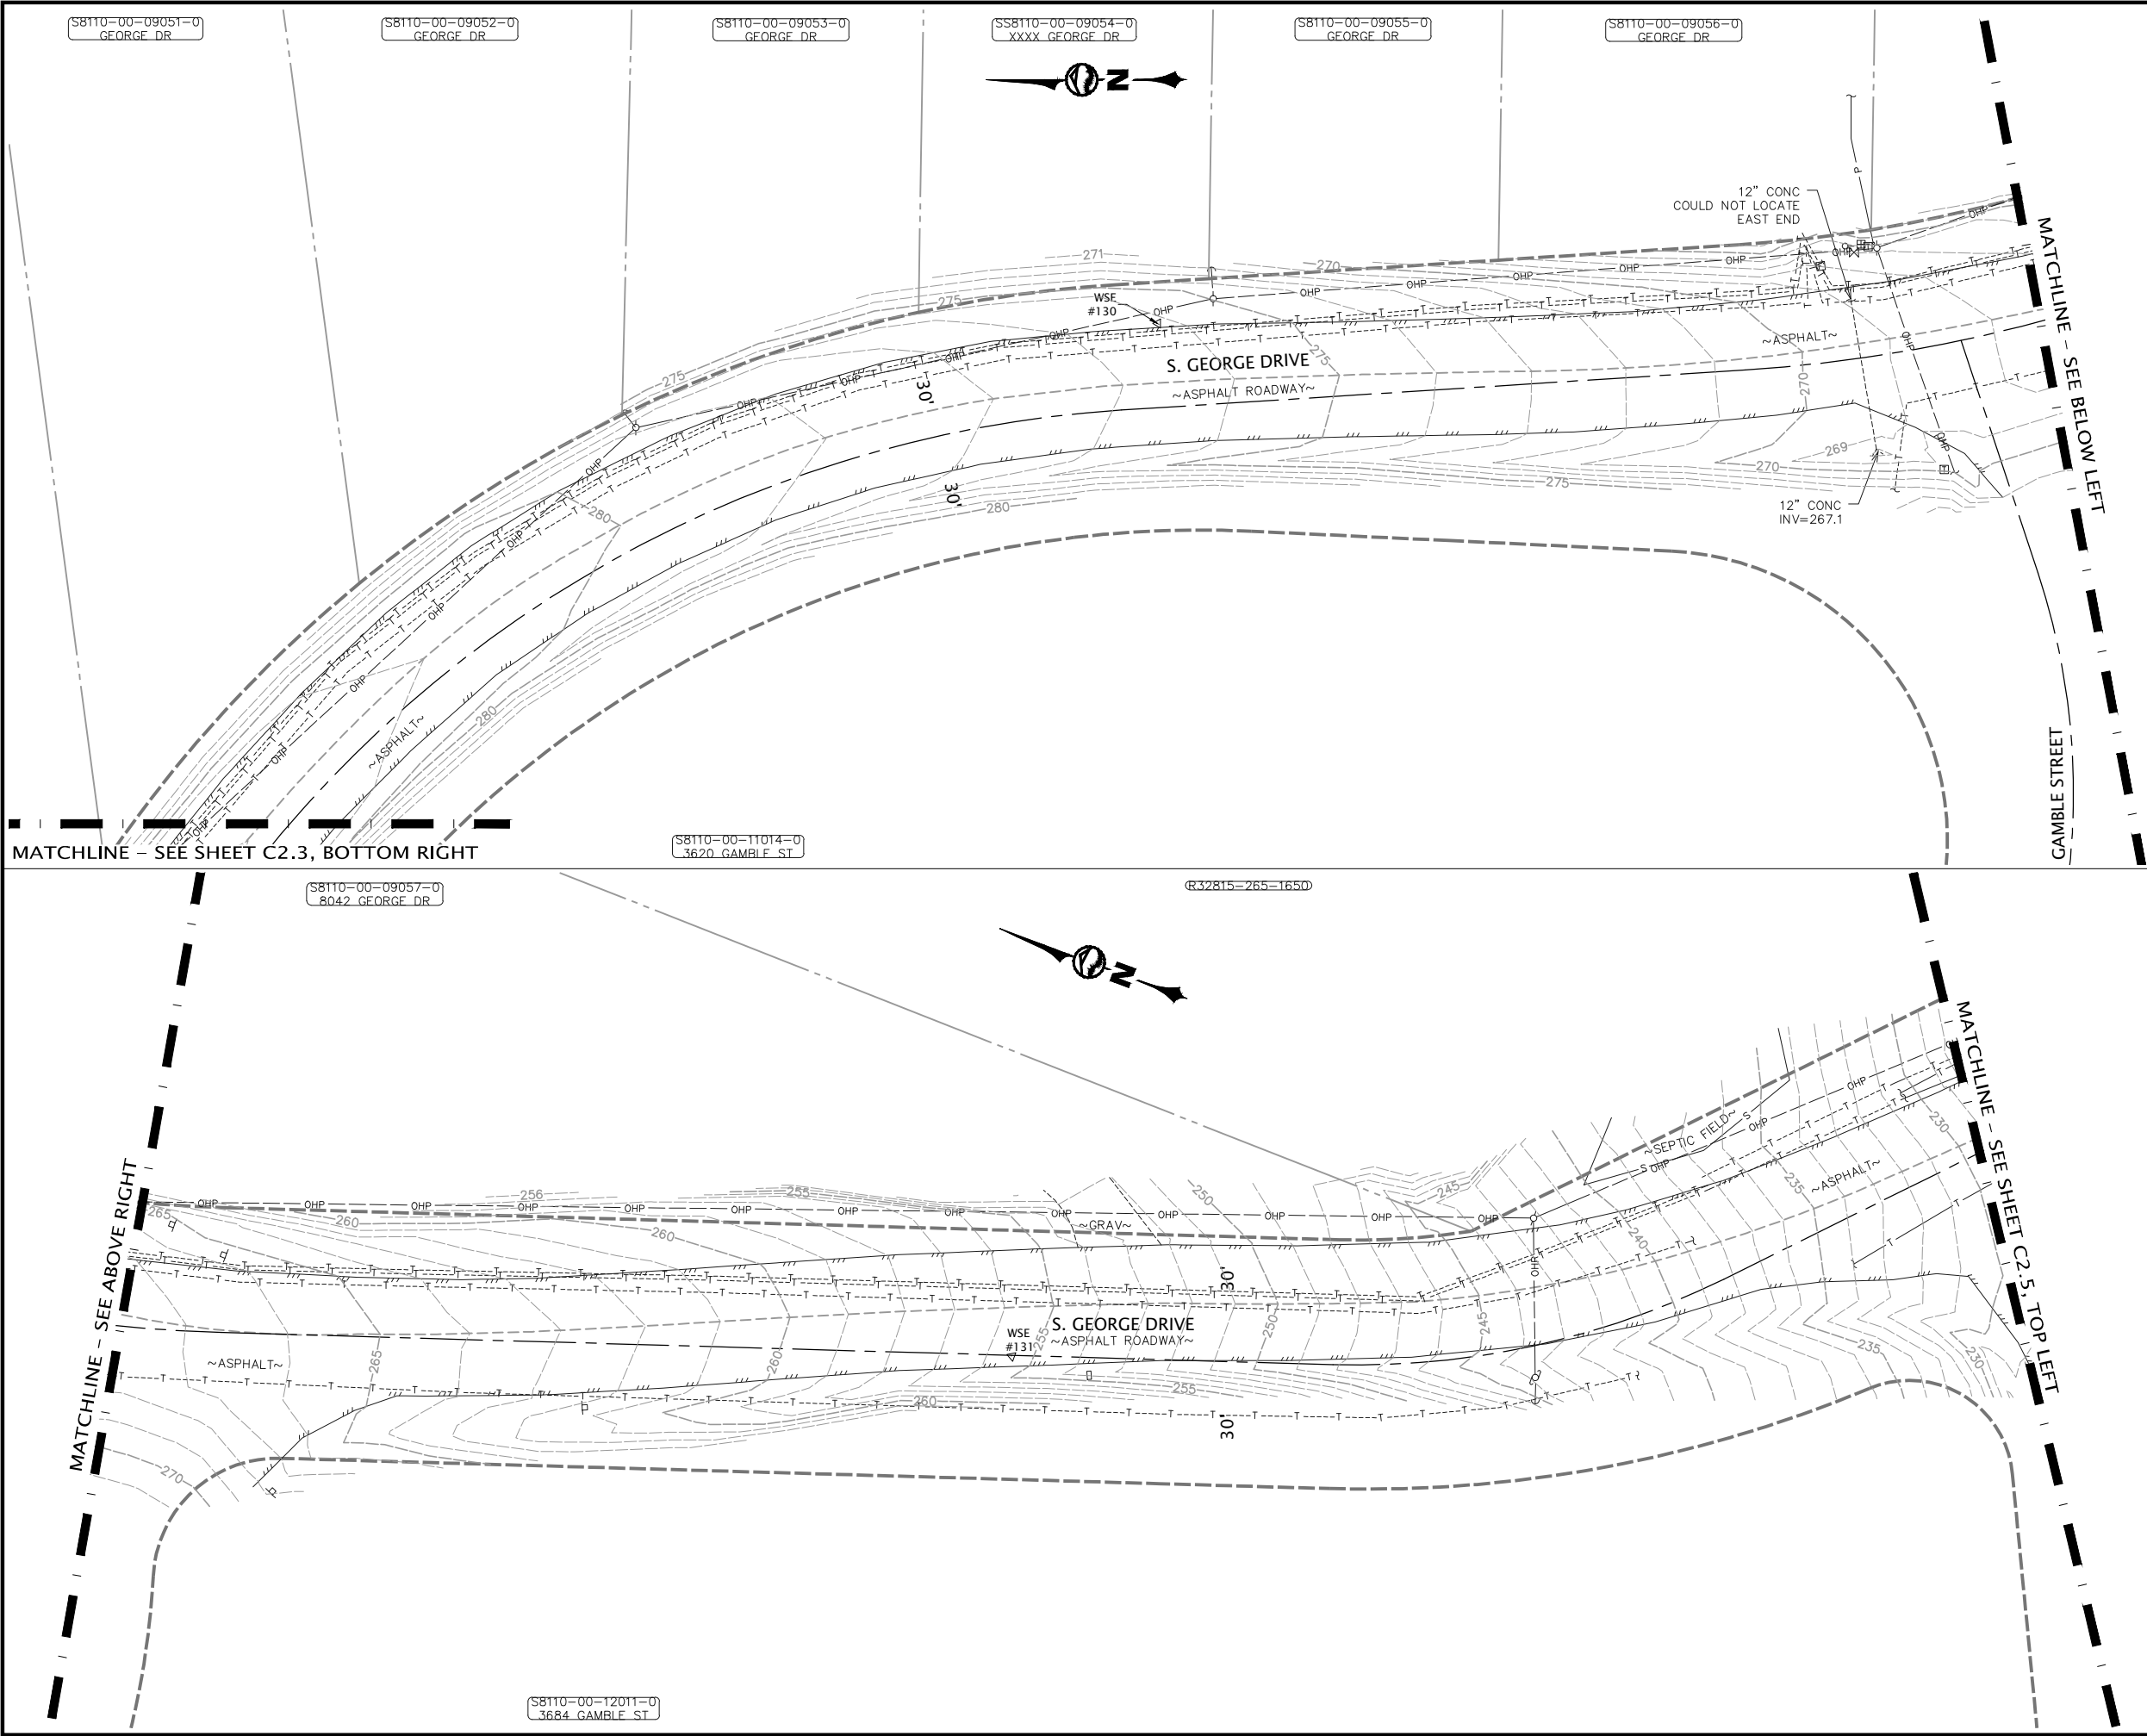

NO.

REVISIONS

BY

DATE

KEY MAP
NOT TO SCALE

LEGEND

= TOP VIEW,
THIS SHEET

= BOTTOM VIEW,
THIS SHEET

20 0 20 40

SCALE HORIZONTAL SCALE FEET

811

Call 811
two business days
before you dig

PRELIMINARY

SCATCHET HEAD WATER DISTRICT

WASHINGTON

WHIDBEY ISLAND

WATER SYSTEM IMPROVEMENTS

EXISTING CONDITIONS

SHEET

C2.4

DATE

12-8-22

SCALE

AS SHOWN

JOB NUMBER

2022-013

PAGE

X

OF

X

WILSON
ENGINEERING

WILSONENGINEERING.COM

PRELIMINARY

PROFESSIONAL LAND SURVEYOR
STATE OF WASHINGTON
NO. 12345
J. SMITH



DRAWN BY

CLM/JGS

CHECKED BY

PID

PLOT SETTINGS: AutoCAD PDF (General Documentation).pc3, ANSI full bleed B (17.00 x 11.00 inches), Portrait, 1:2, WE APWA_UNSCREENED.ctb
W:\2022\2022-013 SCATCHET HEAD WD WATER IMPROVEMENTS.MXD\DWG_V2019_NAD83_NAVD88\2022_2022-013 C2.1-C2.13 EXISTING CONDITIONS.DWG - 12/8/2022 1:53 PM - Jeff Smith

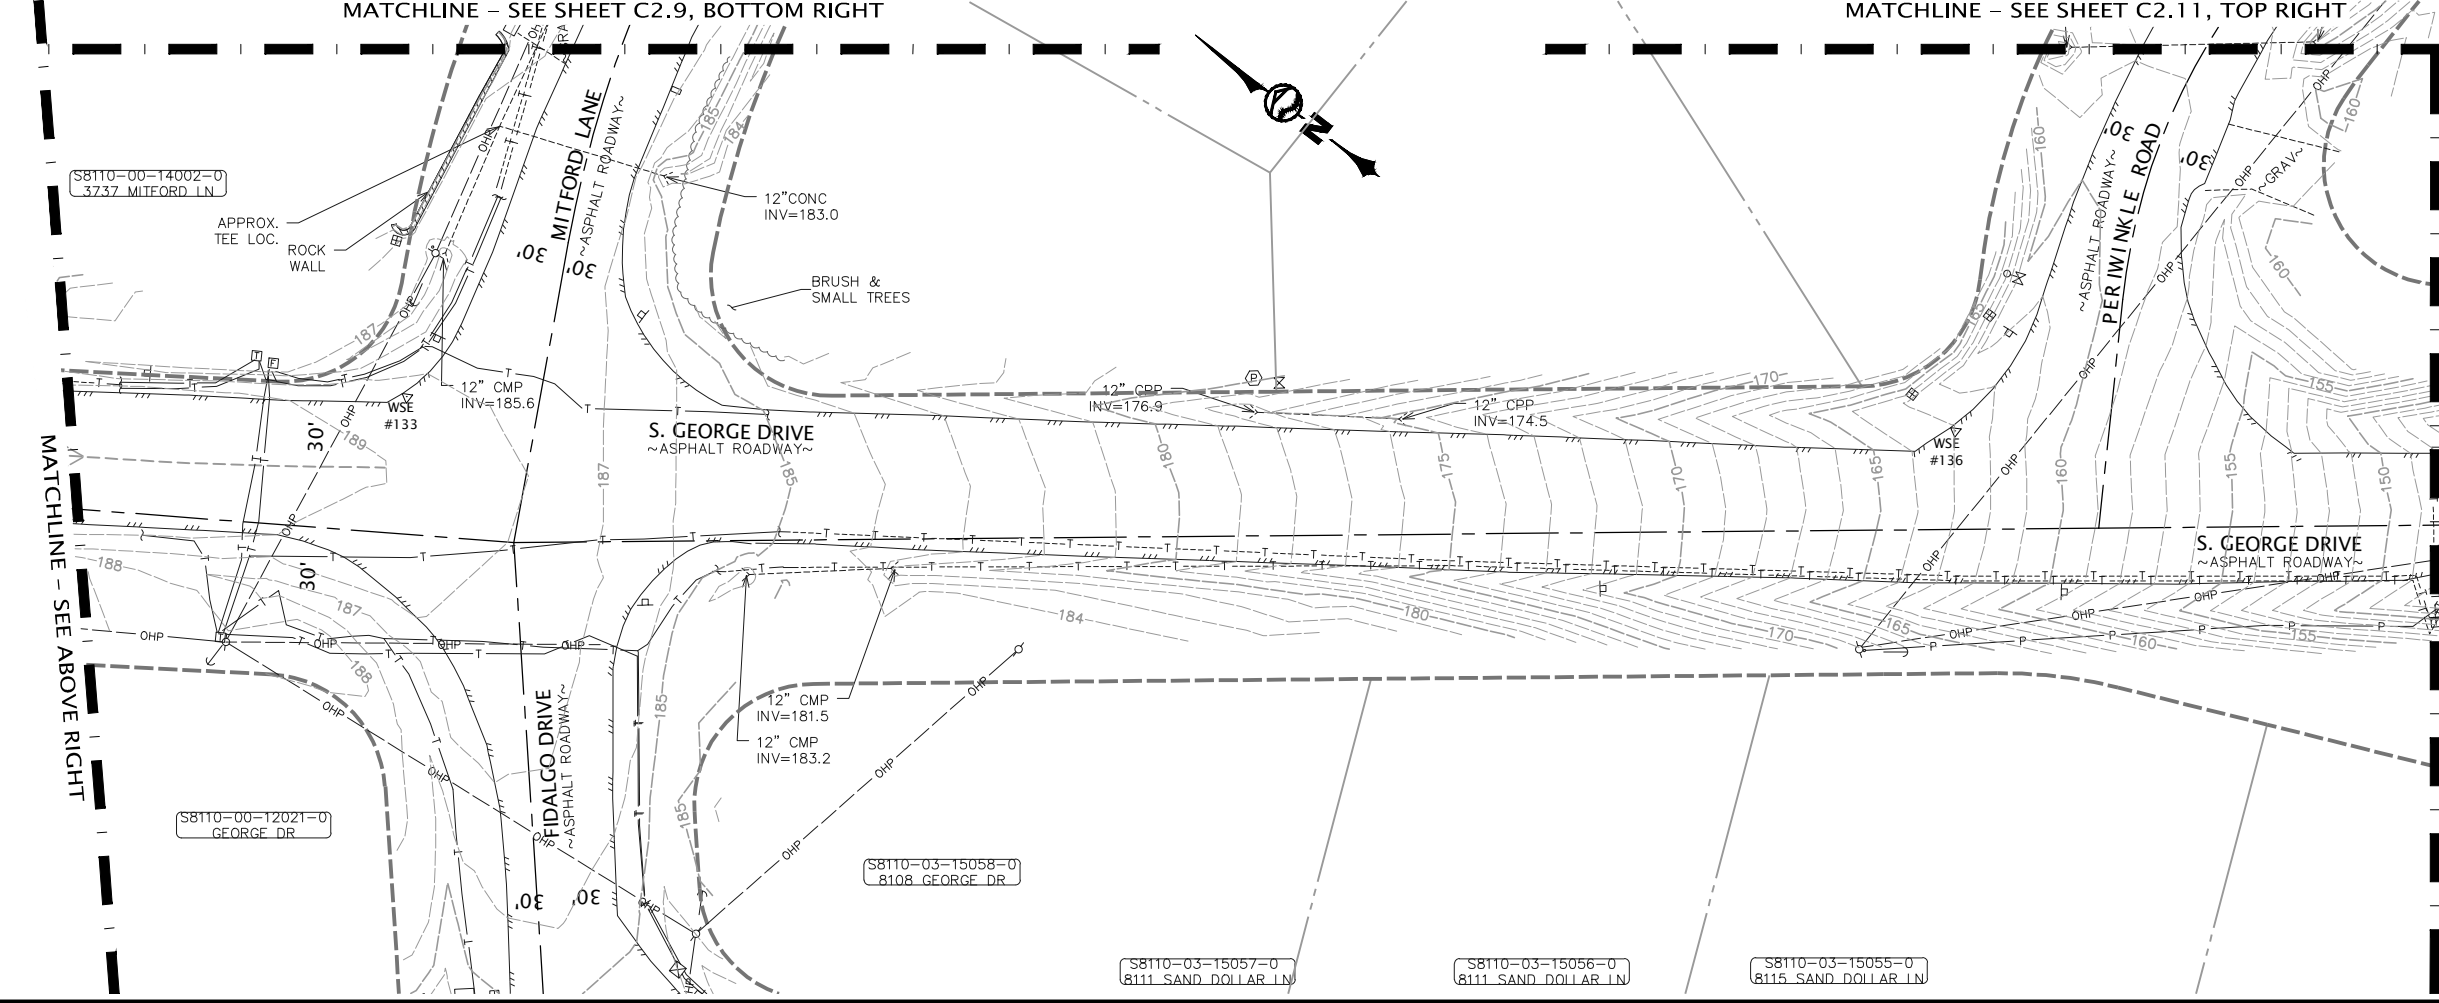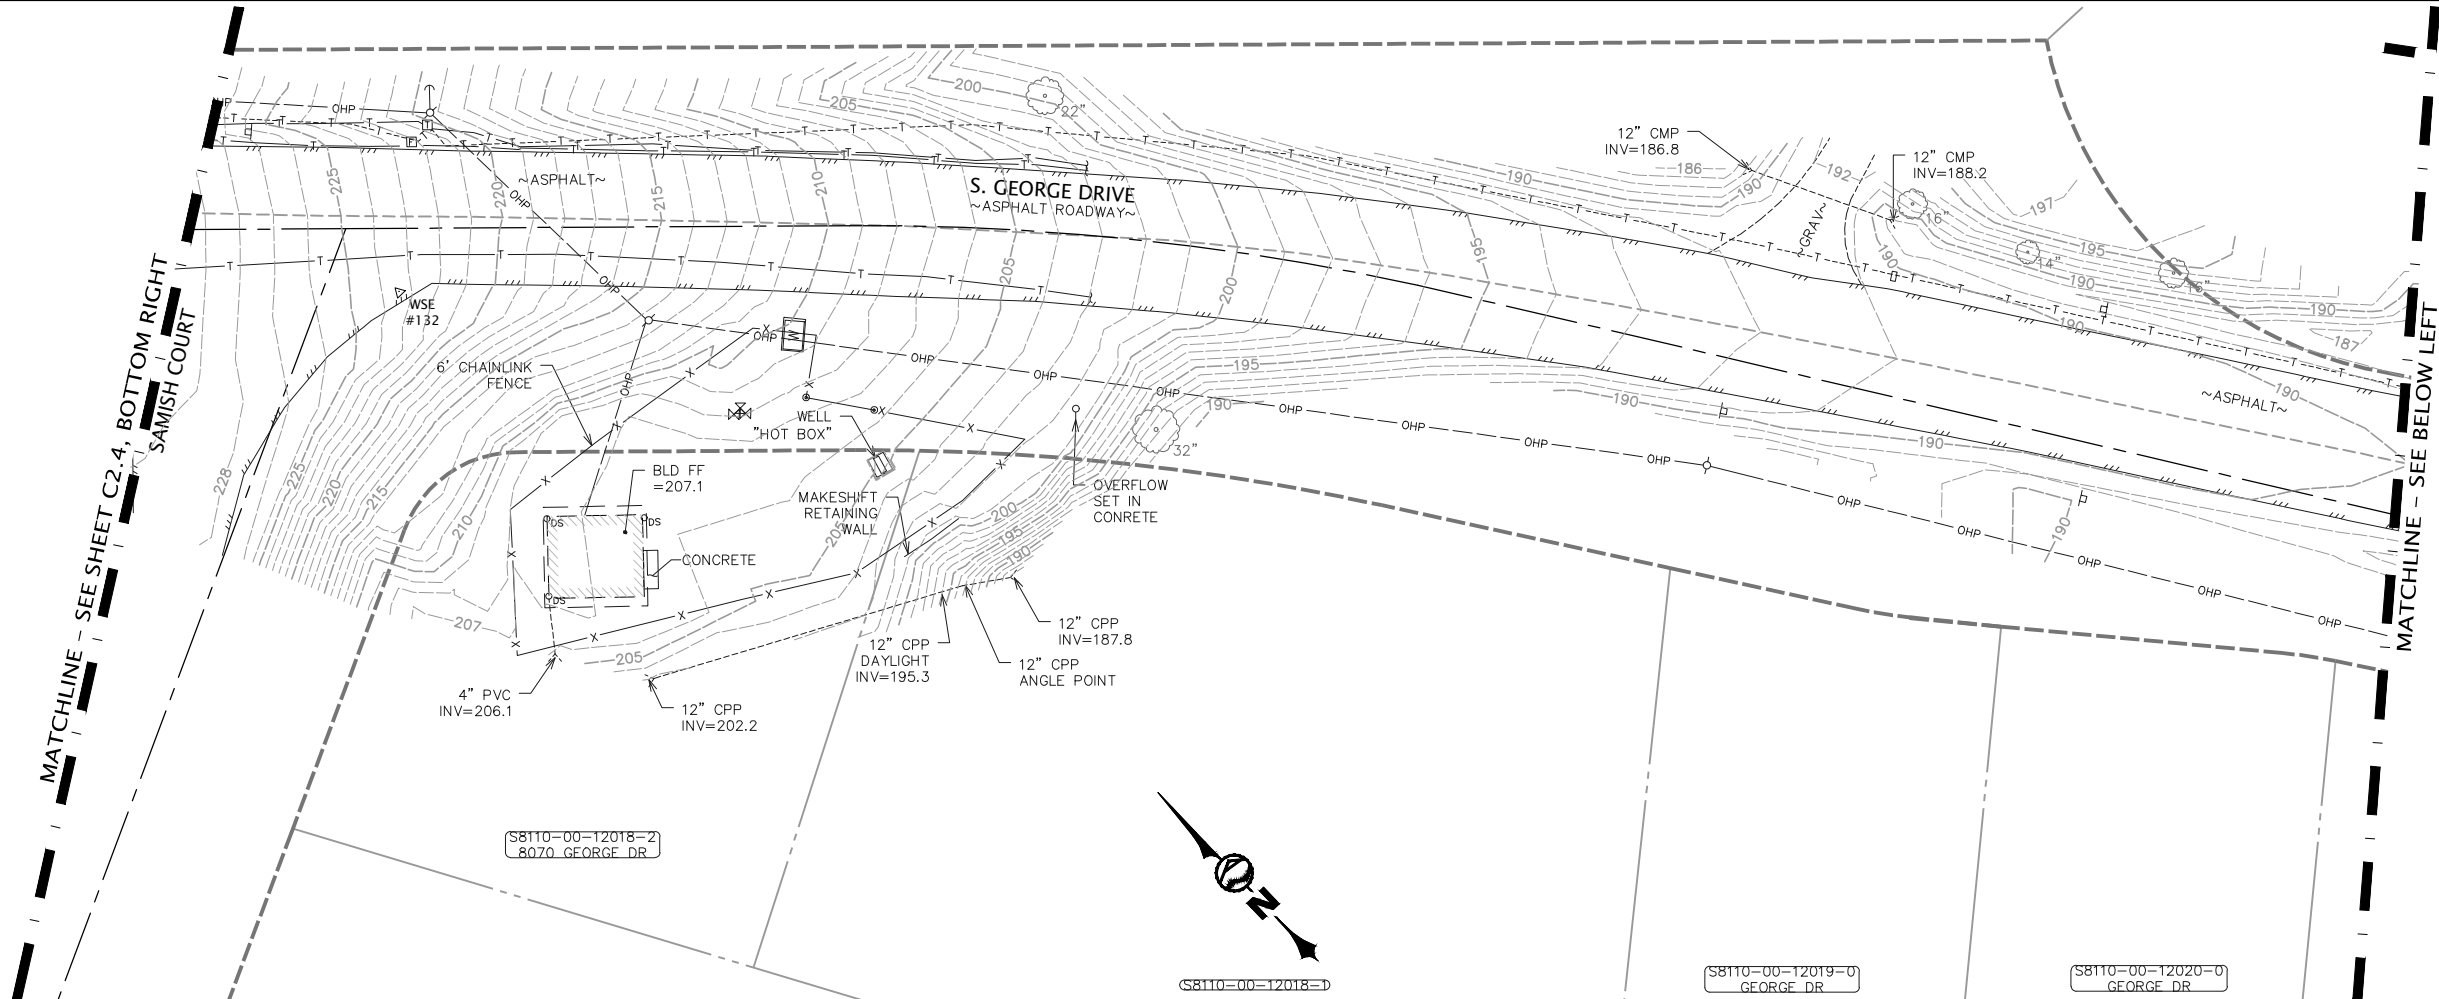

NO.		REVISIONS		BY	DATE

WILSON
ENGINEERING

WILSONENGINEERING.COM

PRELIMINARY

DRAWN BY		CHECKED BY		PID
WASHINGTON				

SCATCHET HEAD WATER DISTRICT

WATER SYSTEM IMPROVEMENTS


WHIDBEY ISLAND

SHEET	DATE	SCALE	AS SHOWN	JOB NUMBER
C2.5	12-8-22			2022-013

PRELIMINARY

DATE		SCALE		JOB NUMBER	
12-8-22				2022-013	
AS SHOWN		X		OF	
PAGE		X		EXISTING CONDITIONS	

PLOT SETTINGS: AutoCAD PDF (General Documentation).pc3, ANSI full bleed B (17.00 x 11.00 inches), Portrait, 1:2, WE APWA_UNSCREENED.ctb
W:\2022\2022-013 SCATCHET HEAD WD WATER IMPROVEMENTS.MXD\DWG_V2019_NAD08\2022_2022-013 C2.1-C2.13 EXISTING CONDITIONS.DWG - 12/8/2022 1:54 PM - Jeff Smith

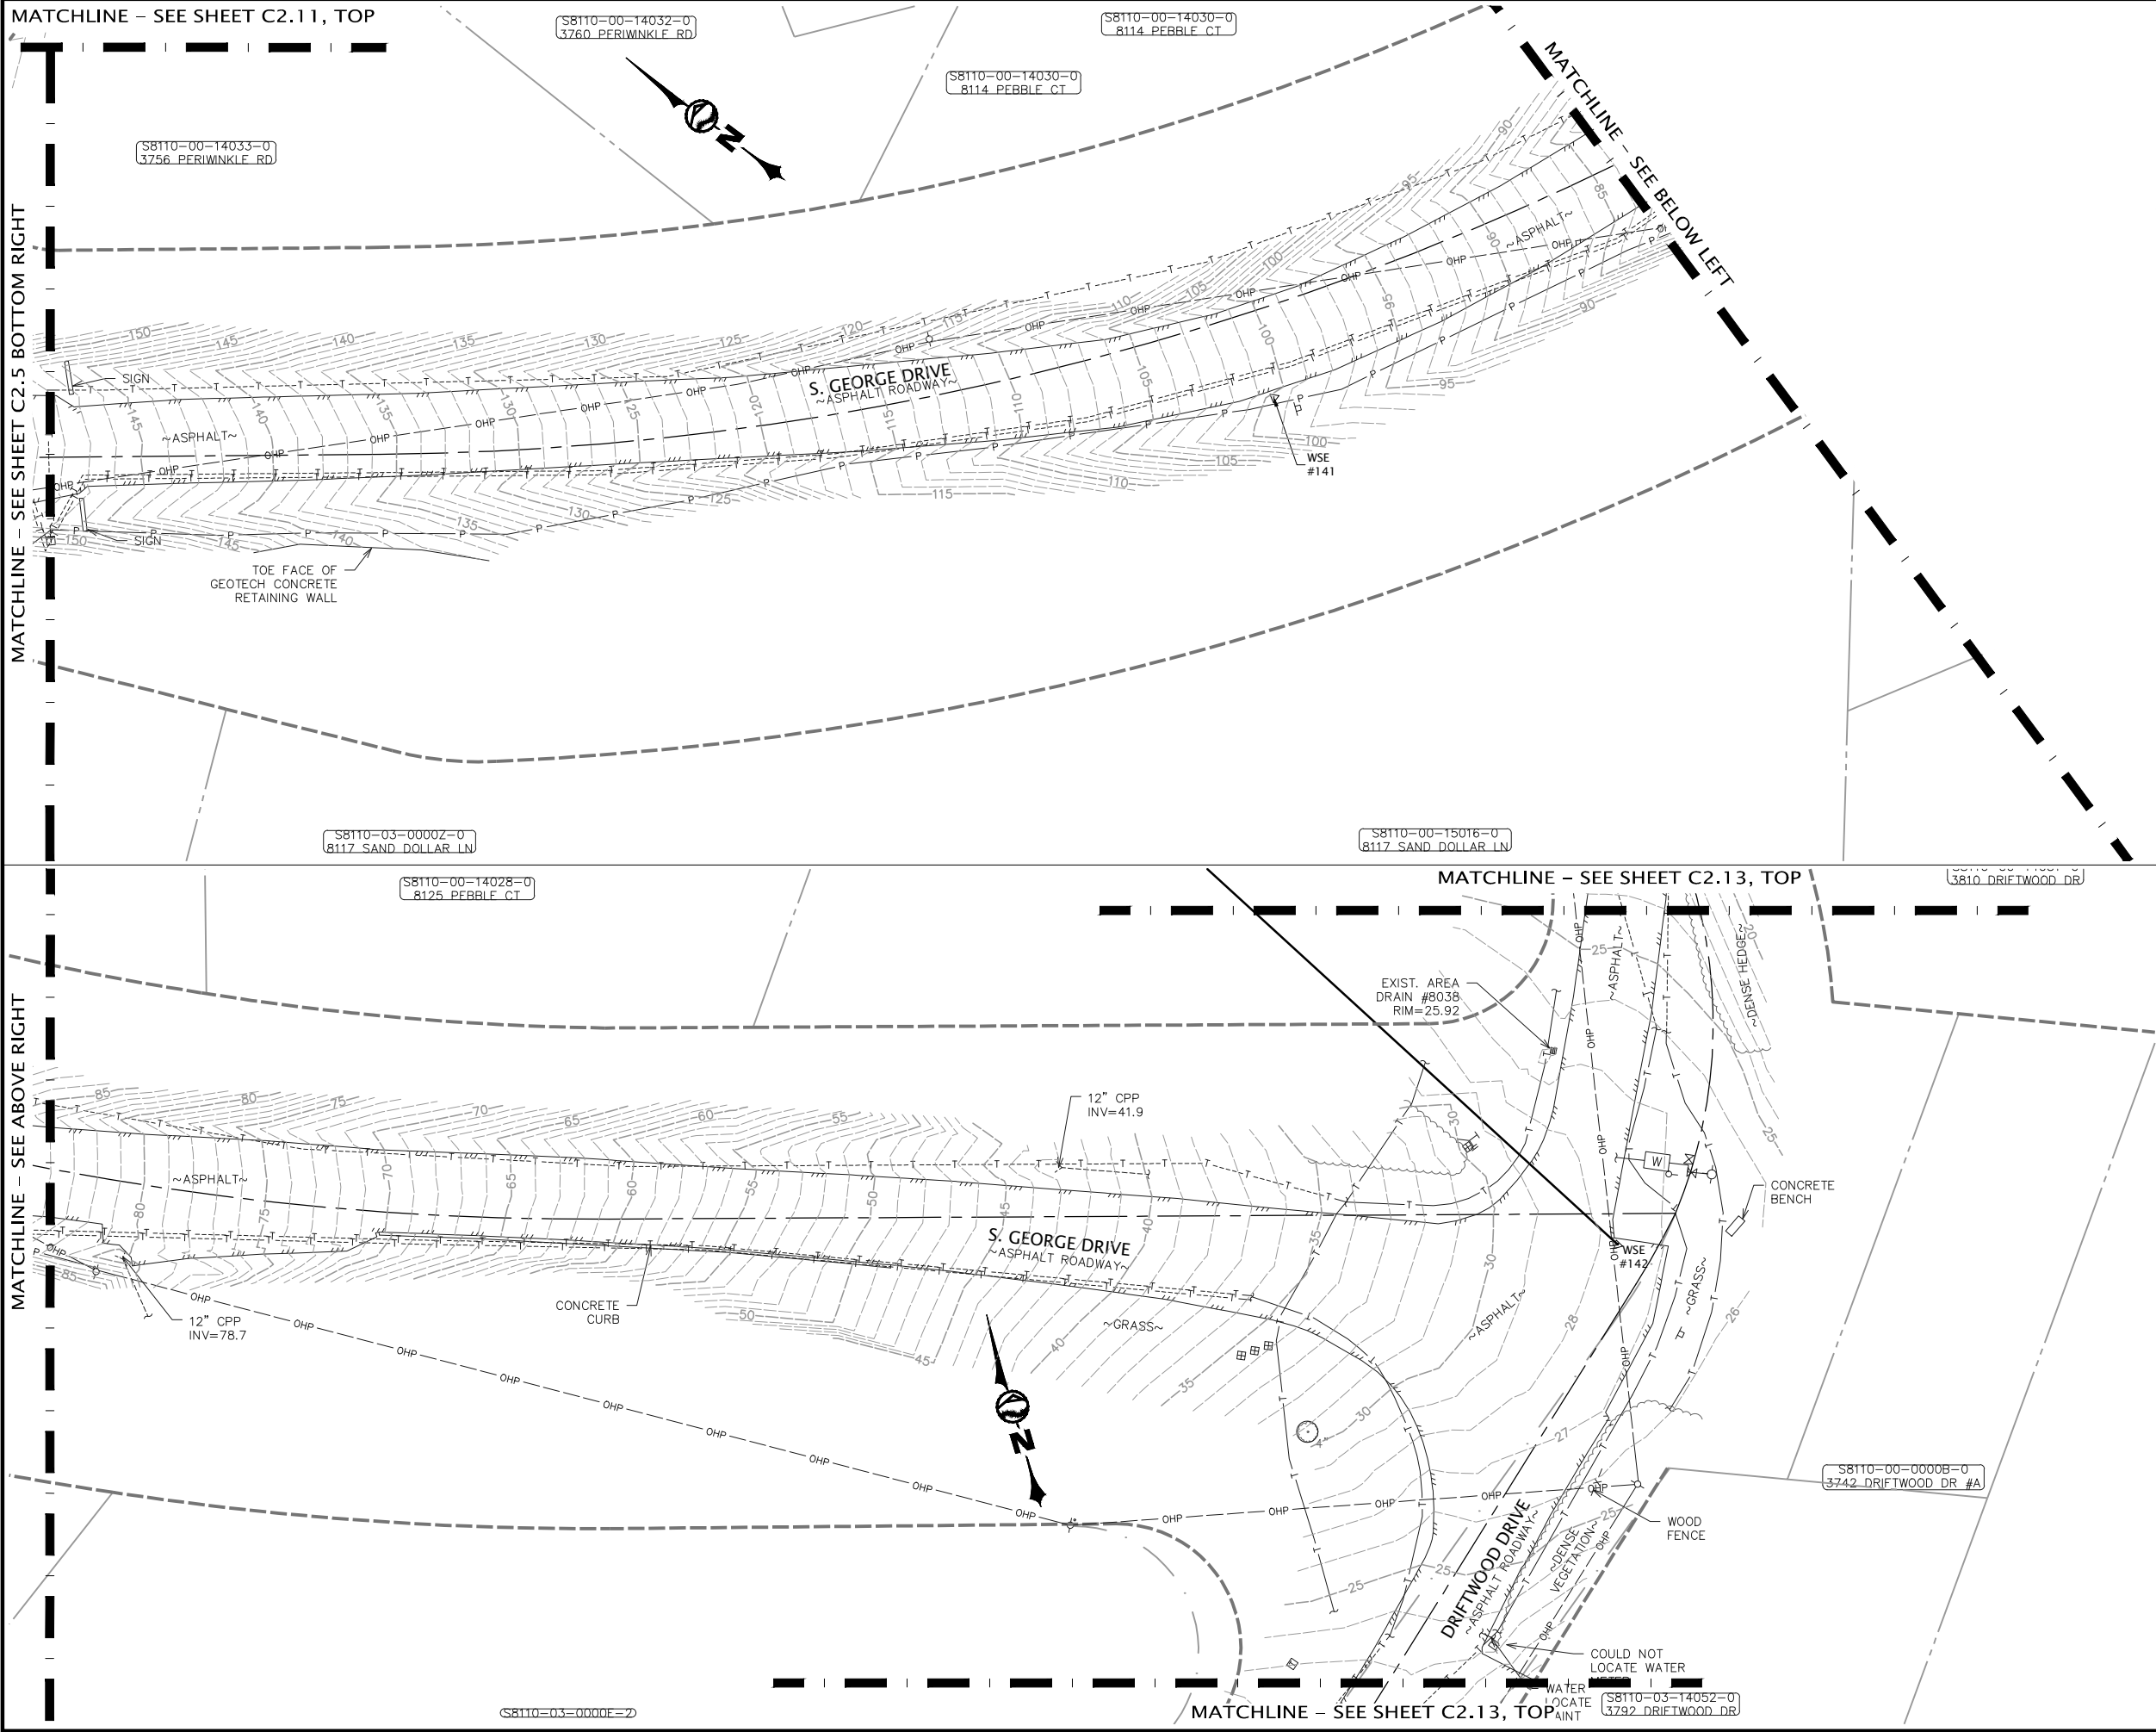

NO.		REVISIONS		BY	DATE

KEY MAP
NOT TO SCALE

LEGEND

- [Hatched Box] = TOP VIEW, THIS SHEET
- [Cross-hatched Box] = BOTTOM VIEW, THIS SHEET

20 0 20 40
SCALE HORIZONTAL SCALE FEET

811 Call 811
two business days
before you dig

PRELIMINARY

SCATCHET HEAD WATER DISTRICT		WASHINGTON		DRAWN BY	CHECKED BY
WHIDBEY ISLAND <td colspan="2">WASHINGTON<td>CLM/JGS<td>PID</td></td></td>		WASHINGTON <td>CLM/JGS<td>PID</td></td>		CLM/JGS <td>PID</td>	PID

WATER SYSTEM IMPROVEMENTS

EXISTING CONDITIONS

SHEET	DATE	SCALE	AS SHOWN	JOB NUMBER
C2.6	12-8-22	AS SHOWN	AS SHOWN	2022-013

PAGE

OF

X


X

WILSON
ENGINEERING

WILSONENGINEERING.COM

PRELIMINARY

PROFESSIONAL LAND SURVEYOR
STATE OF WASHINGTON
NO. 14000
JAMES WILSON

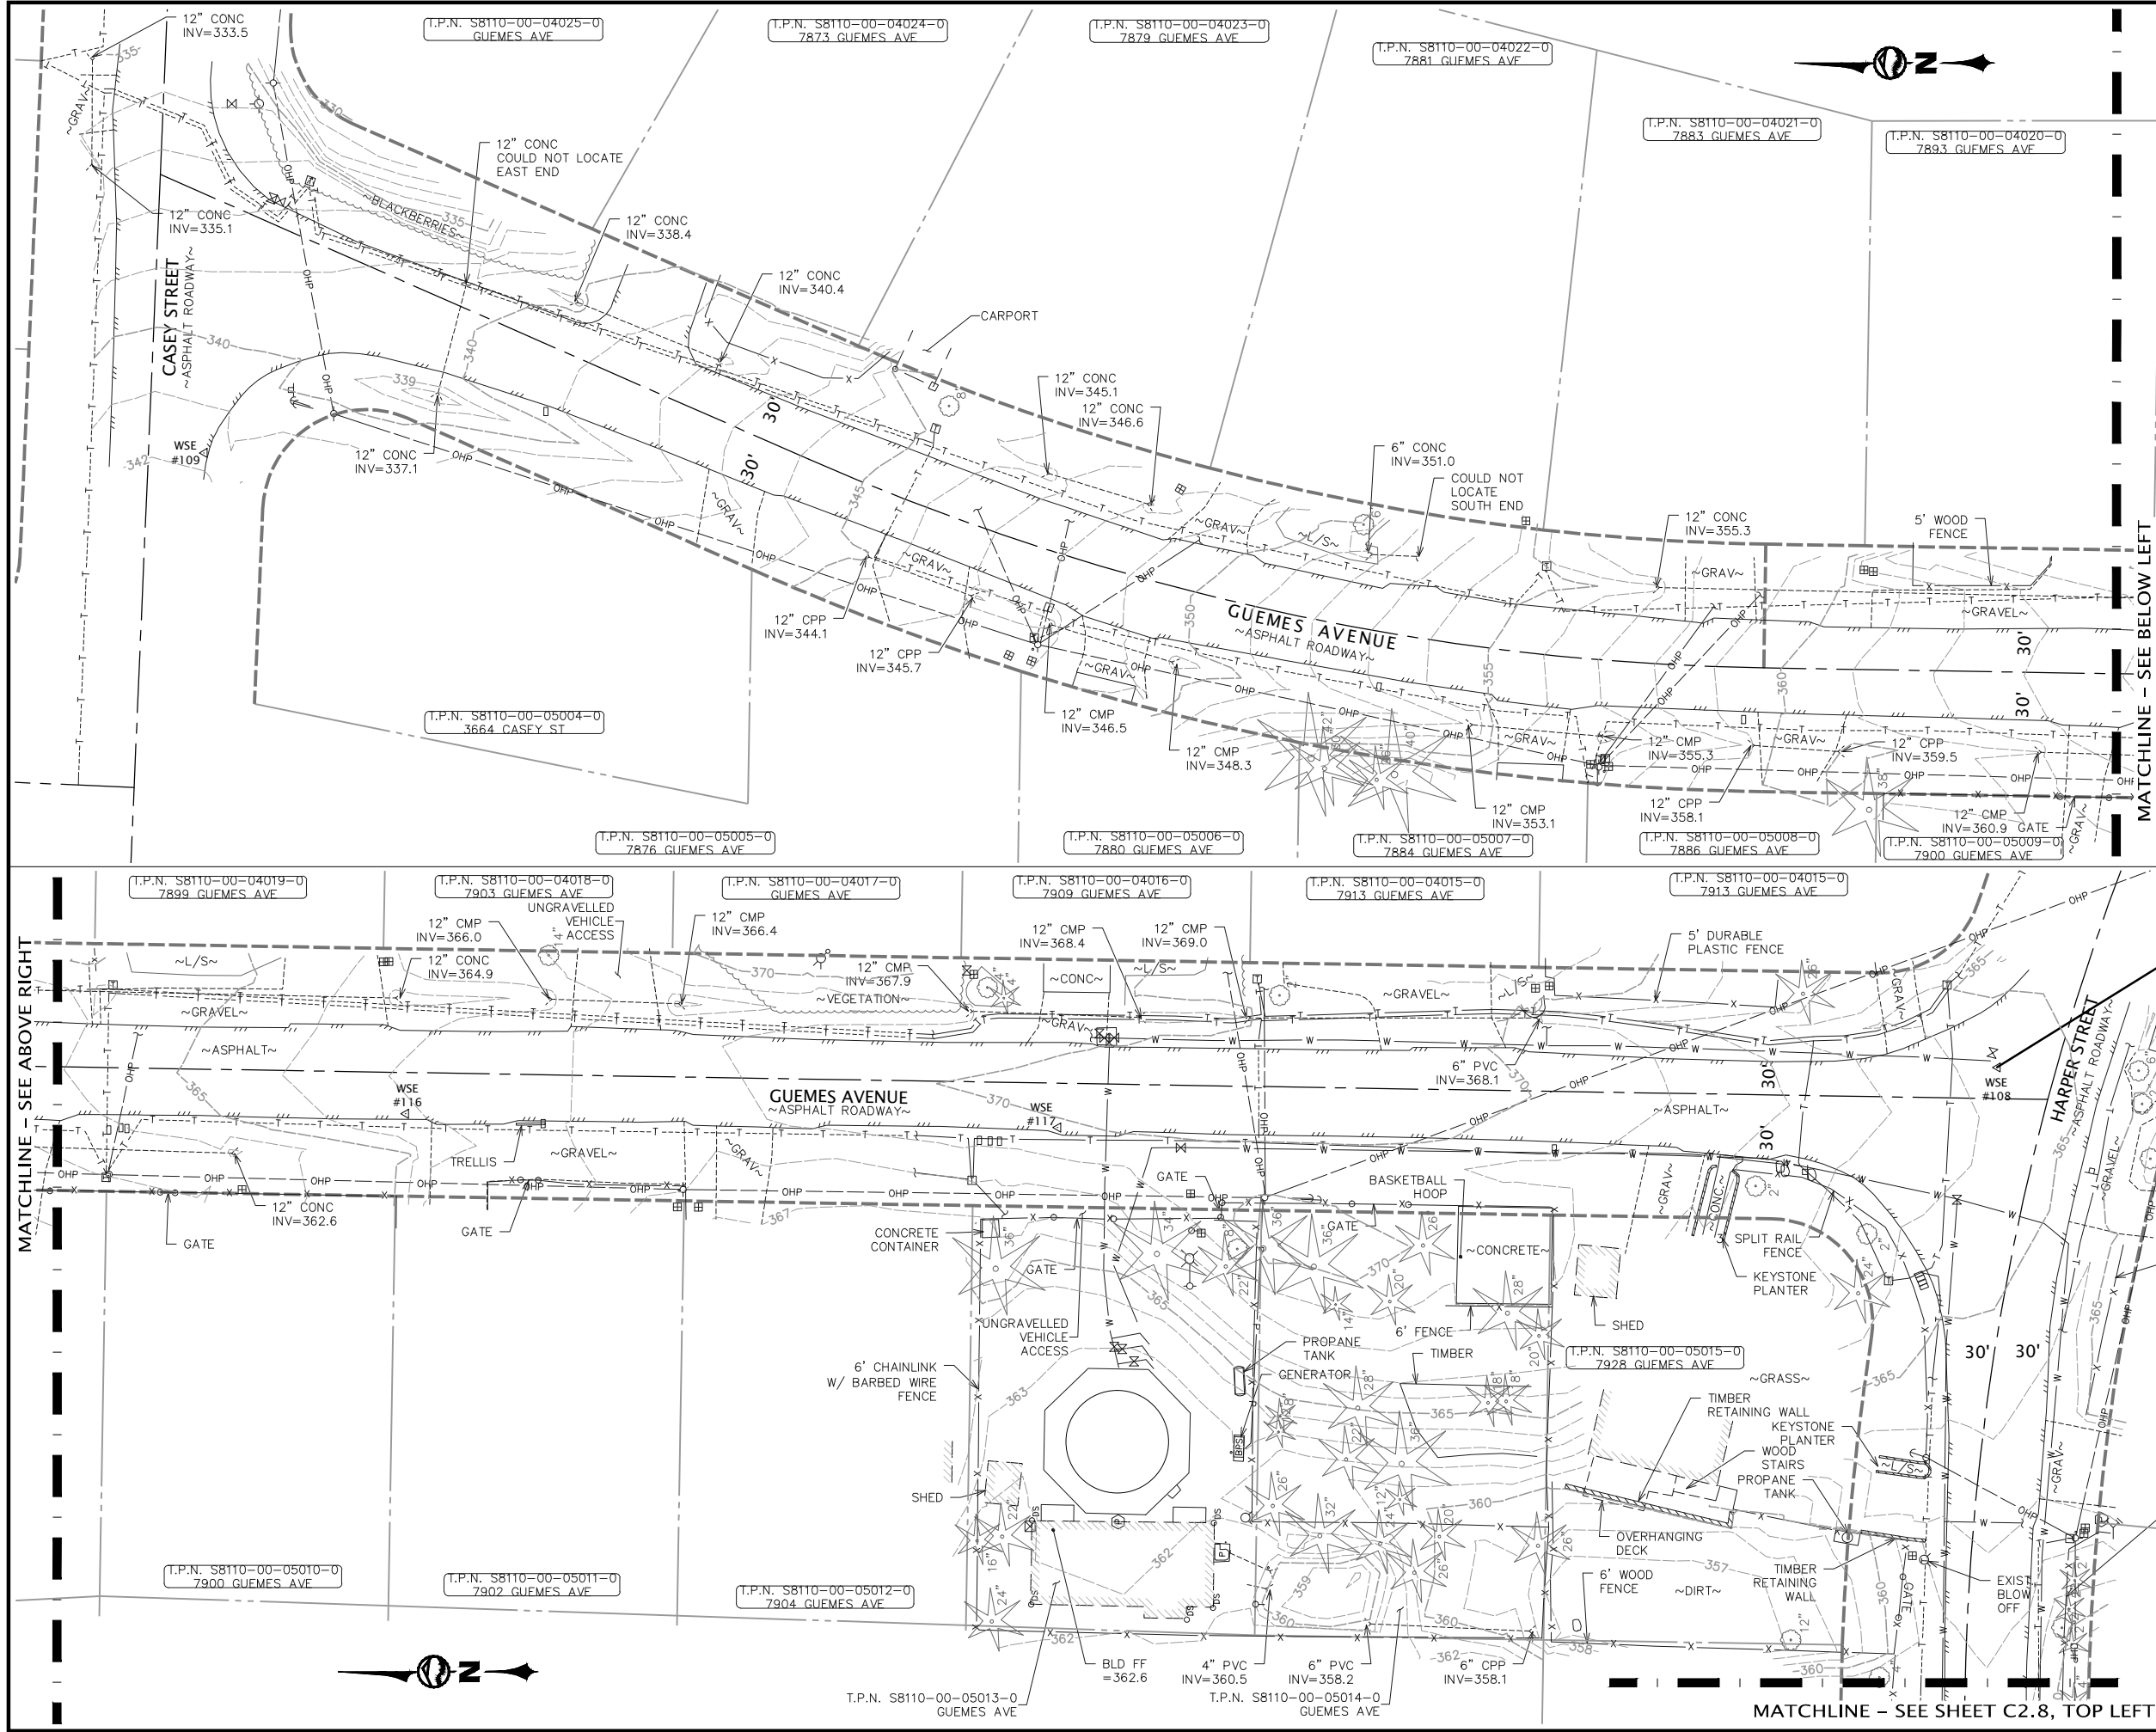

NO.	REVISIONS	BY	DATE

**KEY MAP
NOT TO SCALE**

LEGEND


= TOP VIEW, THIS SHEET

= BOTTOM VIEW, THIS SHEET


20 0 20 40
SCALE HORIZONTAL SCALE FEET

811 Call 811
two business days
before you dig

PRELIMINARY

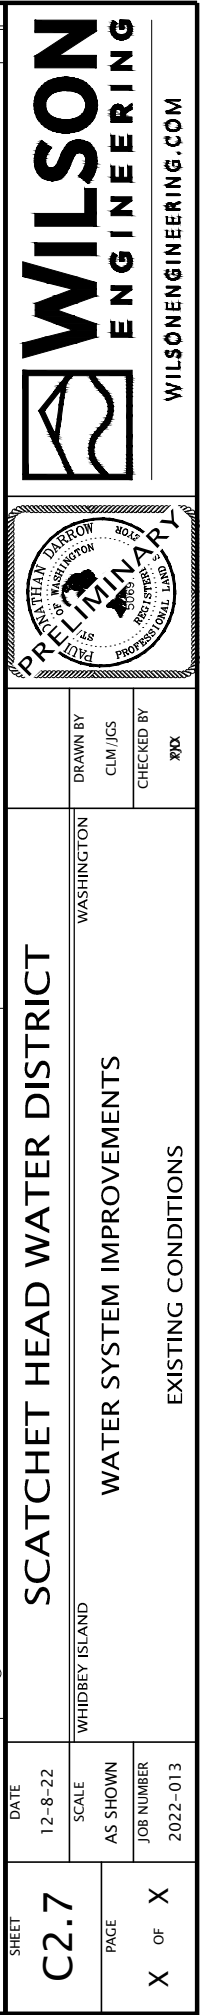

PLOT SETTINGS: AutoCAD PDF (General Documentation).pc3, ANSI full bleed B (17.00 x 11.00 inches), Portrait, 1:2, WE APWA_UNSCREENED.ctb
W:\2022\2022-013 SCATCHET HEAD WD WATER IMPROVEMENTS.MXD\2022_013 C2.1-C2.13 EXISTING CONDITIONS.DWG - 12/8/2022 1:54 PM - Jeff Smith

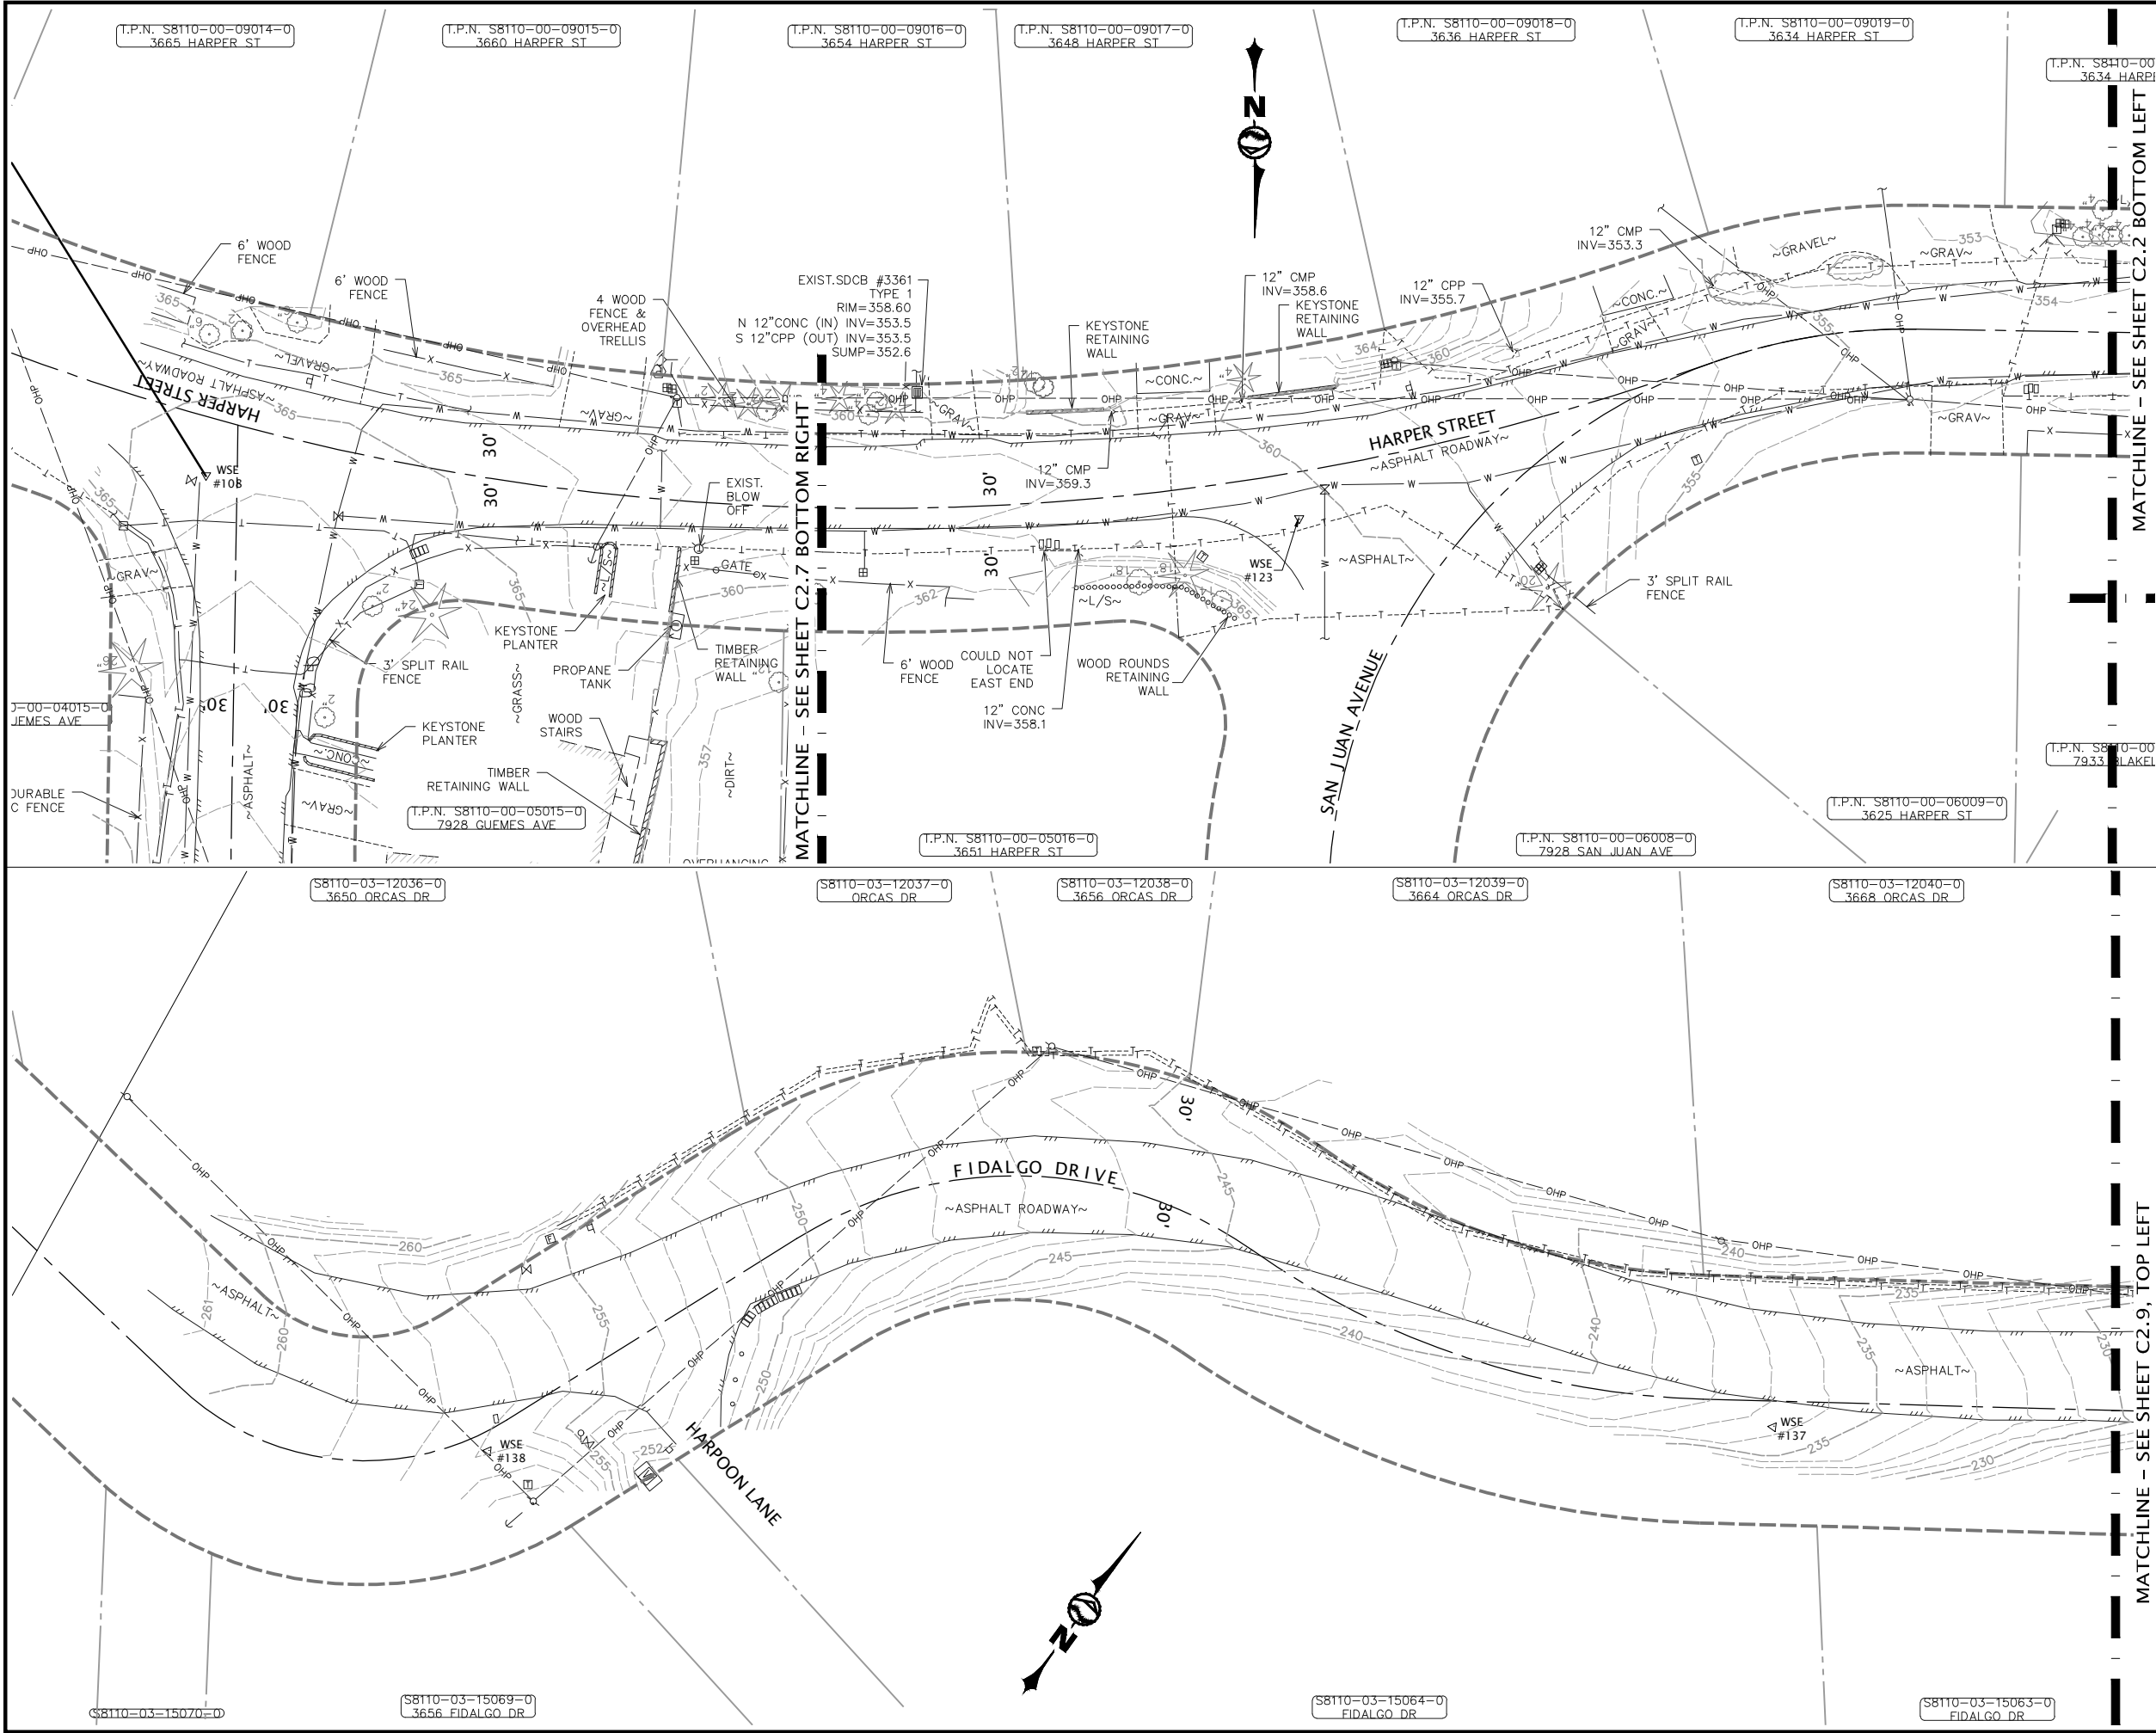

NO.		REVISIONS		BY	DATE

KEY MAP
NOT TO SCALE

LEGEND
 = TOP VIEW, THIS SHEET
 = BOTTOM VIEW, THIS SHEET

20 0 20 40
SCALE HORIZONTAL SCALE FEET

811 Call 811
two business days
before you dig

PRELIMINARY

SCATCHET HEAD WATER DISTRICT

WATER SYSTEM IMPROVEMENTS

EXISTING CONDITIONS

DATE 12-8-22

SCALE AS SHOWN

JOB NUMBER 2022-013

SHEET C2.8

PAGE X OF X


WILSON
ENGINEERING

WILSONENGINEERING.COM

PRELIMINARY

DRAWN BY		CHECKED BY		PID
CLM/JGS		CLM/JGS		PID

PLOT SETTINGS: AutoCAD PDF (General Documentation).pc3, ANSI full bleed B (17.00 x 11.00 inches), Portrait, 1:2, WE APWA_UNSCREENED.ctb
W:\2022\2022-013 SCATCHET HEAD WD WATER IMPROVEMENTS.MXD\DWG_V2019_NAD83_NAD88\2022_2022-013 C2.1-C2.13 EXISTING CONDITIONS.DWG - 12/8/2022 1:55 PM - Jeff Smith

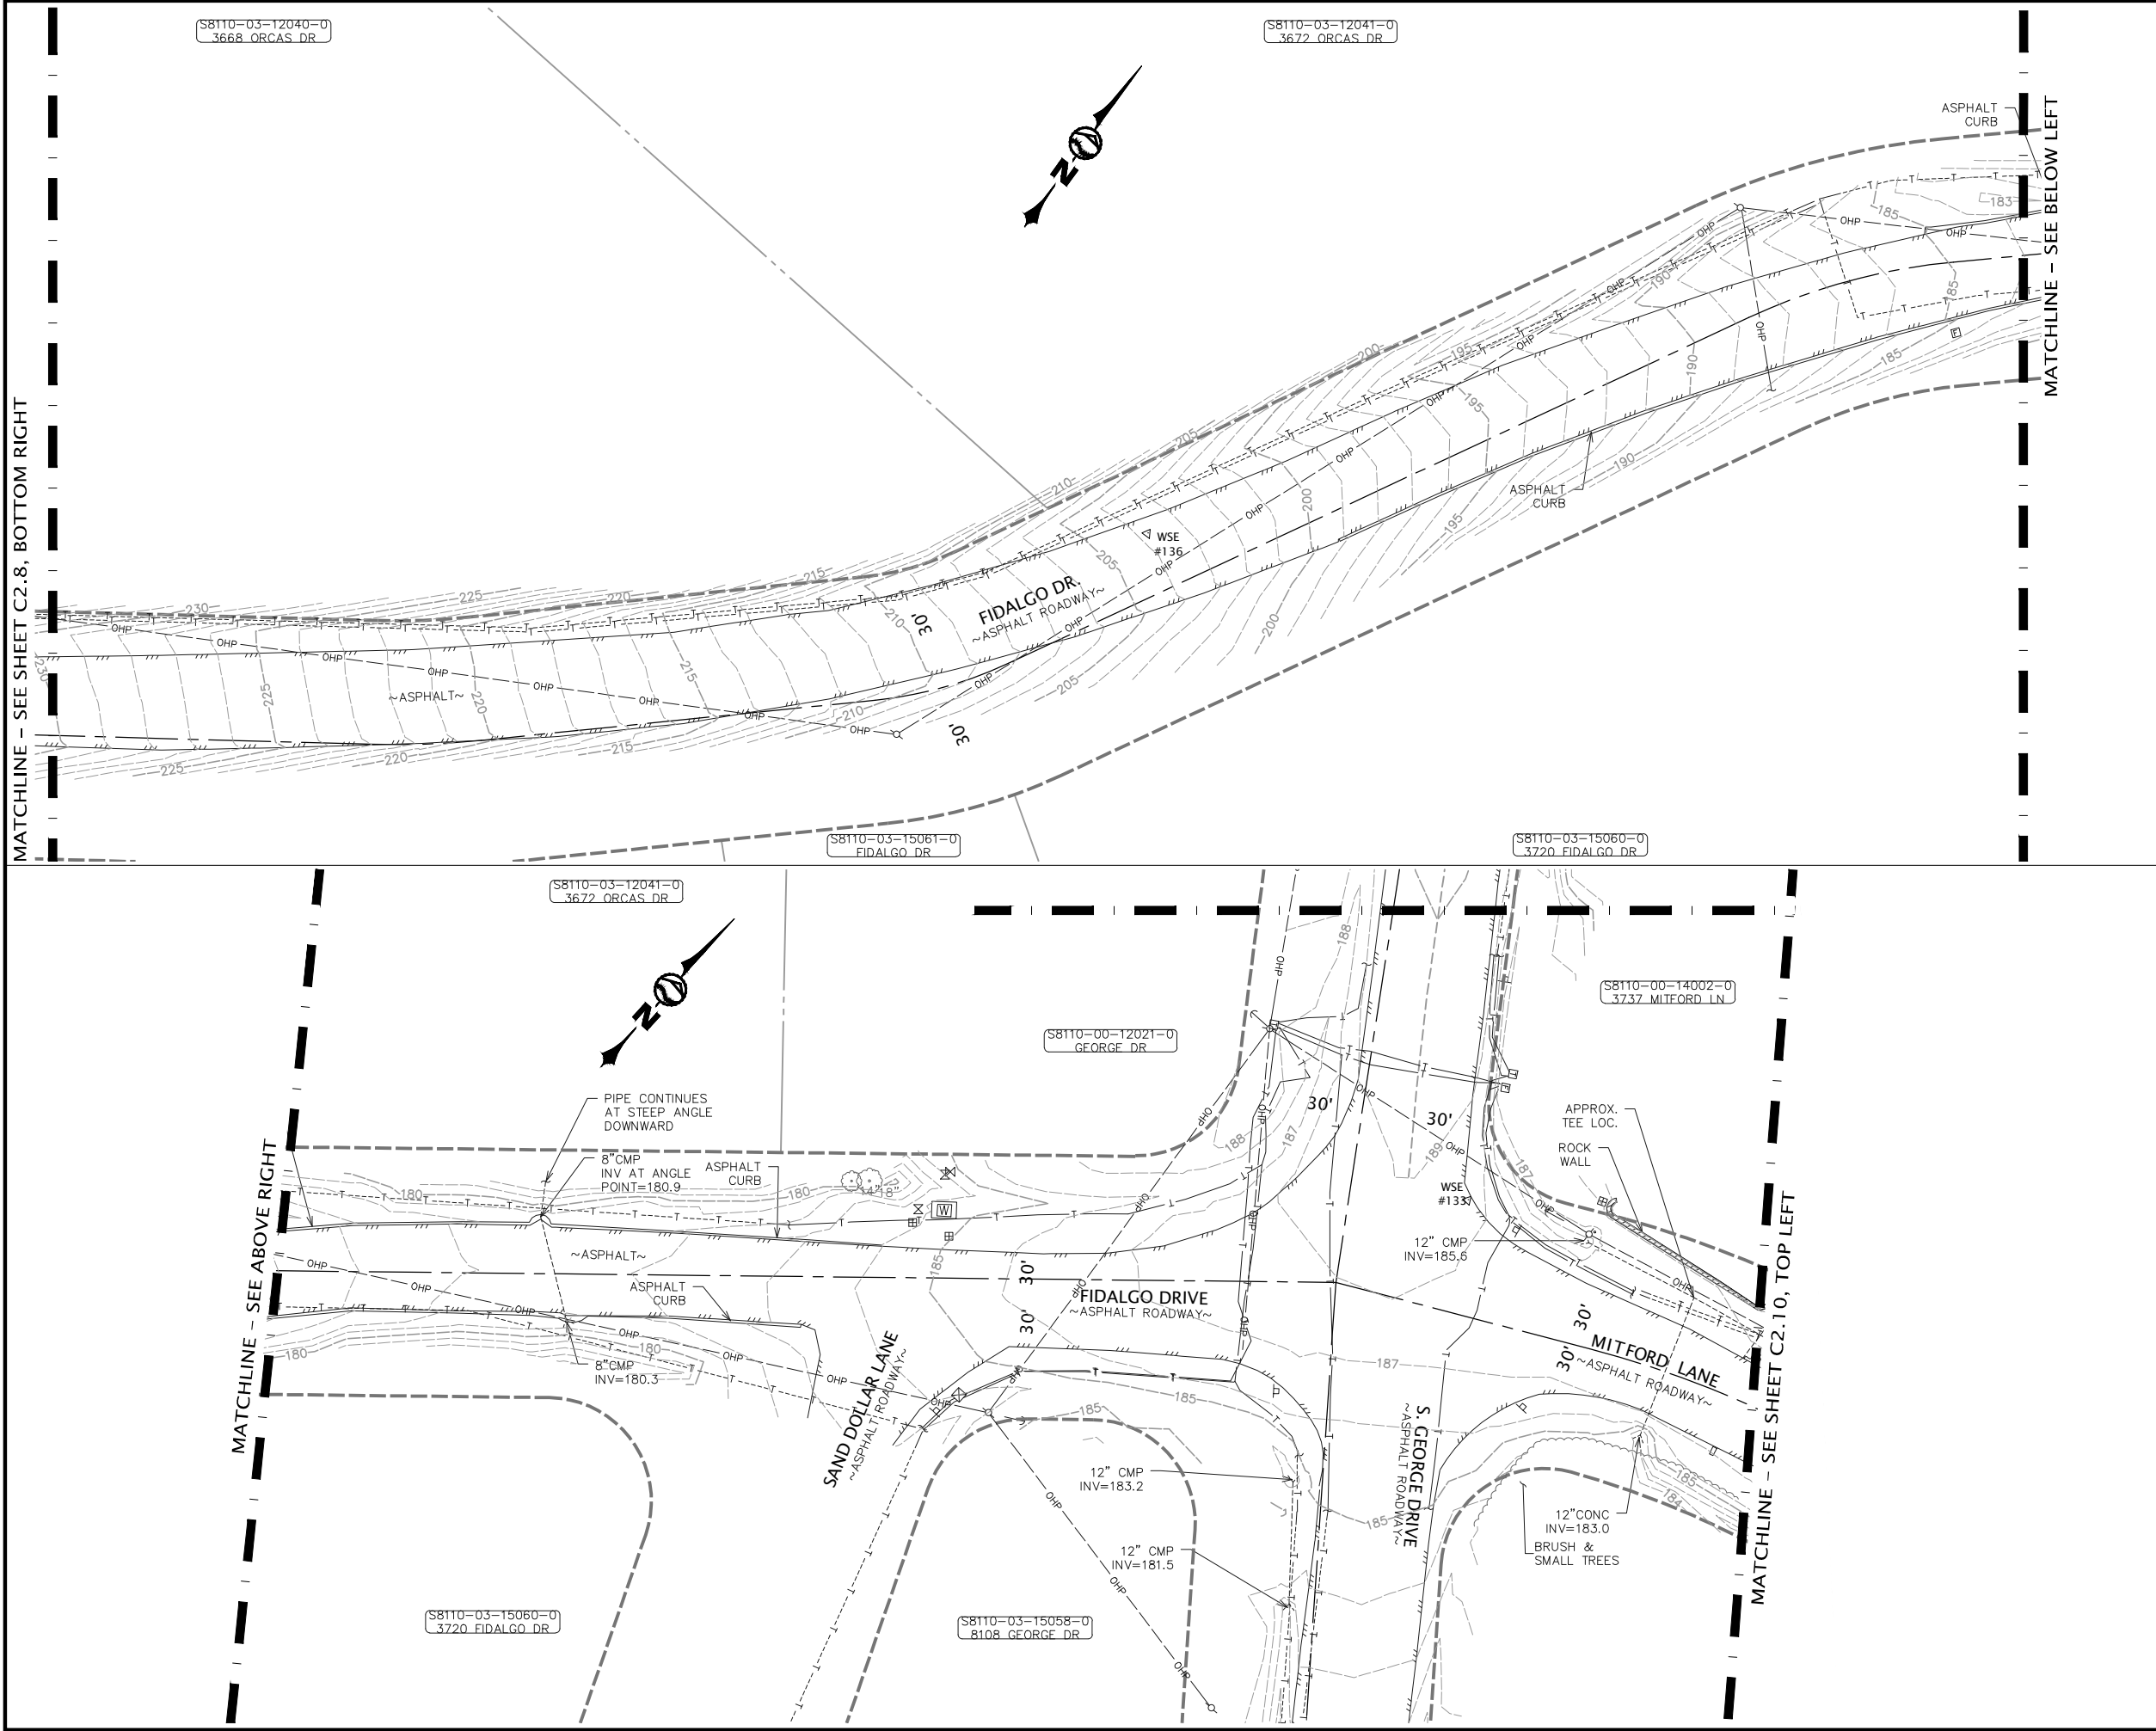

NO.

REVISIONS

BY

DATE

20

SCALE

HORIZONTAL SCALE

FEET

811

Call 811

two business days

before you dig

PRELIMINARY

KEY MAP

NOT TO SCALE

LEGEND

= TOP VIEW, THIS SHEET

= BOTTOM VIEW, THIS SHEET

BLAKELY AVENUE

GUEMES AVENUE

S. GEORGE DRIVE

FIDALGO DRIVE

MITFORD LANE

DRIFTWOOD DRIVE

SCATCHET HEAD WATER DISTRICT

WASHINGTON

WHIDBEY ISLAND

WATER SYSTEM IMPROVEMENTS

EXISTING CONDITIONS

SHEET

C2.9

PAGE

X

DATE

12-8-22

SCALE

AS SHOWN

JOB NUMBER

2022-013

OF


X

WILSON

ENGINEERING

WILSONENGINEERING.COM

PLOT SETTINGS: AutoCAD PDF (General Documentation).pc3, ANSI full bleed B (17.00 x 11.00 inches), Portrait, 1:2, WE APWA_UNSCREENED.ctb
W:\2022\2022-013 SCATCHET HEAD WD WATER IMPROVEMENTS.MXD\DWG_V2019_NAD88\2022_2022-013 C2.1-C2.13 EXISTING CONDITIONS.DWG - 12/8/2022 1:55 PM - Jeff Smith

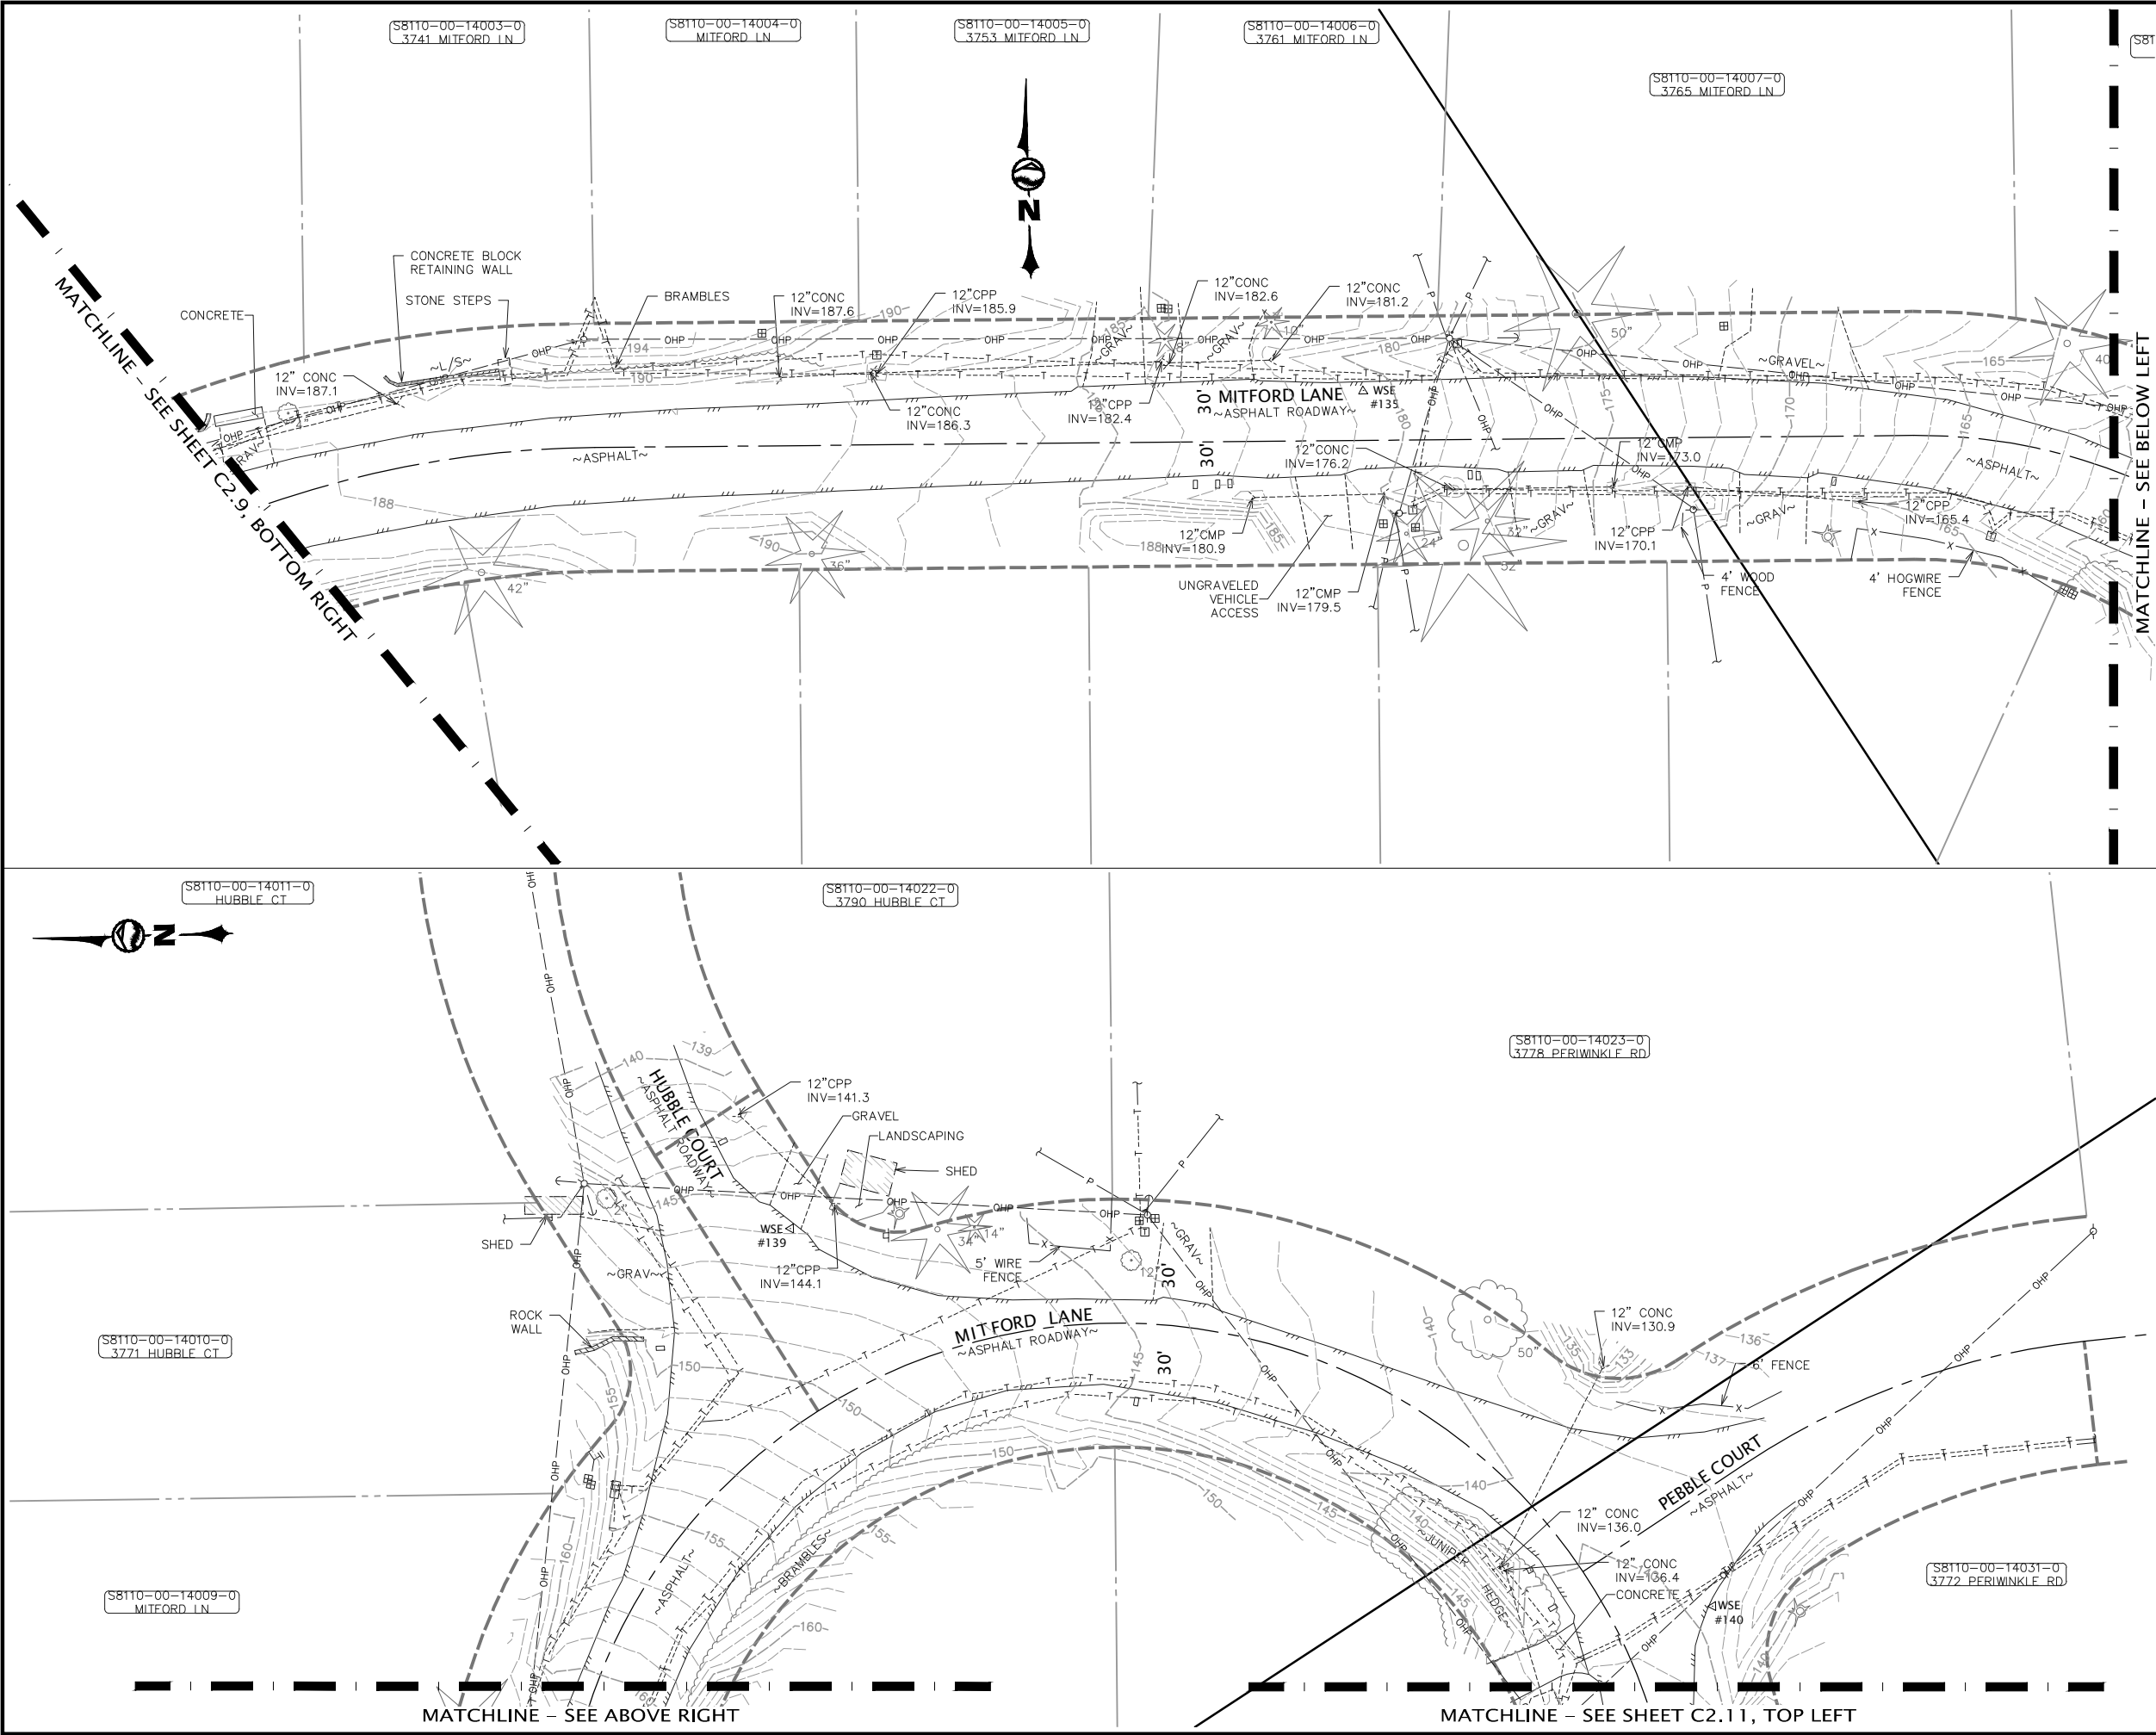

NO.

REVISIONS

BY

DATE

KEY MAP
NOT TO SCALE

LEGEND

20 0 20 40
SCALE HORIZONTAL SCALE FEET

811 Call 811
two business days
before you dig

PRELIMINARY

DATE
12-8-22

SCALE
AS SHOWN

SHEET
C2.10

WHIDBEY ISLAND

SCATCHET HEAD WATER DISTRICT

WASHINGTON

WATER SYSTEM IMPROVEMENTS

EXISTING CONDITIONS

PAGE
X

OF
X

JOB NUMBER
2022-013

WILSON
ENGINEERING


WILSONENGINEERING.COM

PRELIMINARY

DRAWN BY
CLM/JGS

CHECKED BY
PID

PLOT SETTINGS: AutoCAD PDF (General Documentation).pc3, ANSI full bleed B (17.00 x 11.00 inches), Portrait, 1:2, WE APWA_UNSCREENED.ctb
W:\2022\2022-013 SCATCHET HEAD WD WATER IMPROVEMENTS.MXD\2022-013 C2.1-C2.13 EXISTING CONDITIONS.DWG - 12/8/2022 1:55 PM - Jeff Smith

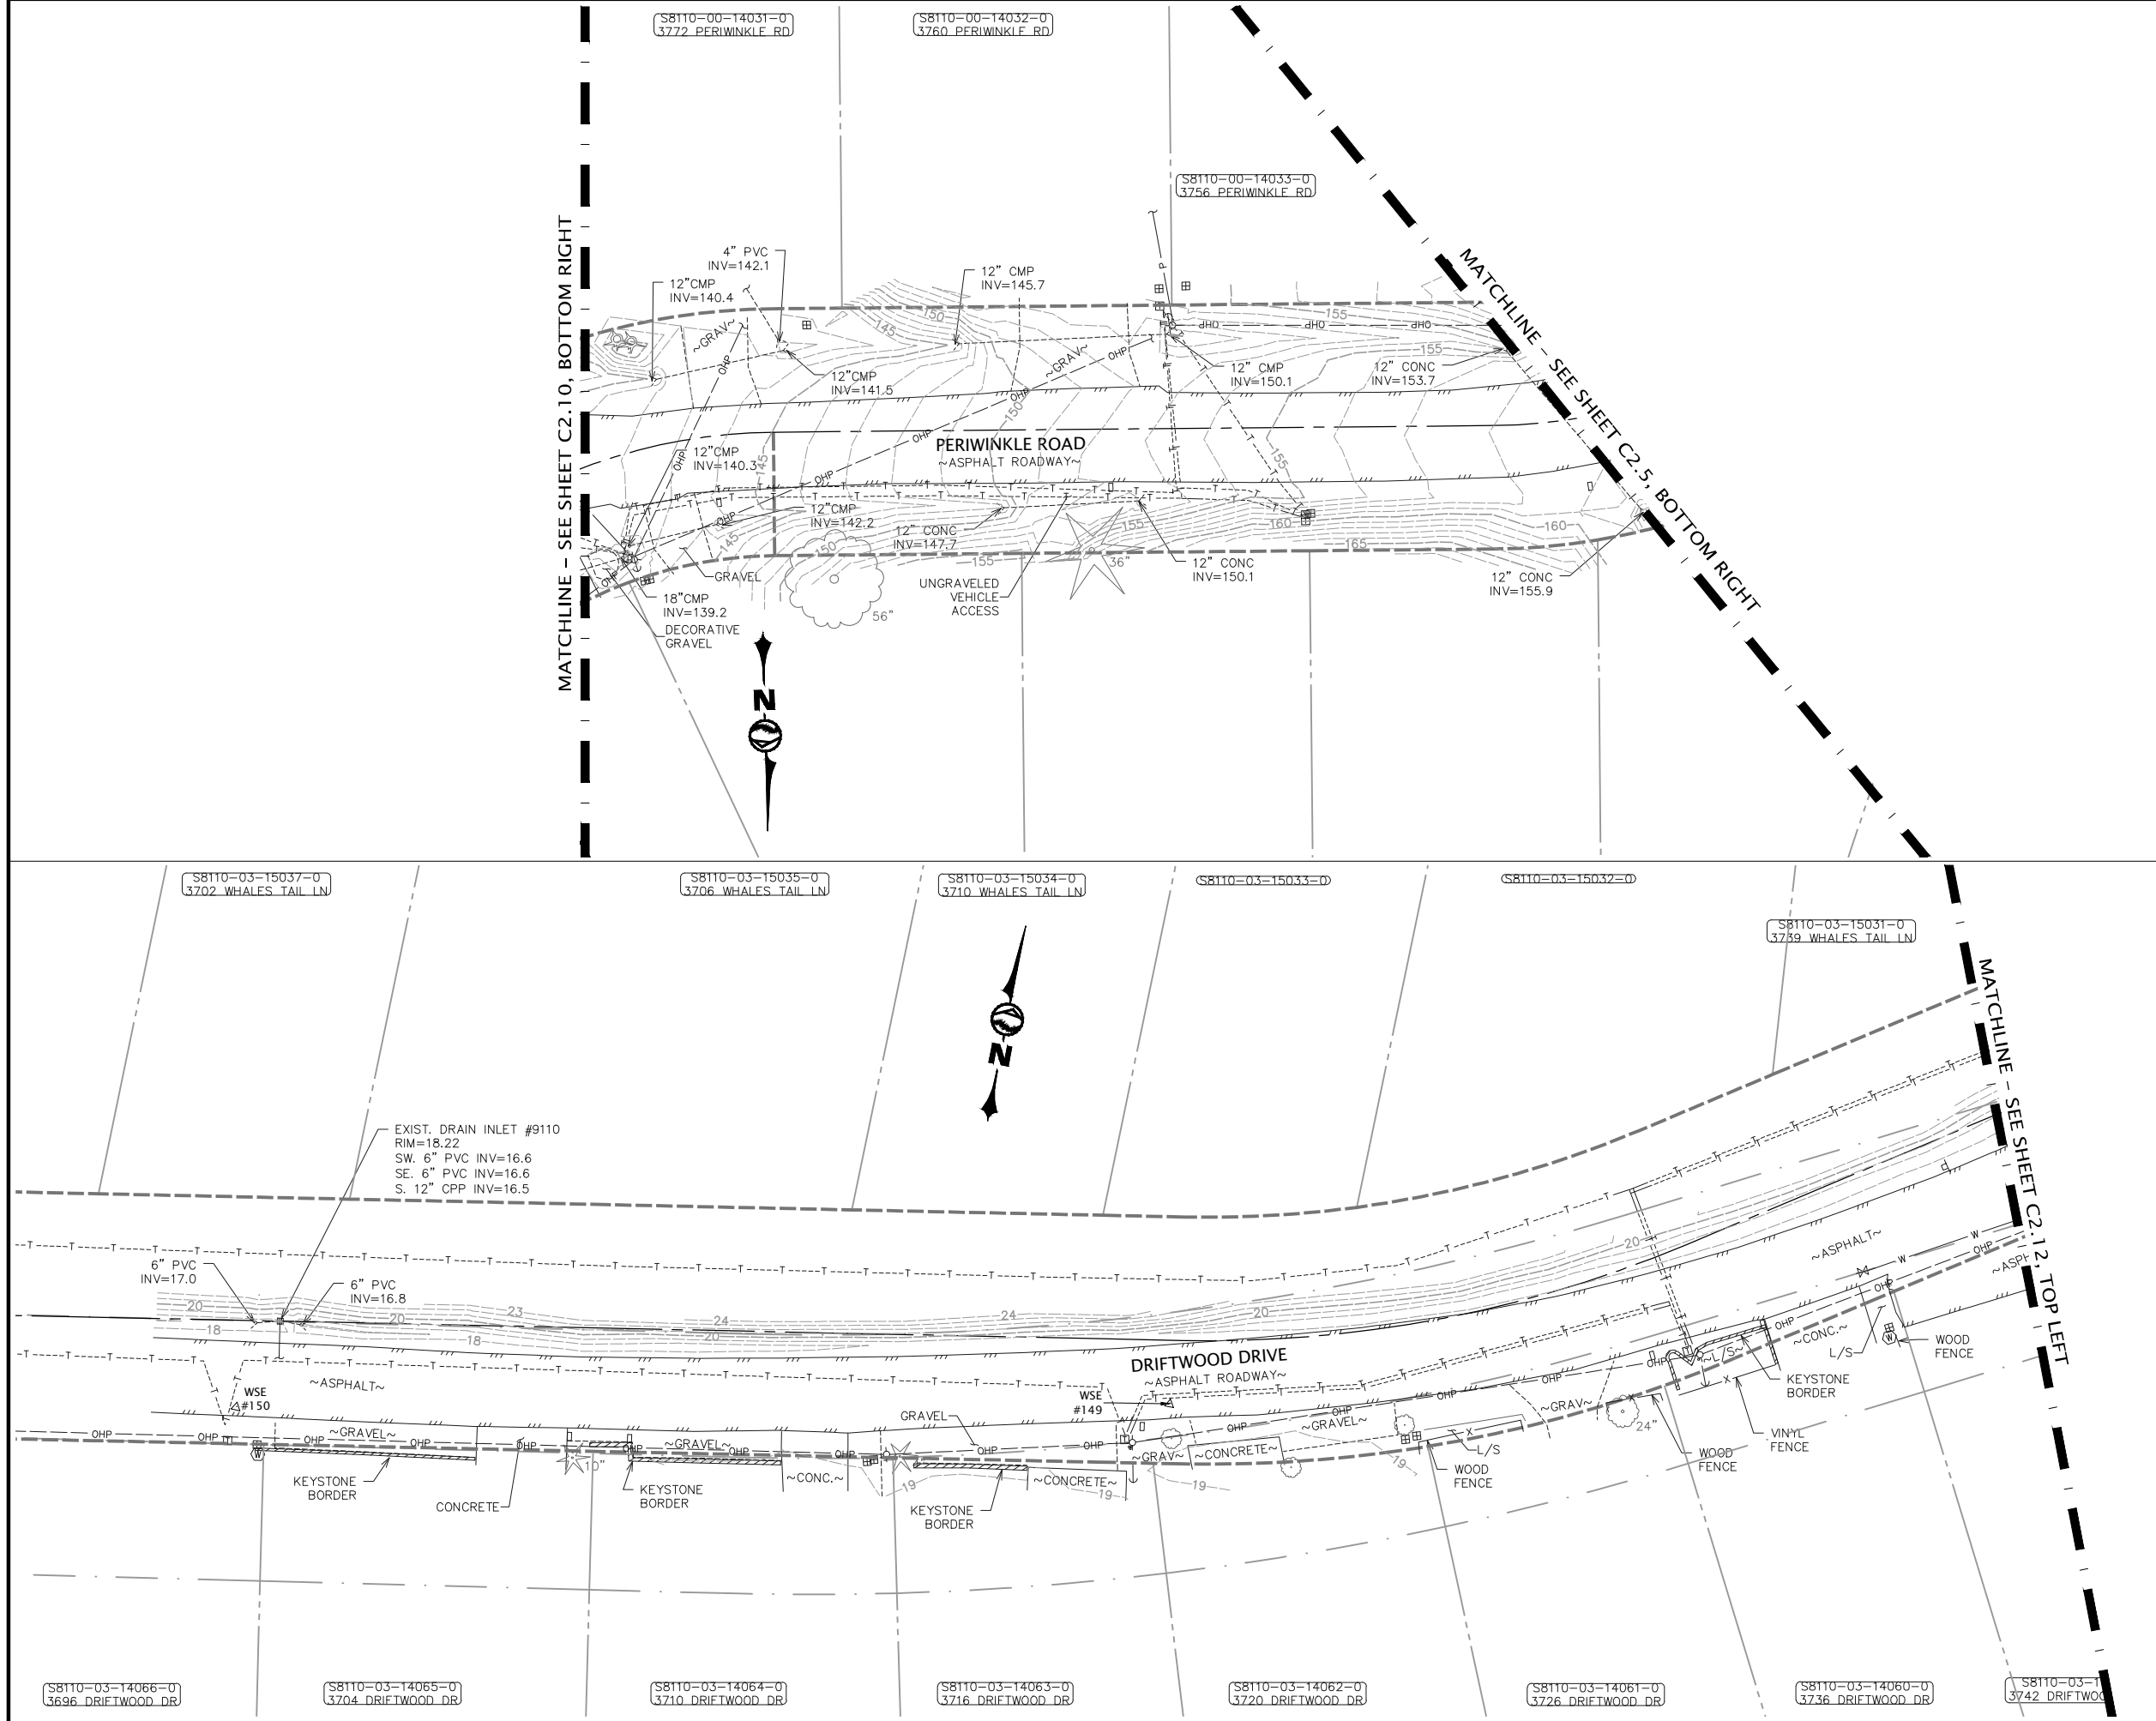

NO.

REVISIONS

BY

DATE

KEY MAP
NOT TO SCALE

LEGEND

20 0 20 40
SCALE HORIZONTAL SCALE FEET

811 Call 811
two business days
before you dig

PRELIMINARY

WASHINGTON

SCATCHET HEAD WATER DISTRICT

DATE
12-8-22

SHEET
C2.11

WHIDBEY ISLAND

WATER SYSTEM IMPROVEMENTS

SCALE
AS SHOWN

PAGE

EXISTING CONDITIONS

JOB NUMBER
2022-013

OF
X


DRAWN BY
CLM/JGS

CHECKED BY
PID

WILSON
ENGINEERING

WILSONENGINEERING.COM

PLOT SETTINGS: AutoCAD PDF (General Documentation).pc3, ANSI full bleed B (17.00 x 11.00 inches), Portrait, 1:2, WE APWA_UNSCREENED.ctb
W:\2022\2022-013 SCATCHET HEAD WD WATER IMPROVEMENTS.MXD V2019_NAD83_NAD88\2022_2022-013 C2.1-C2.13 EXISTING CONDITIONS.DWG - 12/8/2022 1:55 PM - Jeff Smith

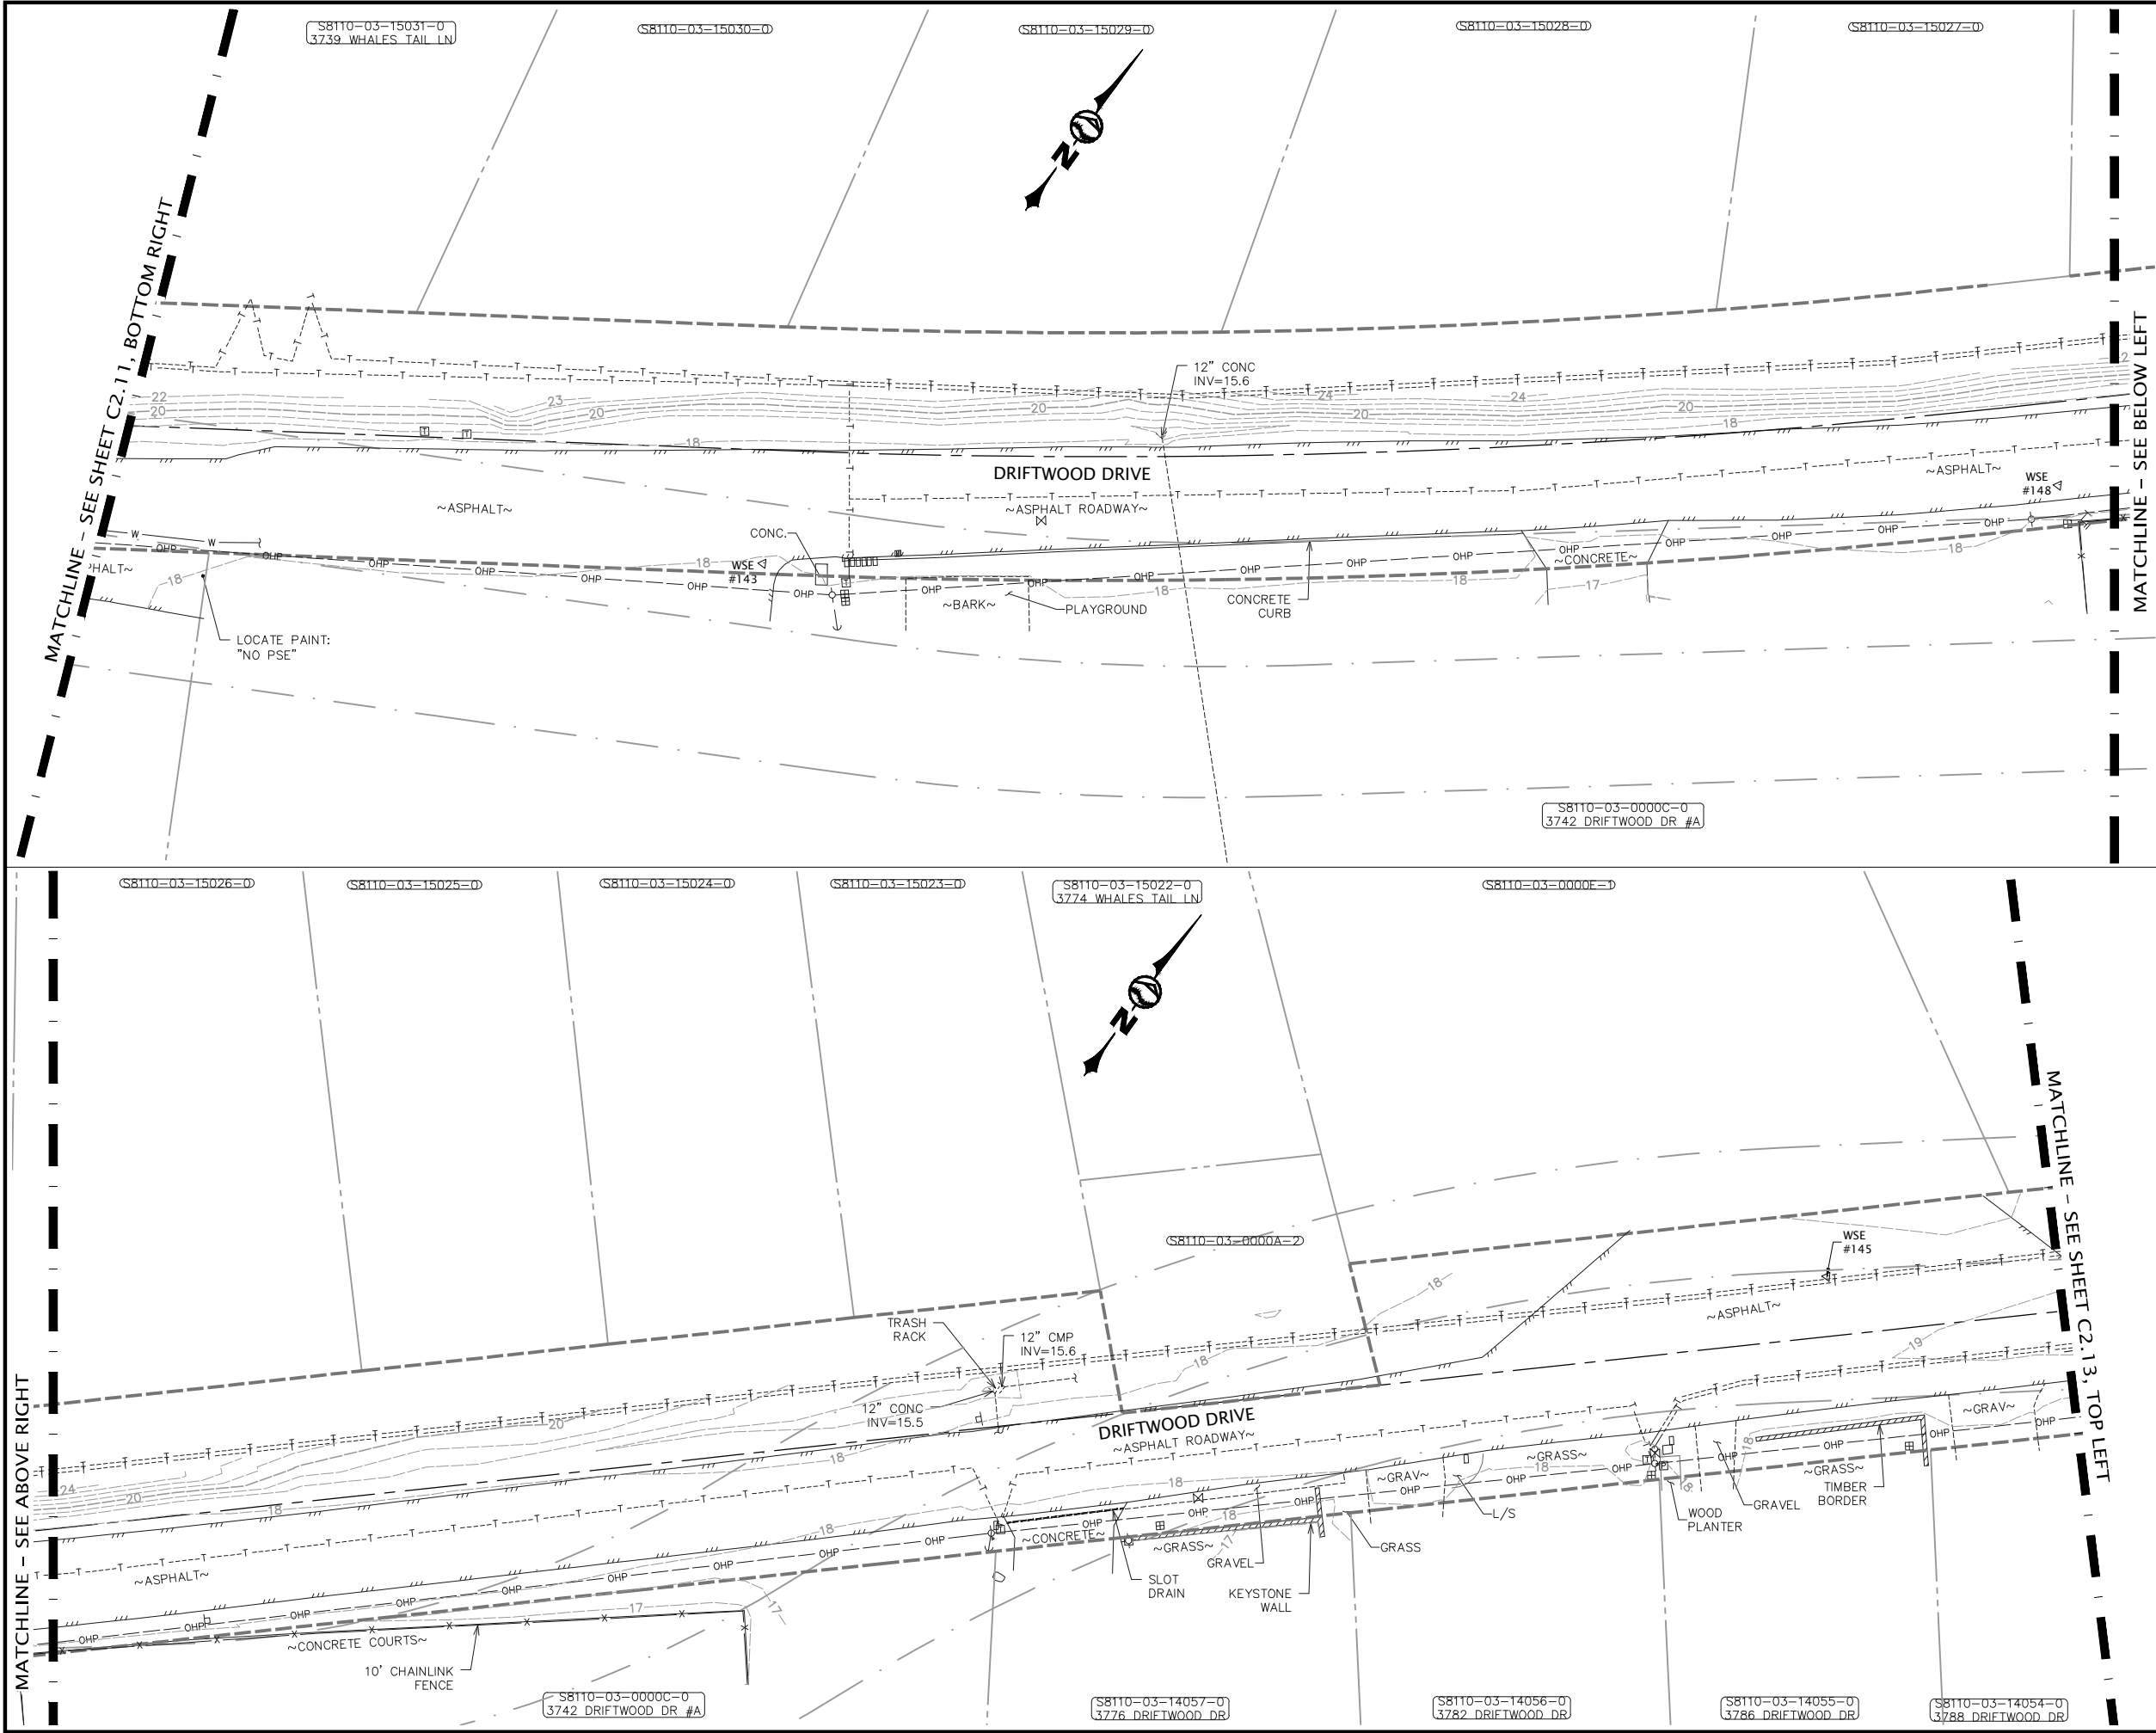

NO.

REVISIONS

BY

DATE

KEY MAP
NOT TO SCALE

LEGEND

= TOP VIEW,
THIS SHEET

= BOTTOM VIEW,
THIS SHEET

20

0

20

40

SCALE

HORIZONTAL SCALE

FEET

811

Call 811

two business days
before you dig

PRELIMINARY

WILSON
ENGINEERING

WILSONENGINEERING.COM

PRELIMINARY

PLANNING & DESIGN
WASHINGTON
PROFESSIONAL LAND

DRAWN BY
CLM/JGS

CHECKED BY
PID

SCATCHET HEAD WATER DISTRICT

WATER SYSTEM IMPROVEMENTS

EXISTING CONDITIONS

SHEET
C2.12

DATE
12-8-22


SCALE
AS SHOWN

JOB NUMBER
2022-013

PAGE
X

OF
X

PLOT SETTINGS: AutoCAD PDF (General Documentation).pc3, ANSI full bleed B (17.00 x 11.00 inches), Portrait, 1:2, WE APWA_UNSCREENED.ctb
W:\2022\2022-013 SCATCHET HEAD WD WATER IMPROVEMENTS.MXD\DWG_V2019_NAD83_NAVD88\2022_2022-013 C2.1-C2.13 EXISTING CONDITIONS.DWG - 12/8/2022 1:56 PM - Jeff Smith

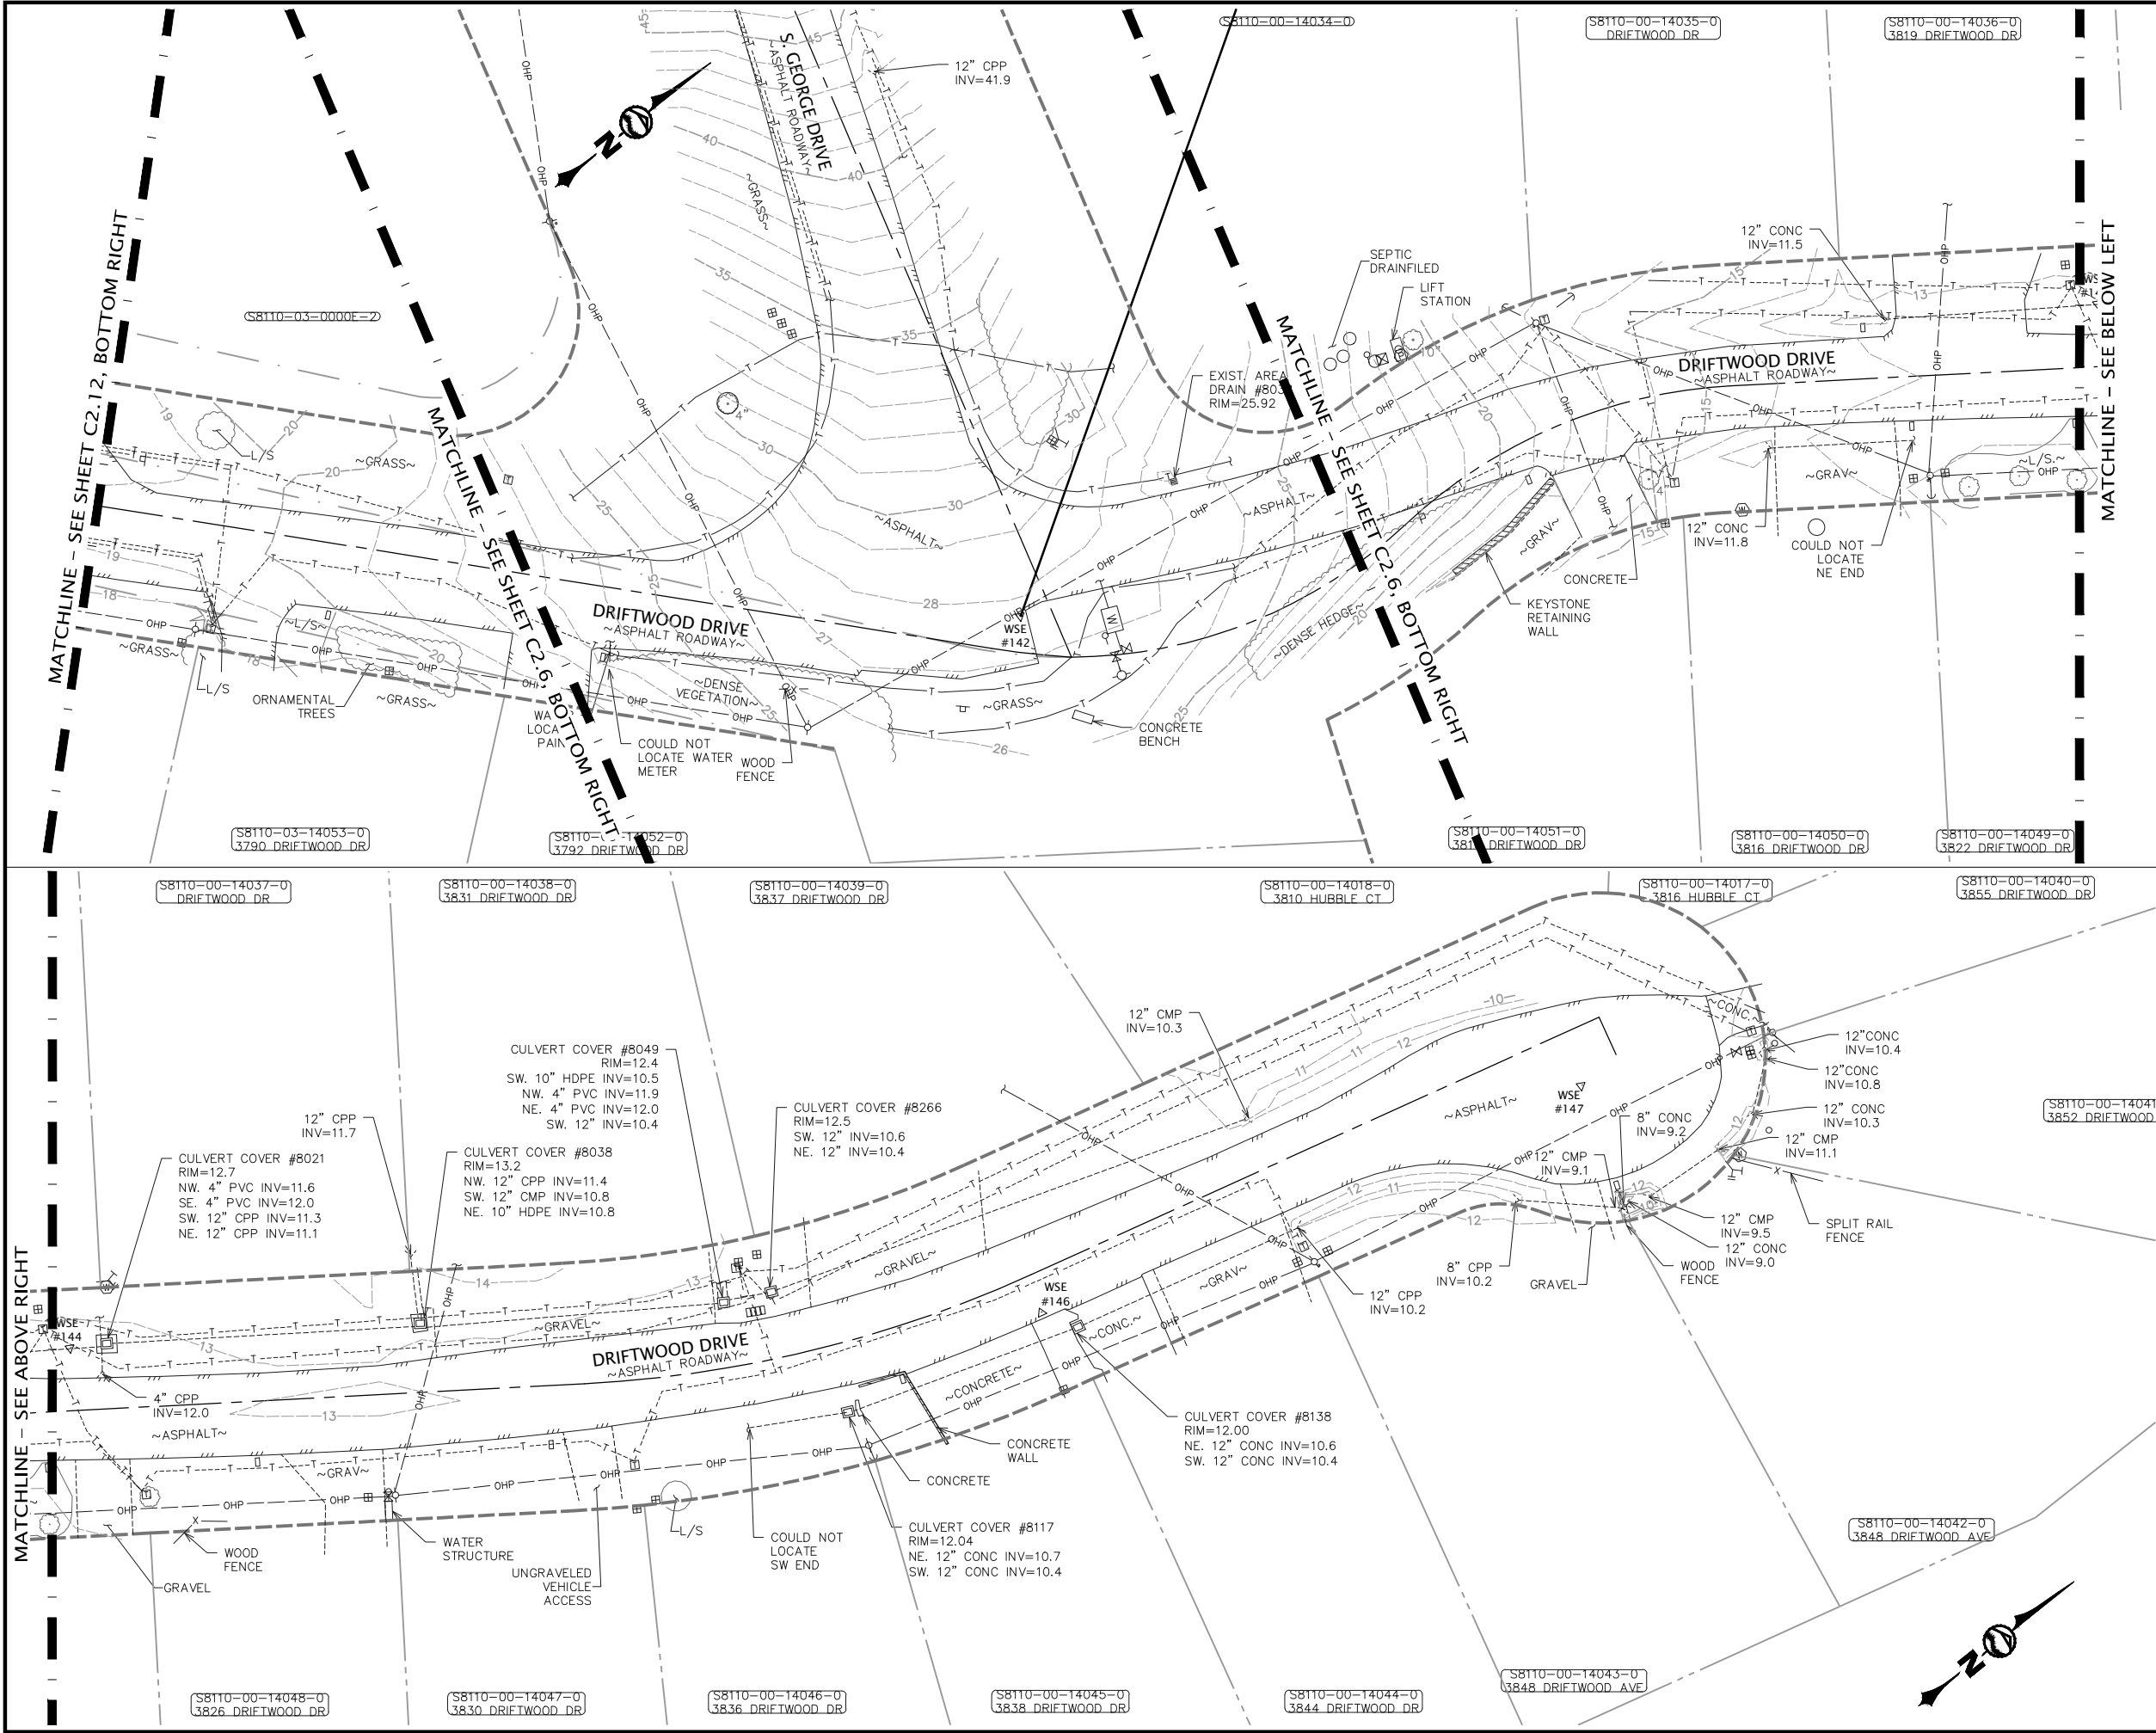

NO.		REVISIONS		BY	DATE

KEY MAP
NOT TO SCALE

LEGEND
[Pattern] = TOP VIEW, THIS SHEET
[Pattern] = BOTTOM VIEW, THIS SHEET


20 0 20 40
SCALE HORIZONTAL SCALE FEET

811 Call 811
two business days before you dig

PRELIMINARY

SCATCHET HEAD WATER DISTRICT		WASHINGTON		WATER SYSTEM IMPROVEMENTS		EXISTING CONDITIONS	
DATE 12-8-22		SCALE AS SHOWN		JOB NUMBER 2022-013		PAGE X OF X	
SHEET C2.13		DRAWN BY CLM/JGS		CHECKED BY PID		WILSON ENGINEERING WILSONENGINEERING.COM	

PLOT SETTINGS: AutoCAD PDF (General Documentation).pc3, ANSI full bleed B (17.00 x 11.00 inches), Portrait, 1:2, WE APWA_UNSCREENED.ctb
W:\2022-2022-013 SCATCHET HEAD WD WATER IMPROVEMENTS.MMM\DWG_V2019_NAD83_NAD88\2022_2022-013 C4.1-C4.5 BLAKELY PLAN & PROFILES.DWG - 12/8/2022 1:56 PM - Jeff Smith

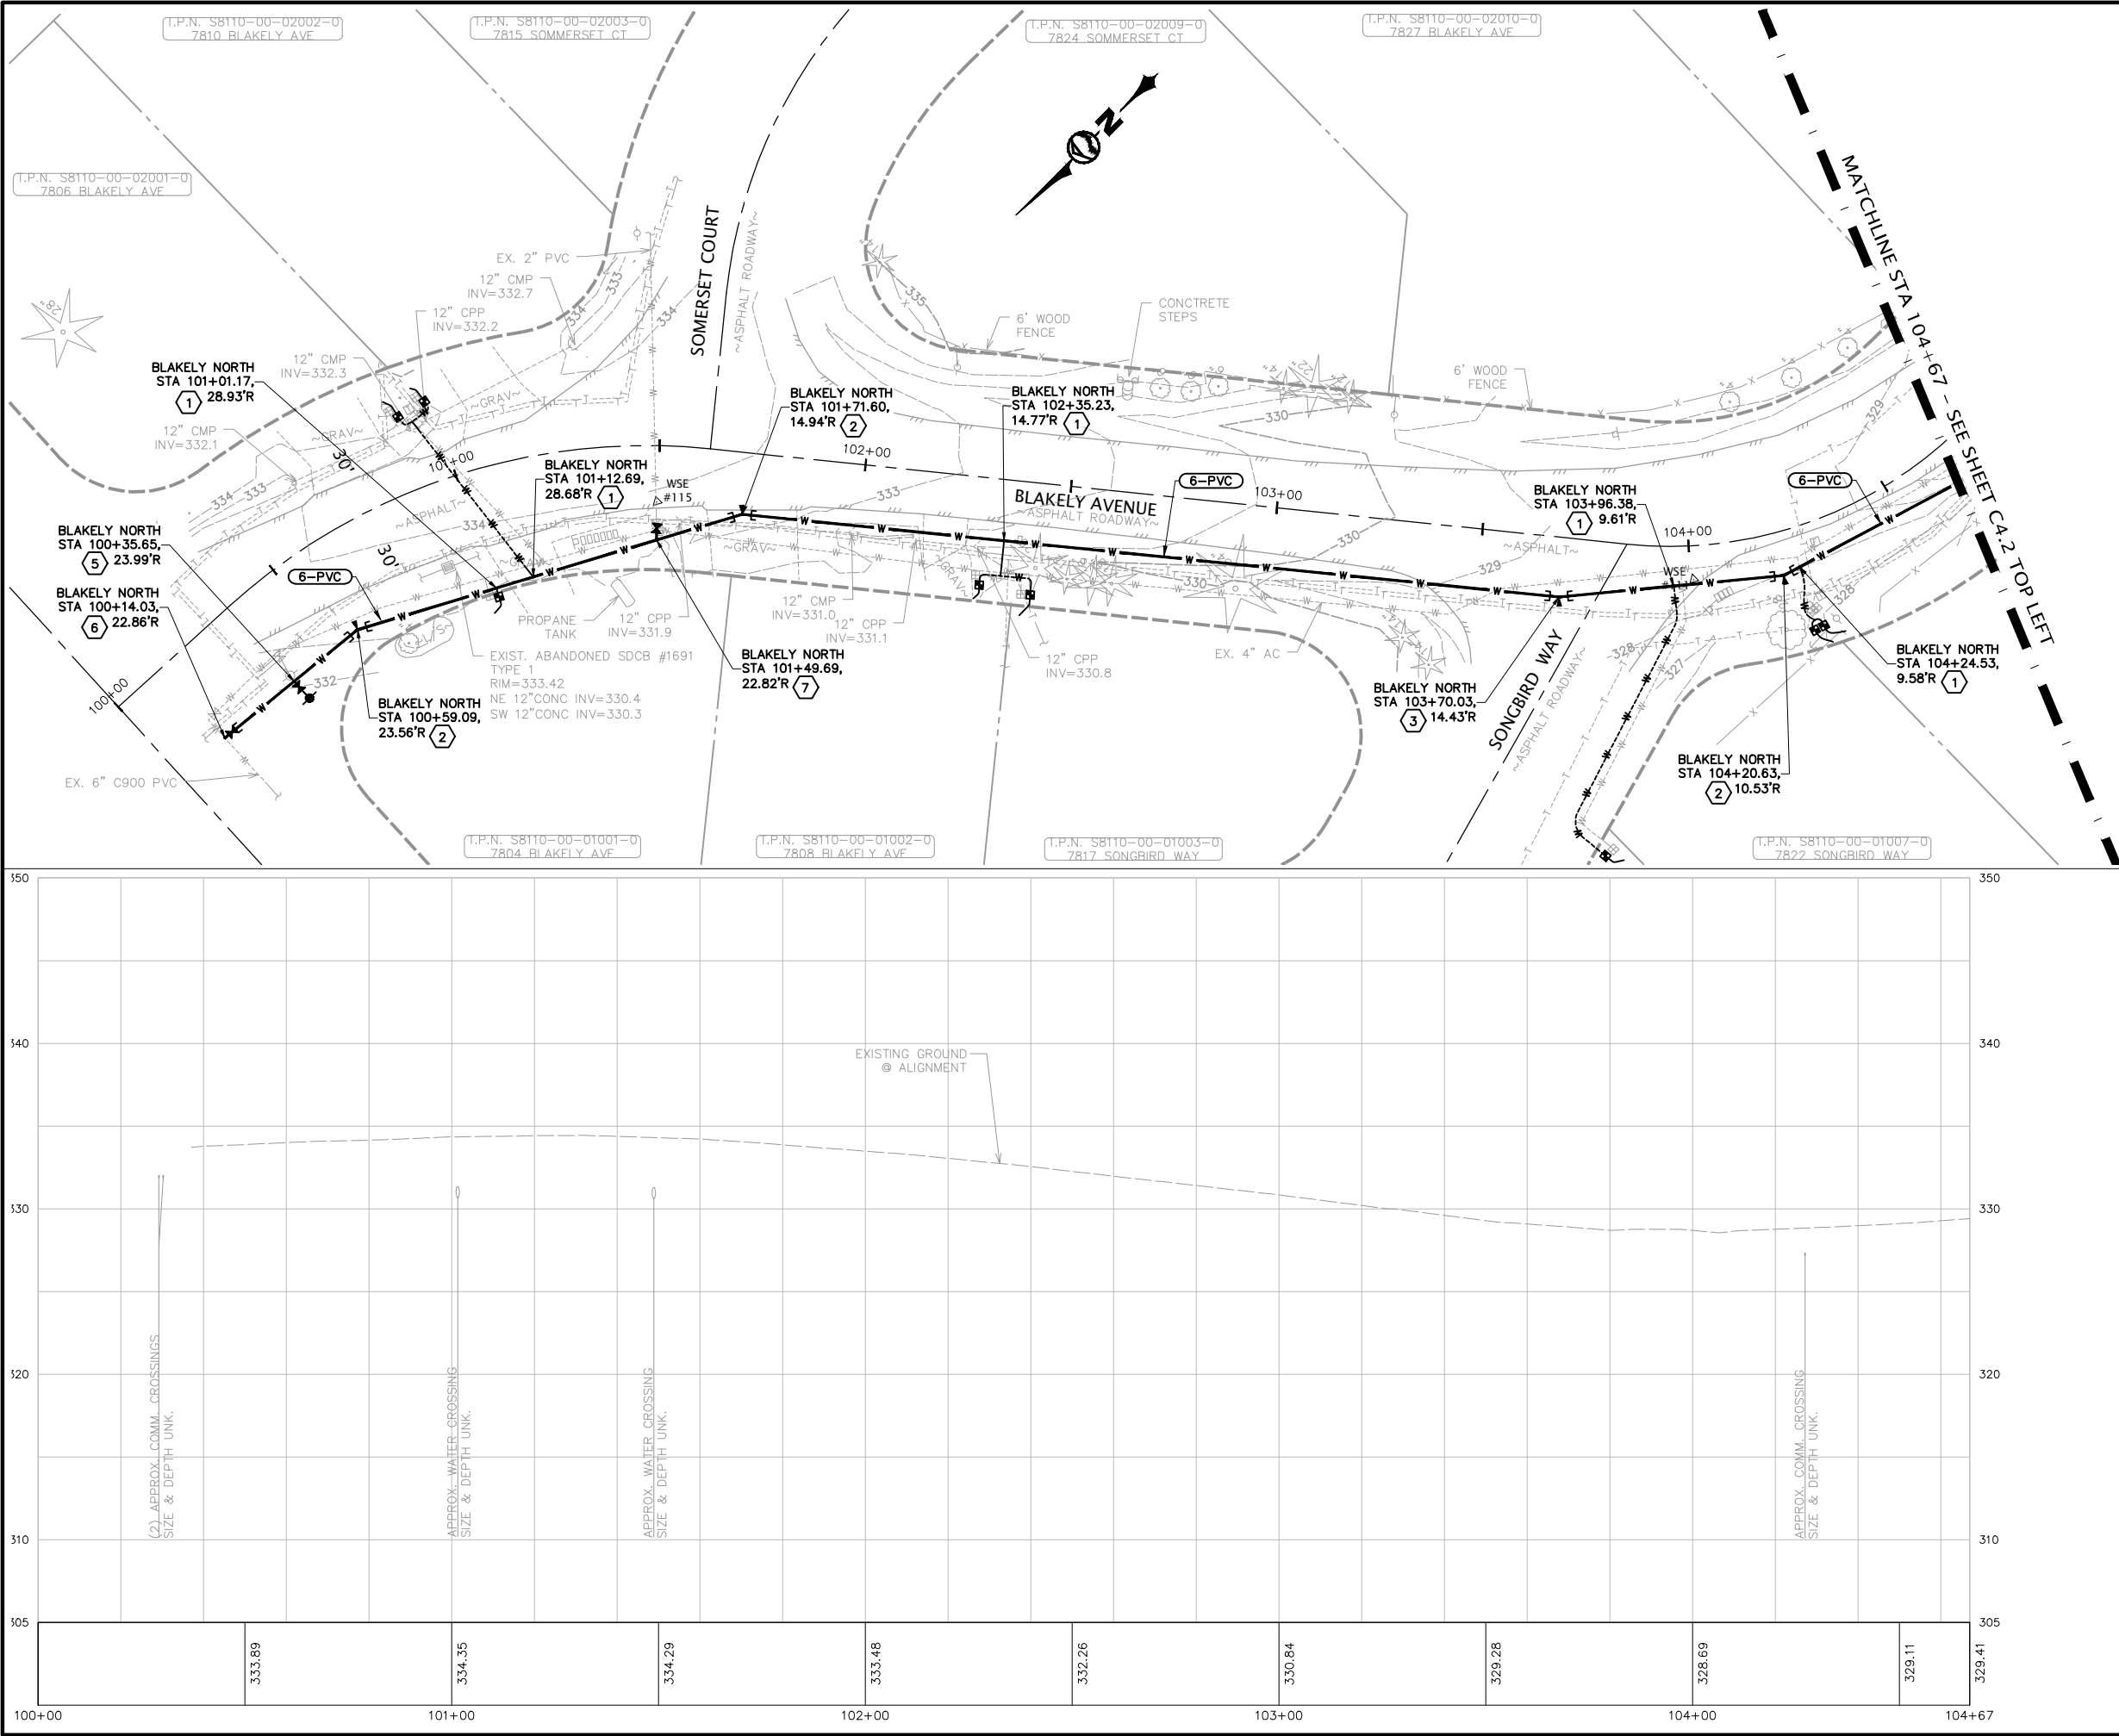

NO.	REVISIONS	BY	DATE

KEYED NOTES

- 1 = SERVICE CONNECTION PER $\frac{X}{X}$
- 2 = 6" 22-1/2" BEND MxMJ, THRUST BLOCKING
- 3 = 6" 11-1/4" BEND MxMJ, THRUST BLOCKING
- 4 = **INTENTIONALLY BLANK**
- 5 = HYDRANT ASS'Y PER $\frac{X}{X}$
- 6 = HOT TAP CONNECTION TO EXISTING 6" PVC. (1) 6" GV
- 7 = CONNECT TO EX. 2" GV

KEY MAP NOT TO SCALE

LEGEND

- PLAN VIEW, THIS SHEET

SCALE

20 0 20 40
SCALE HORIZONTAL SCALE FEET

811 Call 811
two business days before you dig

PRELIMINARY

WILSON ENGINEERING

WILSONENGINEERING.COM

PRELIMINARY

DESIGNED BY CDS/MKW
DRAWN BY JGS
CHECKED BY MMM

SCATCHET HEAD WATER DISTRICT

WASHINGTON

WATER SYSTEM IMPROVEMENTS



WHIDBEY ISLAND

BLAKELY AVENUE NORTH - STA 100+00 TO STA 104+67

DATE 12-8-22	SCALE AS SHOWN	JOB NUMBER 2022-013
-----------------	-------------------	------------------------

SHEET C4.1	PAGE X OF X
----------------------	----------------

PLOT SETTINGS: AutoCAD PDF (General Documentation).pc3, ANSI full bleed B (17.00 x 11.00 inches), Portrait, 1:2, WE APWA_UNSCREENED.ctb
W:\2022\2022-013 SCATCHET HEAD WD WATER IMPROVEMENTS.MMM\DWG_V2019_NAD83_NAD88\2022_2022-013 C4.1-C4.5 BLAKELY PLAN & PROFILES.DWG - 12/8/2022 1:57 PM - Jeff Smith

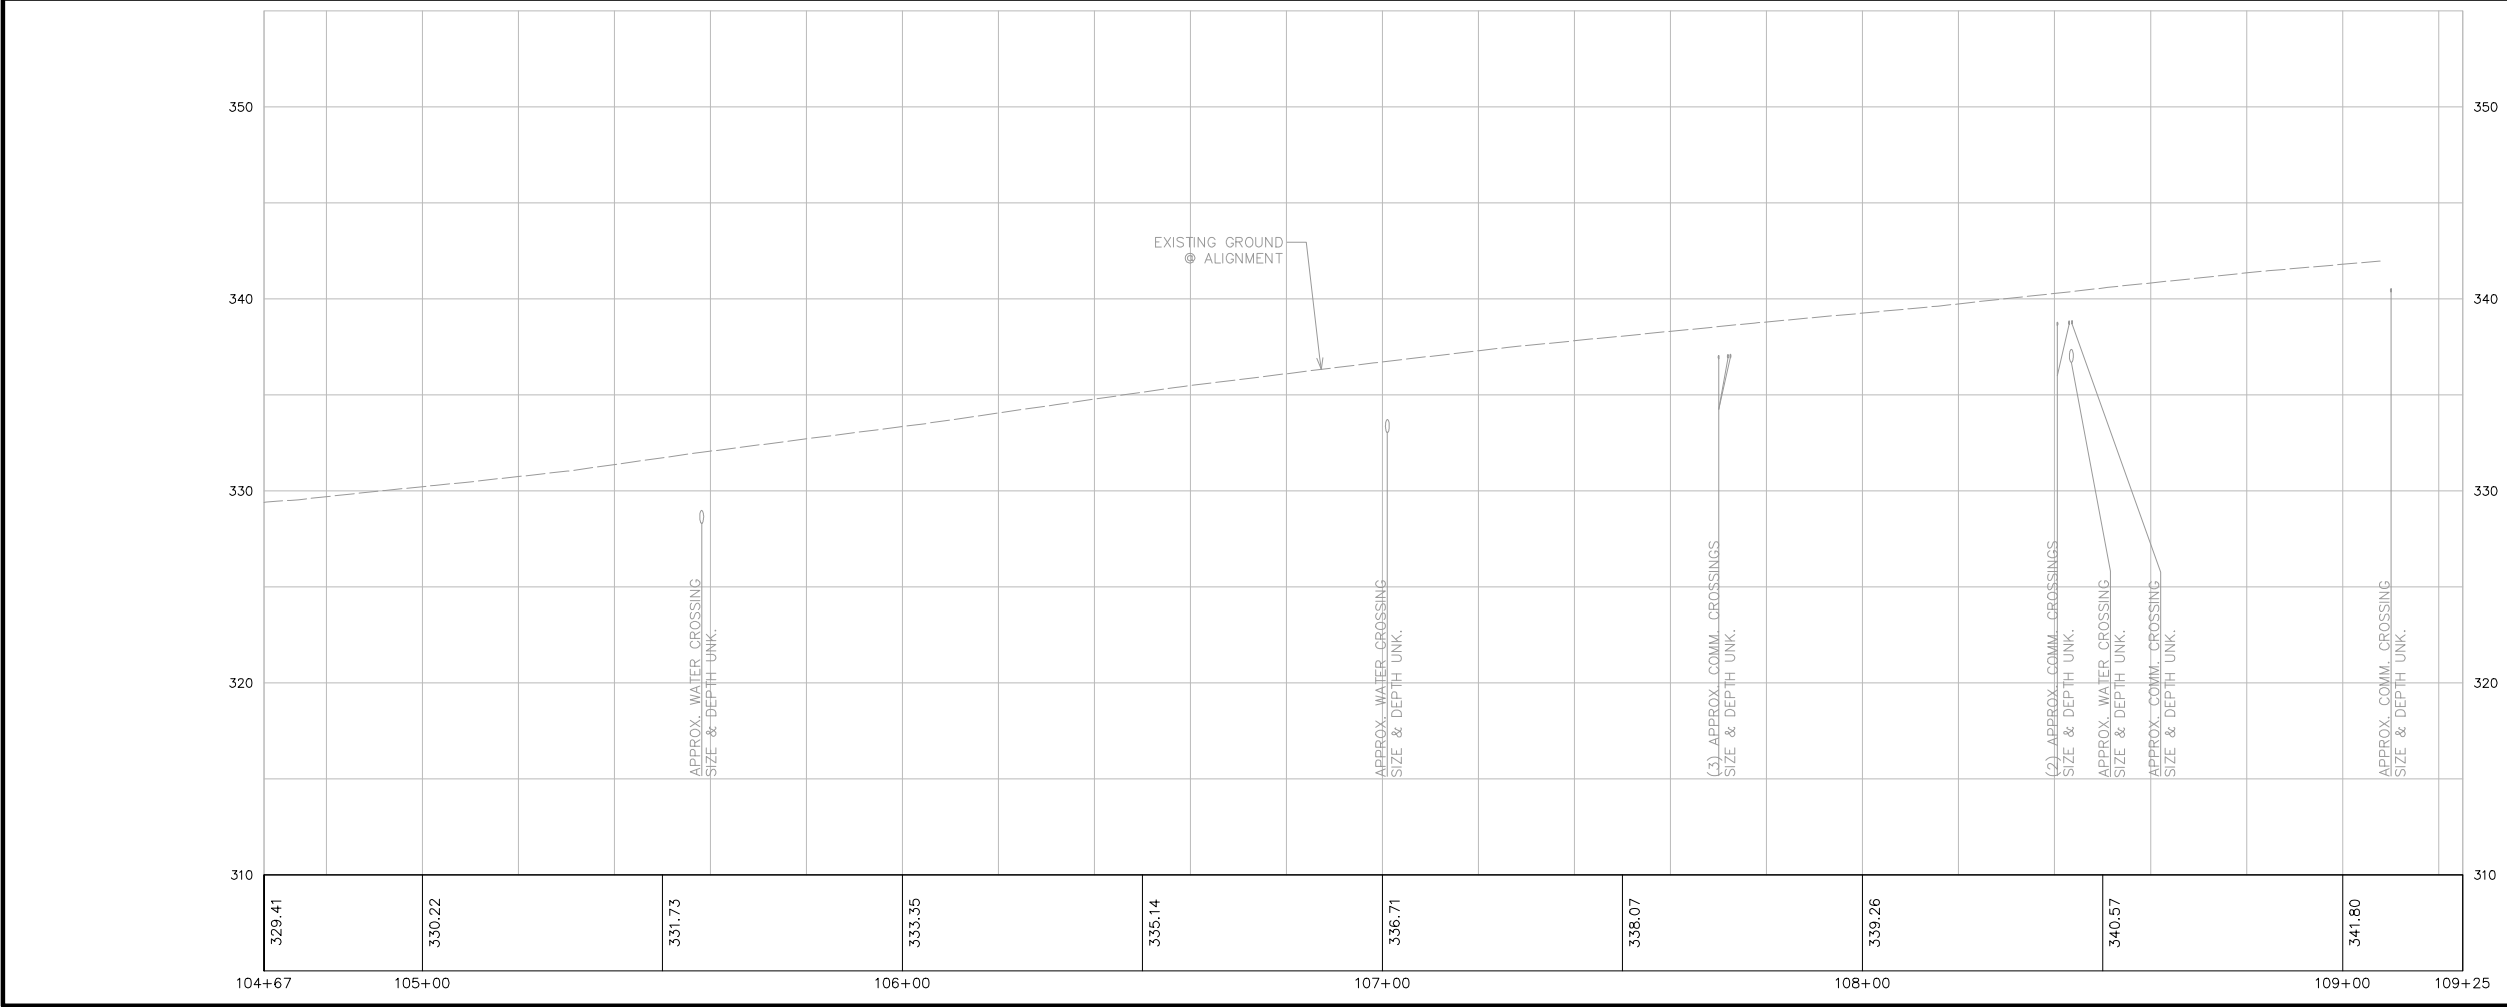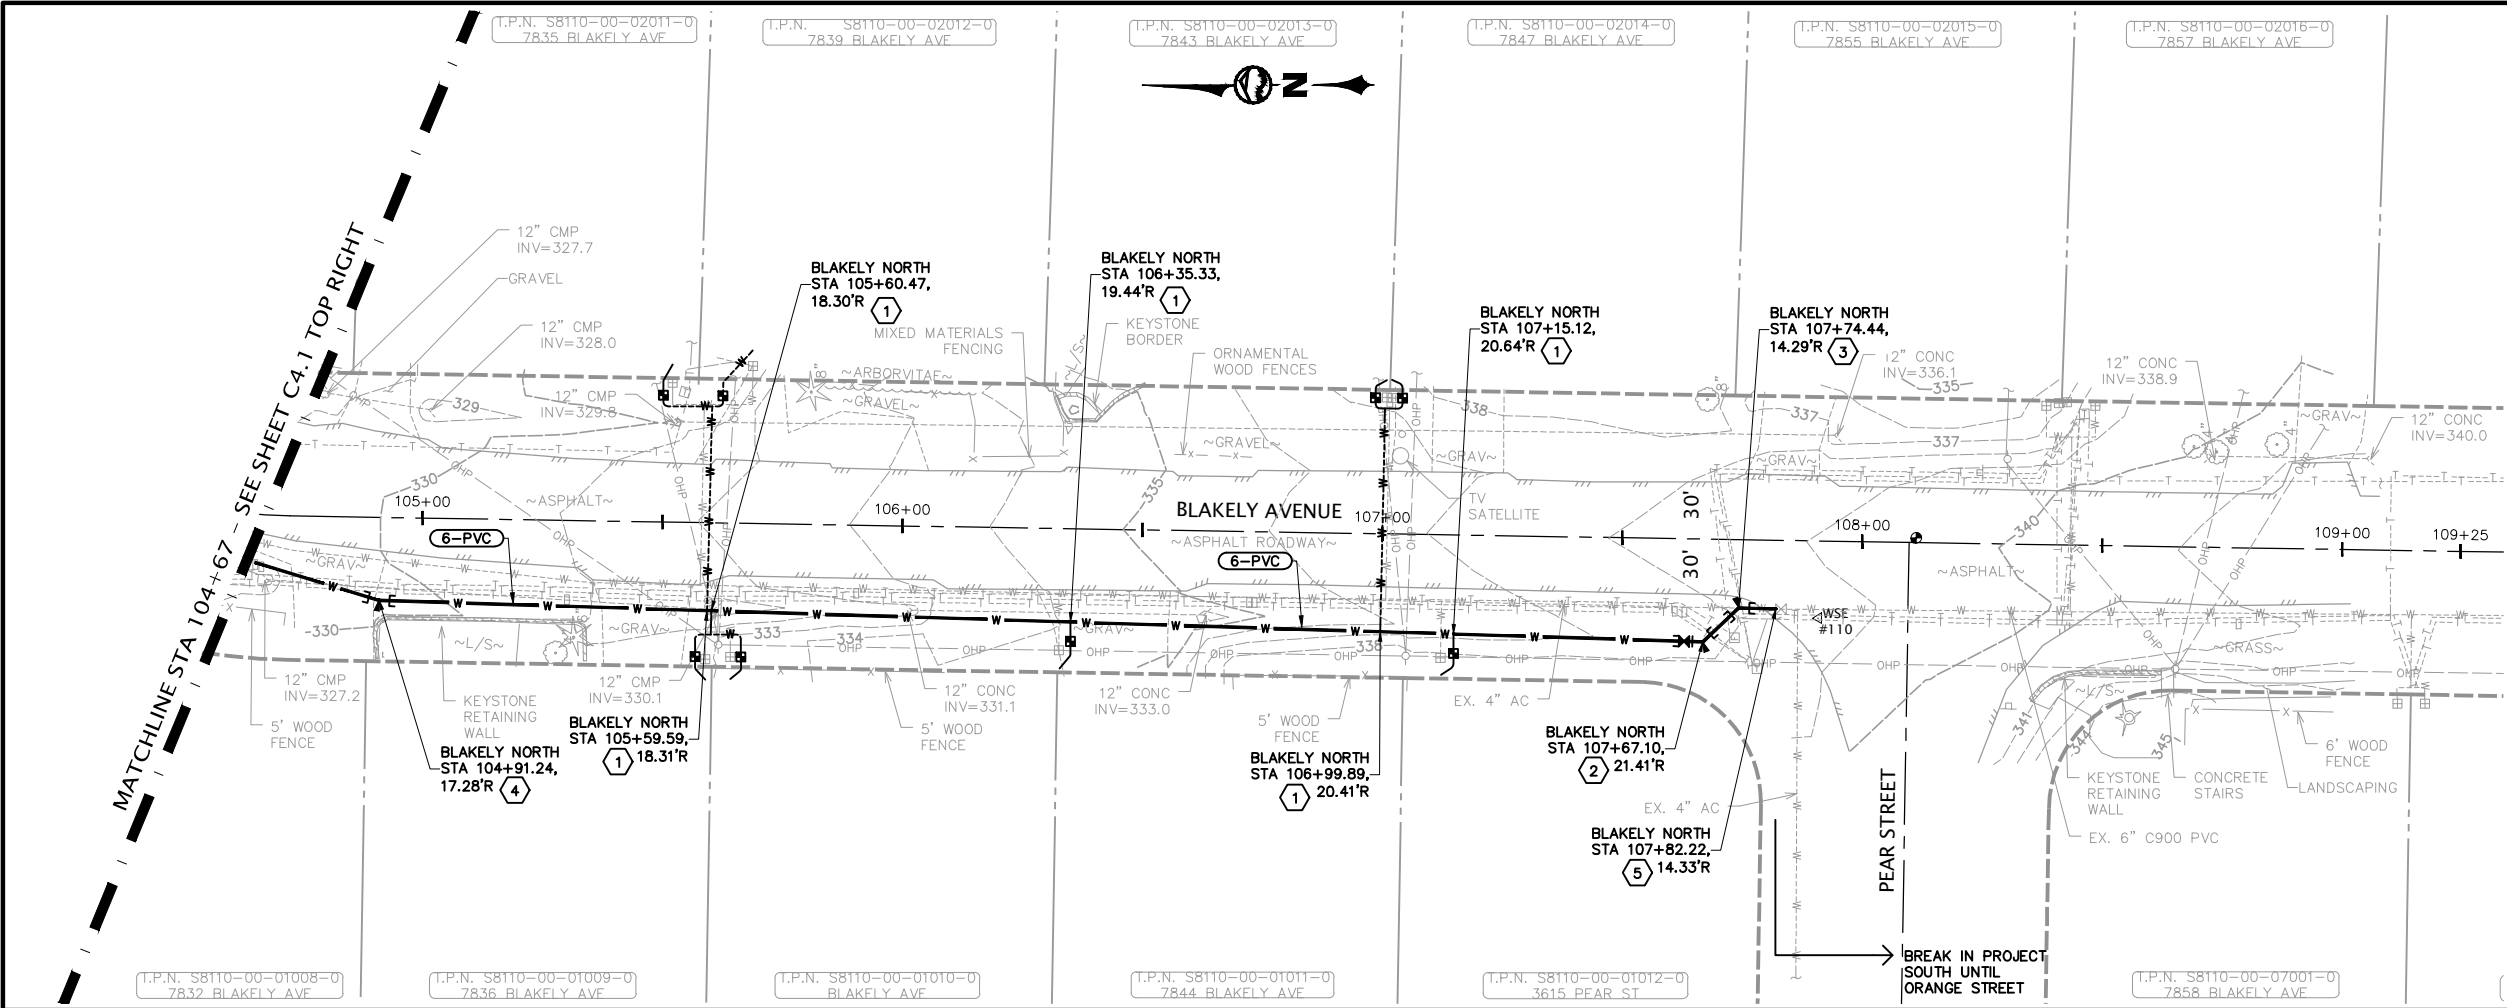

NO.		REVISIONS		BY	DATE
KEYED NOTES					
1	= SERVICE CONNECTION PER $\frac{X}{X}$				
2	= 6" 45° BEND FLxMJ, 6" GV FLxMJ THRUST BLOCKING				
3	= 6" 45° BEND MJxMJ, THRUST BLOCKING				
4	= 6" 11-1/4° BEND MJxMJ, THRUST BLOCKING				
5	= CONNECT TO EX. GV				

KEY MAP NOT TO SCALE

LEGEND
= PLAN VIEW, THIS SHEET

20 0 20 40
SCALE HORIZONTAL SCALE FEET

811 Call 811
two business days
before you dig

PRELIMINARY

DESIGNED BY		DRAWN BY		CHECKED BY	
CDS/MKW		JGS		MMM	

SCATCHET HEAD WATER DISTRICT		WASHINGTON	
WATER SYSTEM IMPROVEMENTS <td colspan="2">BLAKELY AVENUE NORTH - STA 104+67 TO STA 109+25</td>		BLAKELY AVENUE NORTH - STA 104+67 TO STA 109+25	

SHEET	DATE	SCALE	JOB NUMBER
C4.2	12-8-22	AS SHOWN	2022-013

PAGE	OF
X	X

WILSON
ENGINEERING

WILSONENGINEERING.COM

PRELIMINARY



DESIGNED BY	DRAWN BY	CHECKED BY
CDS/MKW	JGS	MMM

SCATCHET HEAD WATER DISTRICT		WASHINGTON	
WATER SYSTEM IMPROVEMENTS		BLAKELY AVENUE NORTH - STA 104+67 TO STA 109+25	


SHEET	DATE	SCALE	JOB NUMBER
C4.2	12-8-22	AS SHOWN	2022-013

PAGE	OF
X	X

PLOT SETTINGS: AutoCAD PDF (General Documentation).pc3, ANSI full bleed B (17.00 x 11.00 inches), Portrait, 1:2, WE APWA_UNSCREENED.ctb
W:\2022\2022-013 SCATCHET HEAD WD WATER IMPROVEMENTS.MMM\DWG_V2019_NAD83_NAD88\2022_2022-013 C4.1-C4.5 BLAKELY PLAN & PROFILES.DWG - 12/8/2022 1:57 PM - Jeff Smith

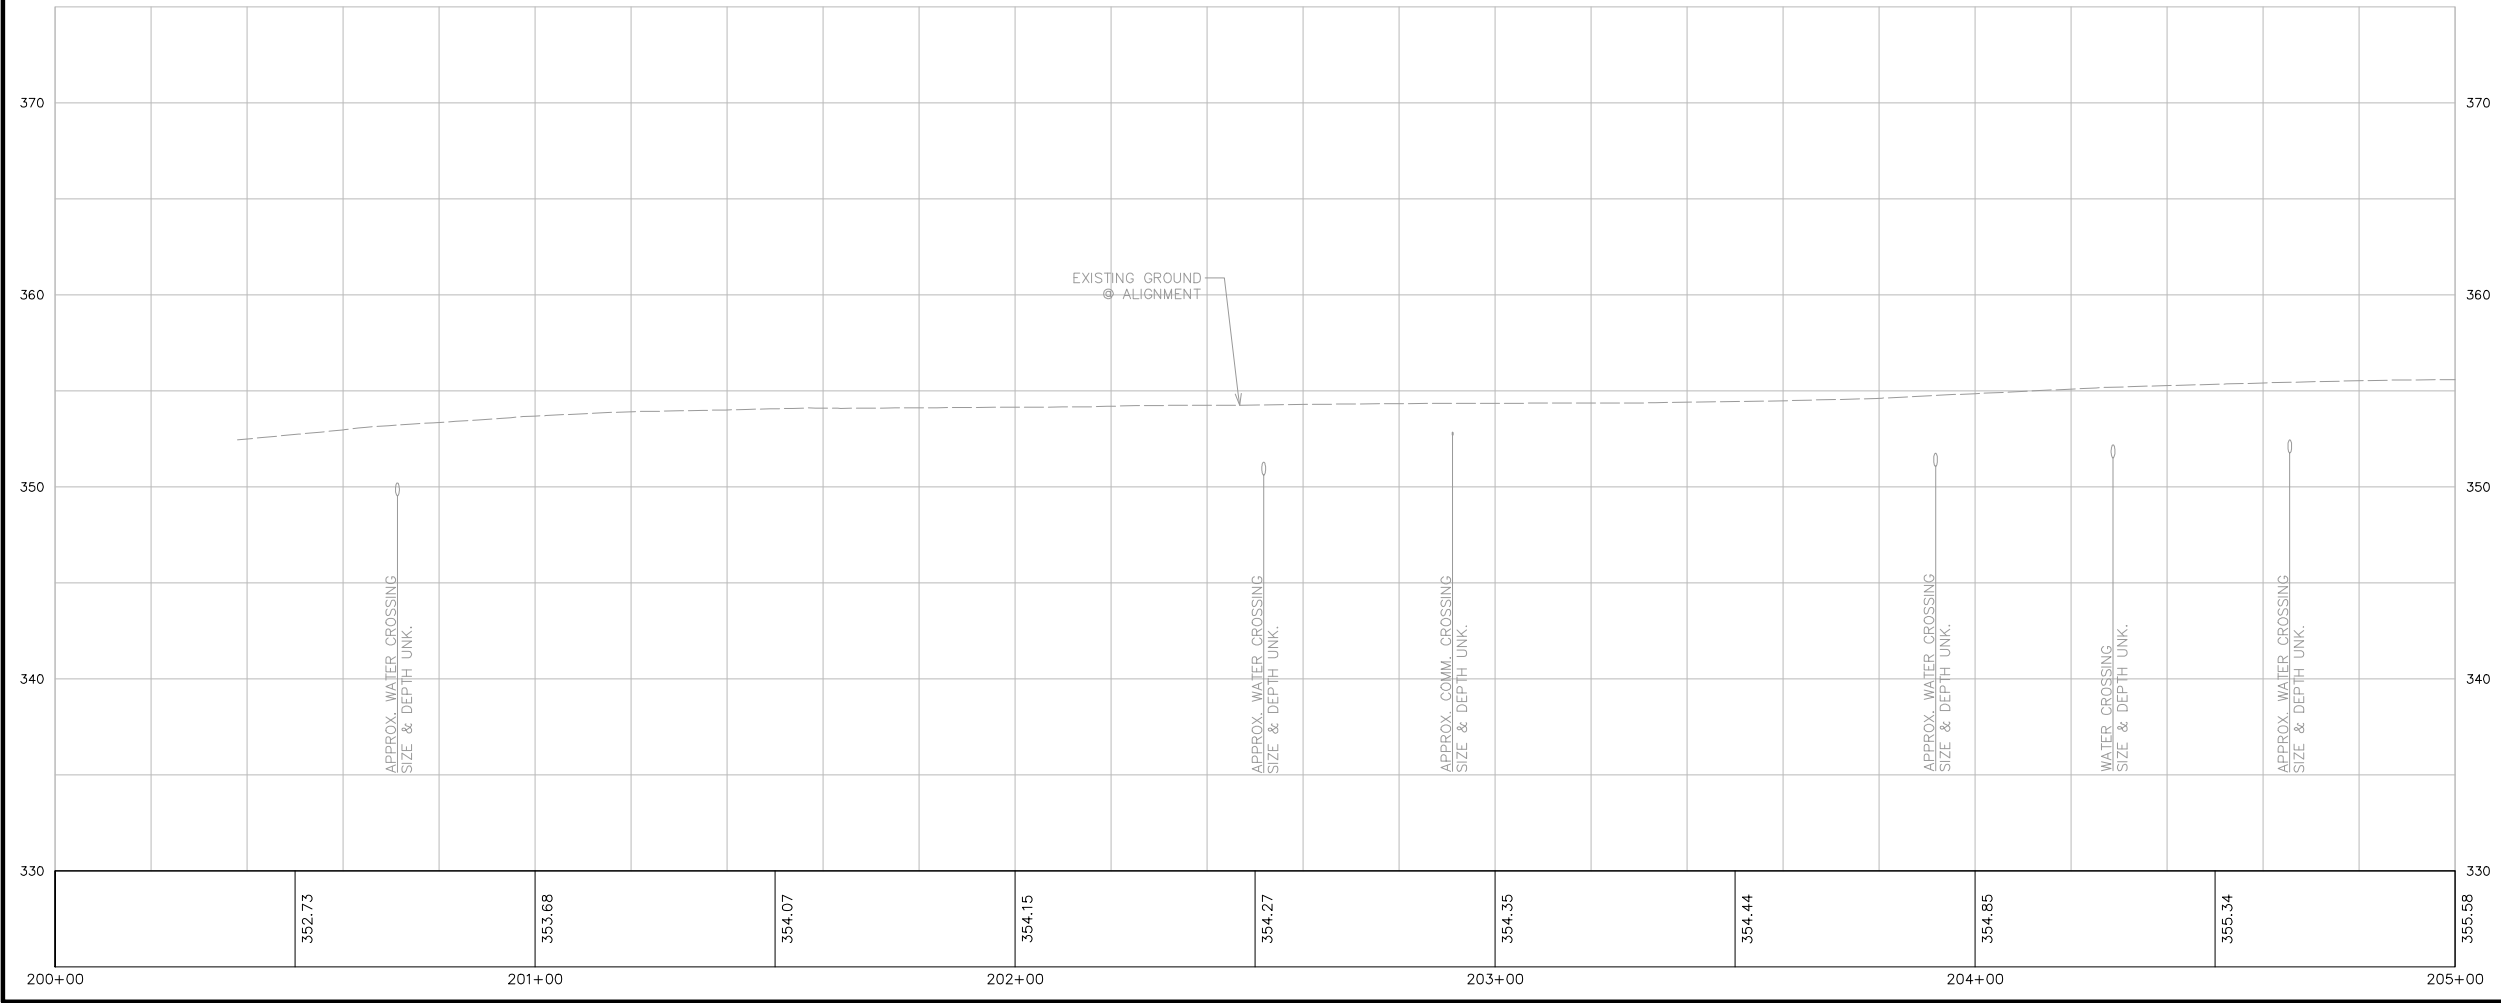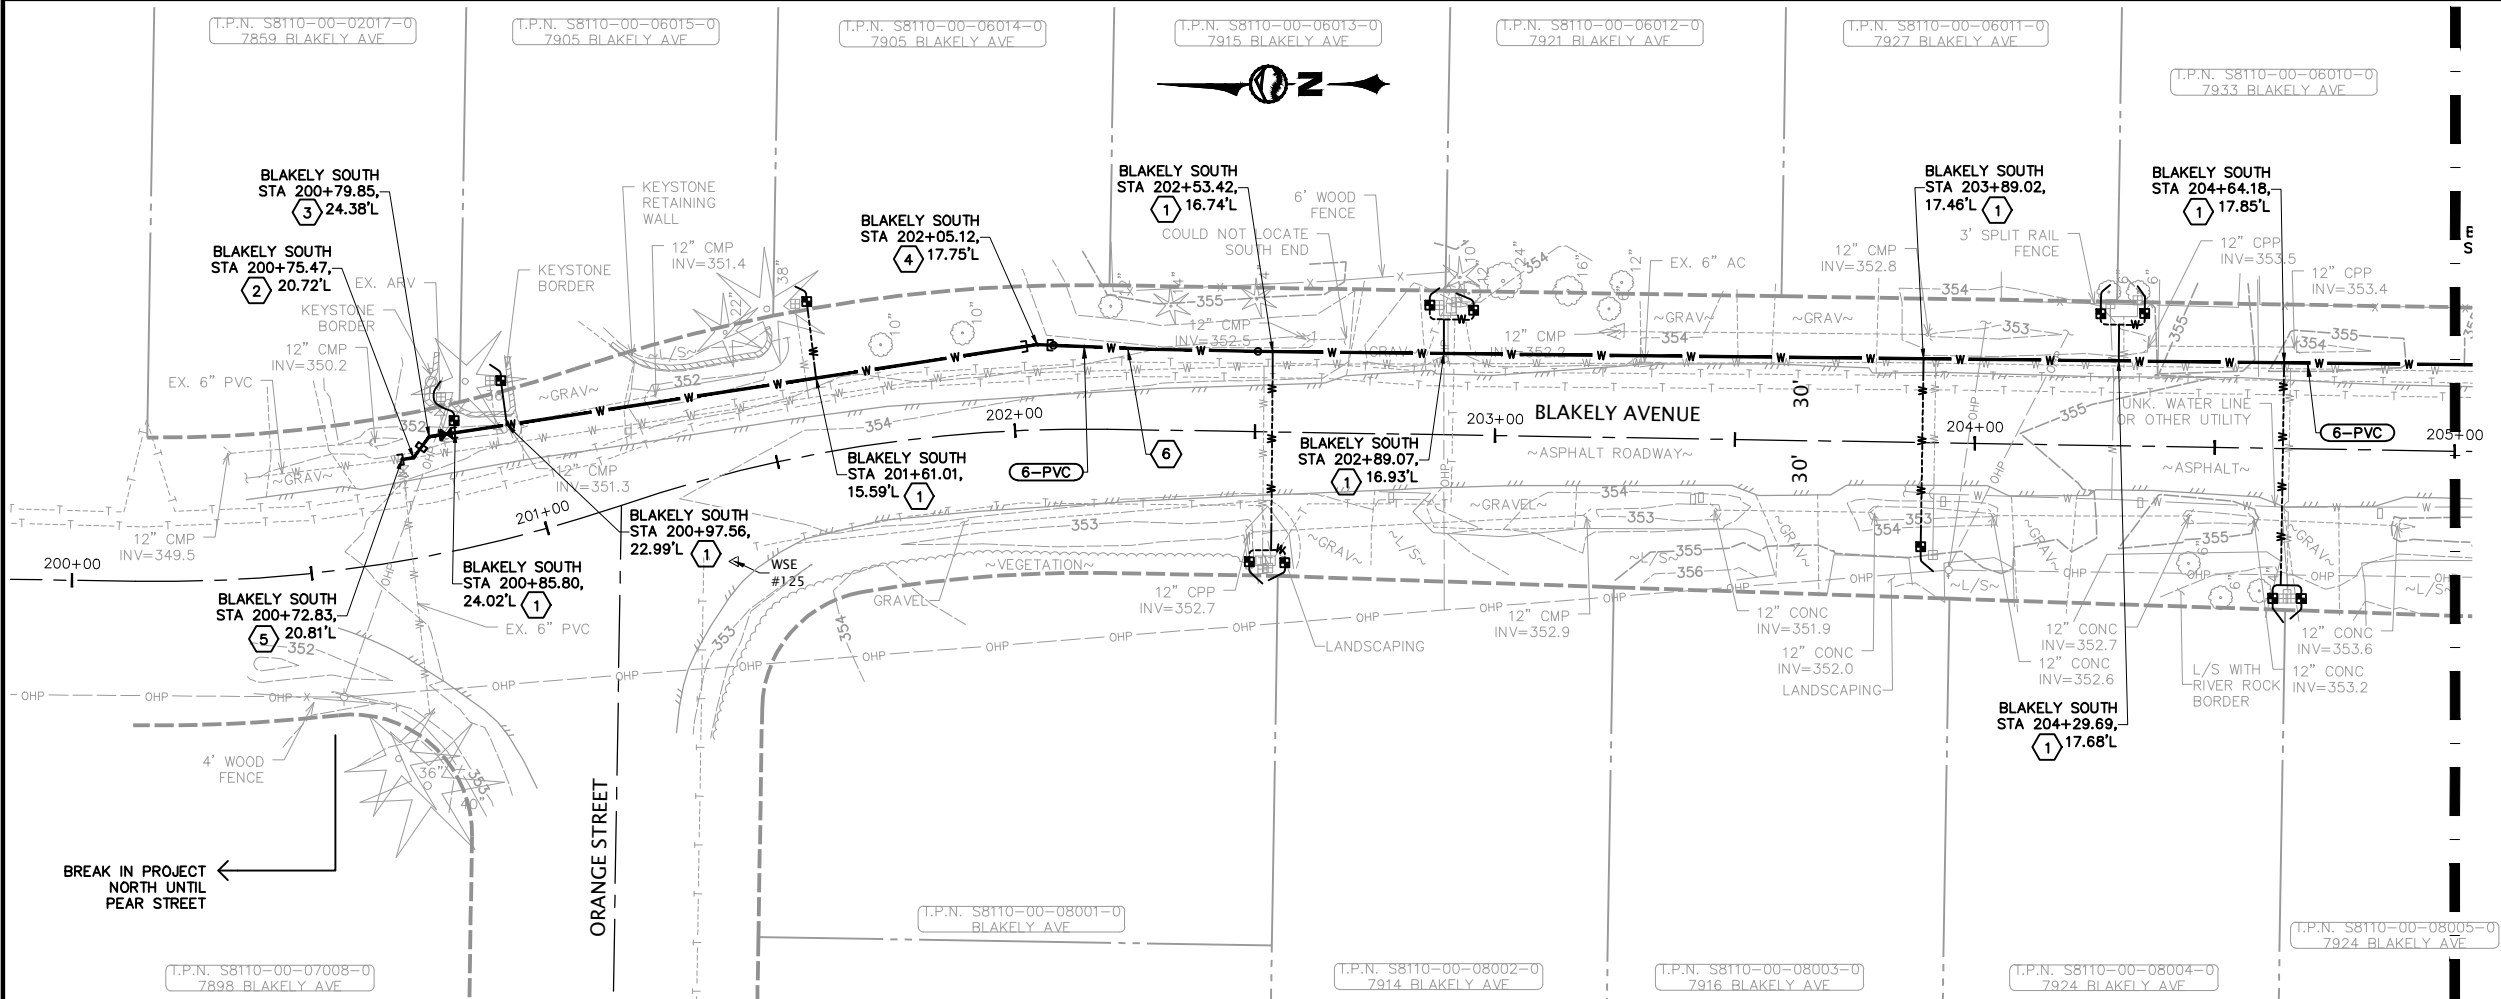

NO.	REVISIONS	BY	DATE
1	KEYED NOTES		
2	= SERVICE CONNECTION PER	X	X
3	= 6" 45' BEND MJxMJ, THRUST BLOCKING		
4	= 6" 45' BEND FLxMJ, 6" GV MJxFL, THRUST BLOCKING		
5	= 6" 11-1/4' BEND MJxMJ, THRUST BLOCKING		
6	= CONNECT TO EX. 6" TEE		
7	= MIN. 175' RADIUS		

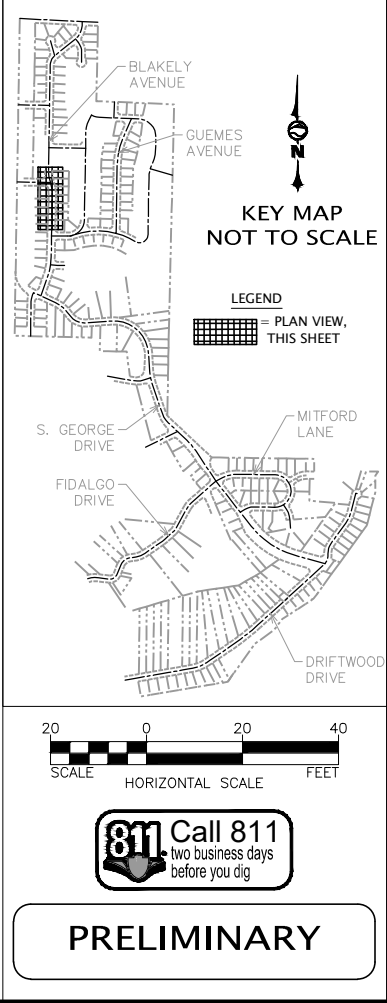

WILSON
ENGINEERING

WILSONENGINEERING.COM

DESIGNED BY
CDS/MKW

DRAWN BY
JGS

CHECKED BY
MMM

SCATCHET HEAD WATER DISTRICT

WASHINGTON

WATER SYSTEM IMPROVEMENTS

BLAKELY AVENUE SOUTH - STA 200+00 TO STA 205+00

SHEET
C4.3

DATE
12-8-22


SCALE
AS SHOWN

JOB NUMBER
2022-013

PAGE
X

OF
X

PLOT SETTINGS: AutoCAD PDF (General Documentation).pc3, ANSI full bleed B (17.00 x 11.00 inches), Portrait, 1:2, WE APWA_UNSCREENED.ctb
W:\2022\2022-013 SCATCHET HEAD WD WATER IMPROVEMENTS.MMM\DWG_V2019_NAD83_NAD88\2022_2022-013 C4.1-C4.5 BLAKELY PLAN & PROFILES.DWG - 12/8/2022 1:58 PM - Jeff Smith

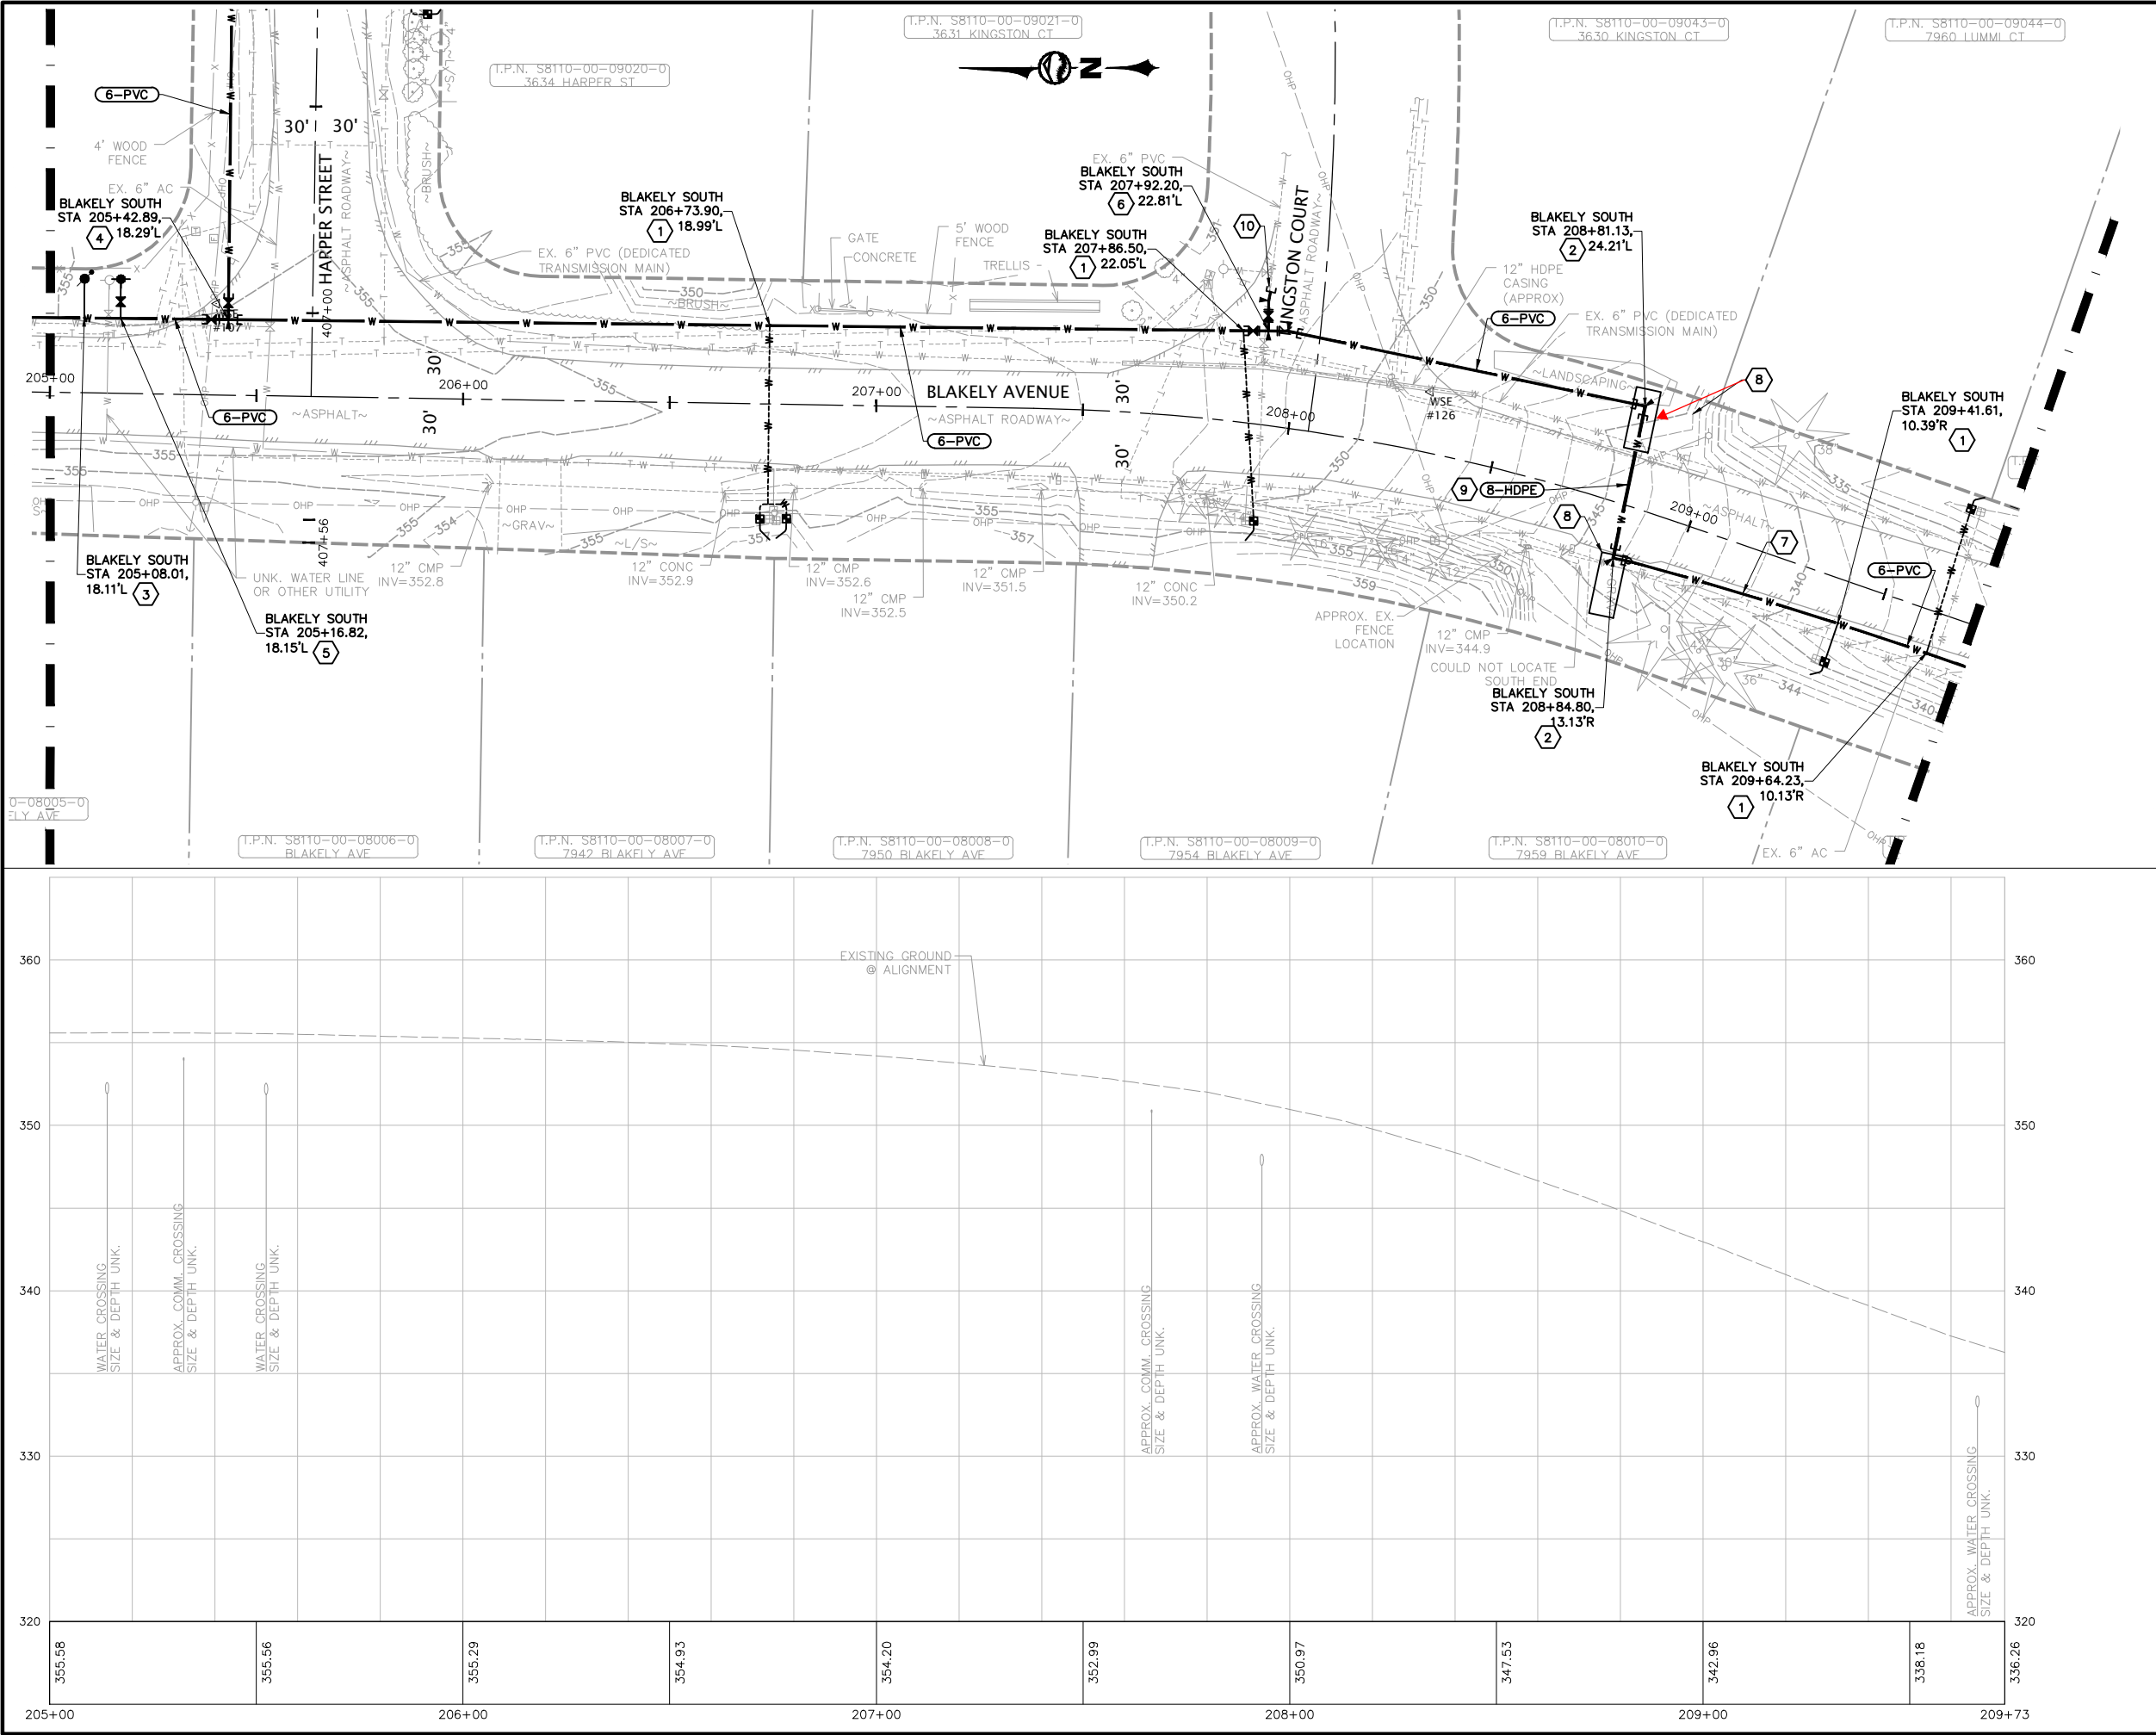

KEYED NOTES

- 1 = SERVICE CONNECTION PER $\frac{X}{X}$
- 2 = 6"x8" 90° BEND MJxMJ, THRUST BLOCKING
- 3 = COMBINATION AIR/VACUUM RELIEF VALVE. LOCATE AT HIGH POINT PER $\frac{X}{X}$
- 4 = 6" TEE FLxFLxMJ, (2) 6" GVx FLxMJ, THRUST BLOCKING
- 5 = HYDRANT ASS'Y PER $\frac{X}{X}$
- 6 = 6" TEE FLxFLxFL, 6" GV FLxMJ, 6" GV FLxFL, (2) 11-1/4" BENDs FLxMJ, THRUST BLOCKING
- 7 = MIN. 175' RADIUS
- 8 = HORIZONTAL DIRECTIONAL DRILL PIT
- 9 = 8" HDPE INSTALLED BY HORIZONTAL DIRECTIONAL DRILLING. HDPE ADAPTERS/FITTINGS AS REQUIRED
- 10 = CONNECT TO EX. 6" PVC

KEY MAP
NOT TO SCALE




LEGEND
PLAN VIEW, THIS SHEET

SCALE
HORIZONTAL SCALE
20 0 20 40
FEET

811 Call 811
two business days
before you dig

PRELIMINARY

NO.		REVISIONS		BY	DATE
WILSON ENGINEERING   DESIGNED BY: CDS/MKW DRAWN BY: JGS CHECKED BY: MMM SCATCHET HEAD WATER DISTRICT WASHINGTON WHIDBEY ISLAND WATER SYSTEM IMPROVEMENTS BLAKELY AVENUE SOUTH - STA 205+00 TO STA 209+73 SHEET C4.4 DATE 12-8-22 SCALE AS SHOWN JOB NUMBER 2022-013 PAGE X OF X					

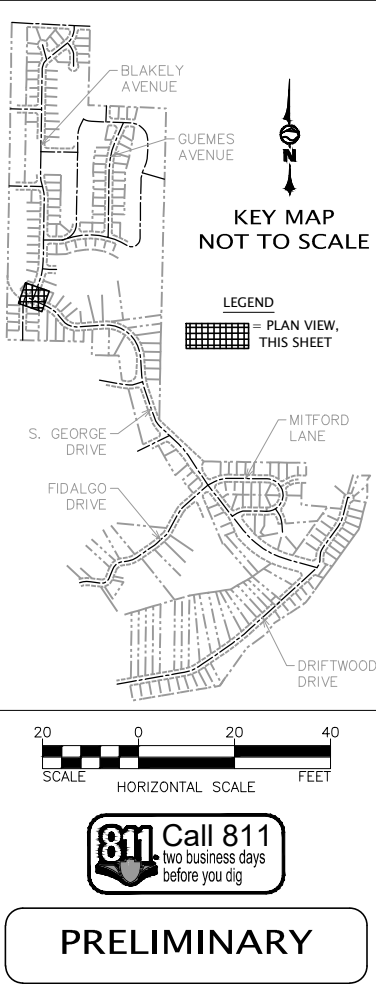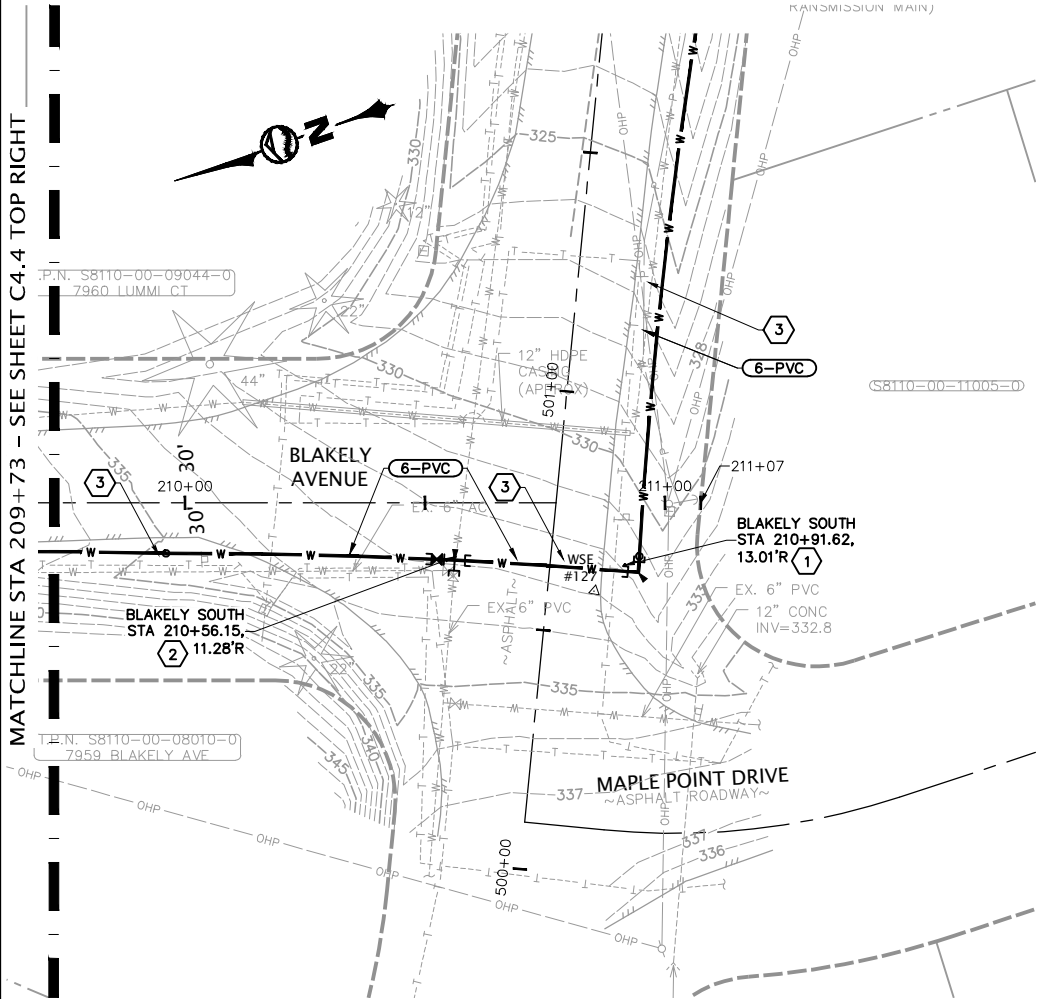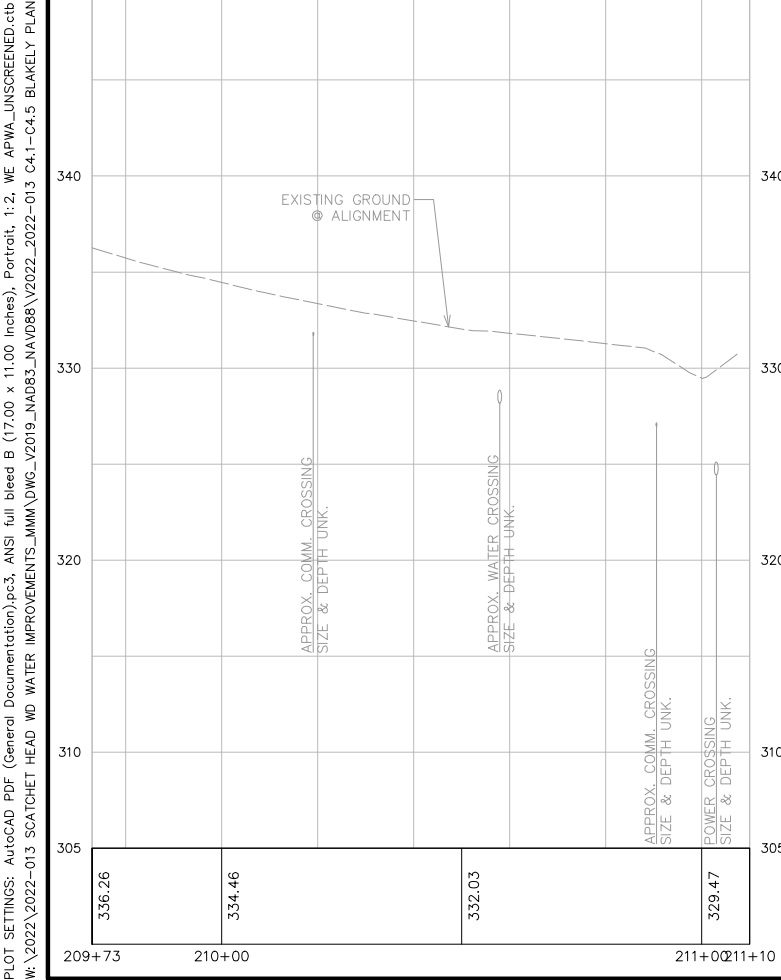


NO.	REVISIONS	BY	DATE

KEYED NOTES

- ① = 6" 90° BEND MJxMJ, THRUST BLOCKING
- ② = CONNECT TO EXISTING 6" TEE FLxMJxMJ, 6" GV FLxMJ, THRUST BLOCKING
- ③ = MIN. 175' RADIUS

SHEET C4.5	DATE 12-8-22	SCATCHET HEAD WATER DISTRICT		DESIGNED BY CDS/MXW	D. SCHNEVELDER OF WASHINGTON REGISTERED PROFESSIONAL
	SCALE AS SHOWN	WASHINGTON		DRAWN BY JGS	
PAGE X OF X	JOB NUMBER 2022-013	WATER SYSTEM IMPROVEMENTS		CHECKED BY MMM	WILSON ENGINEERING WILSONENGINEERING.COM
BLAKELY AVENUE SOUTH - STA 209+73 TO STA 211+07					

PLOT SETTINGS: AutoCAD PDF (General Documentation).pc3, ANSI full bleed B (17.00 x 11.00 inches), Portrait, 1:2, WE APWA_UNSCREENED.ctb
W:\2022-2022-013 SCATCHET HEAD WD WATER IMPROVEMENTS.MMM\DWG_V2019_NAD83_NAD88\2022_013 C4.6-C4.9 GUEMES & HARPER PLAN & PROFILES.DWG - 12/8/2022 1:59 PM - Jeff Smith

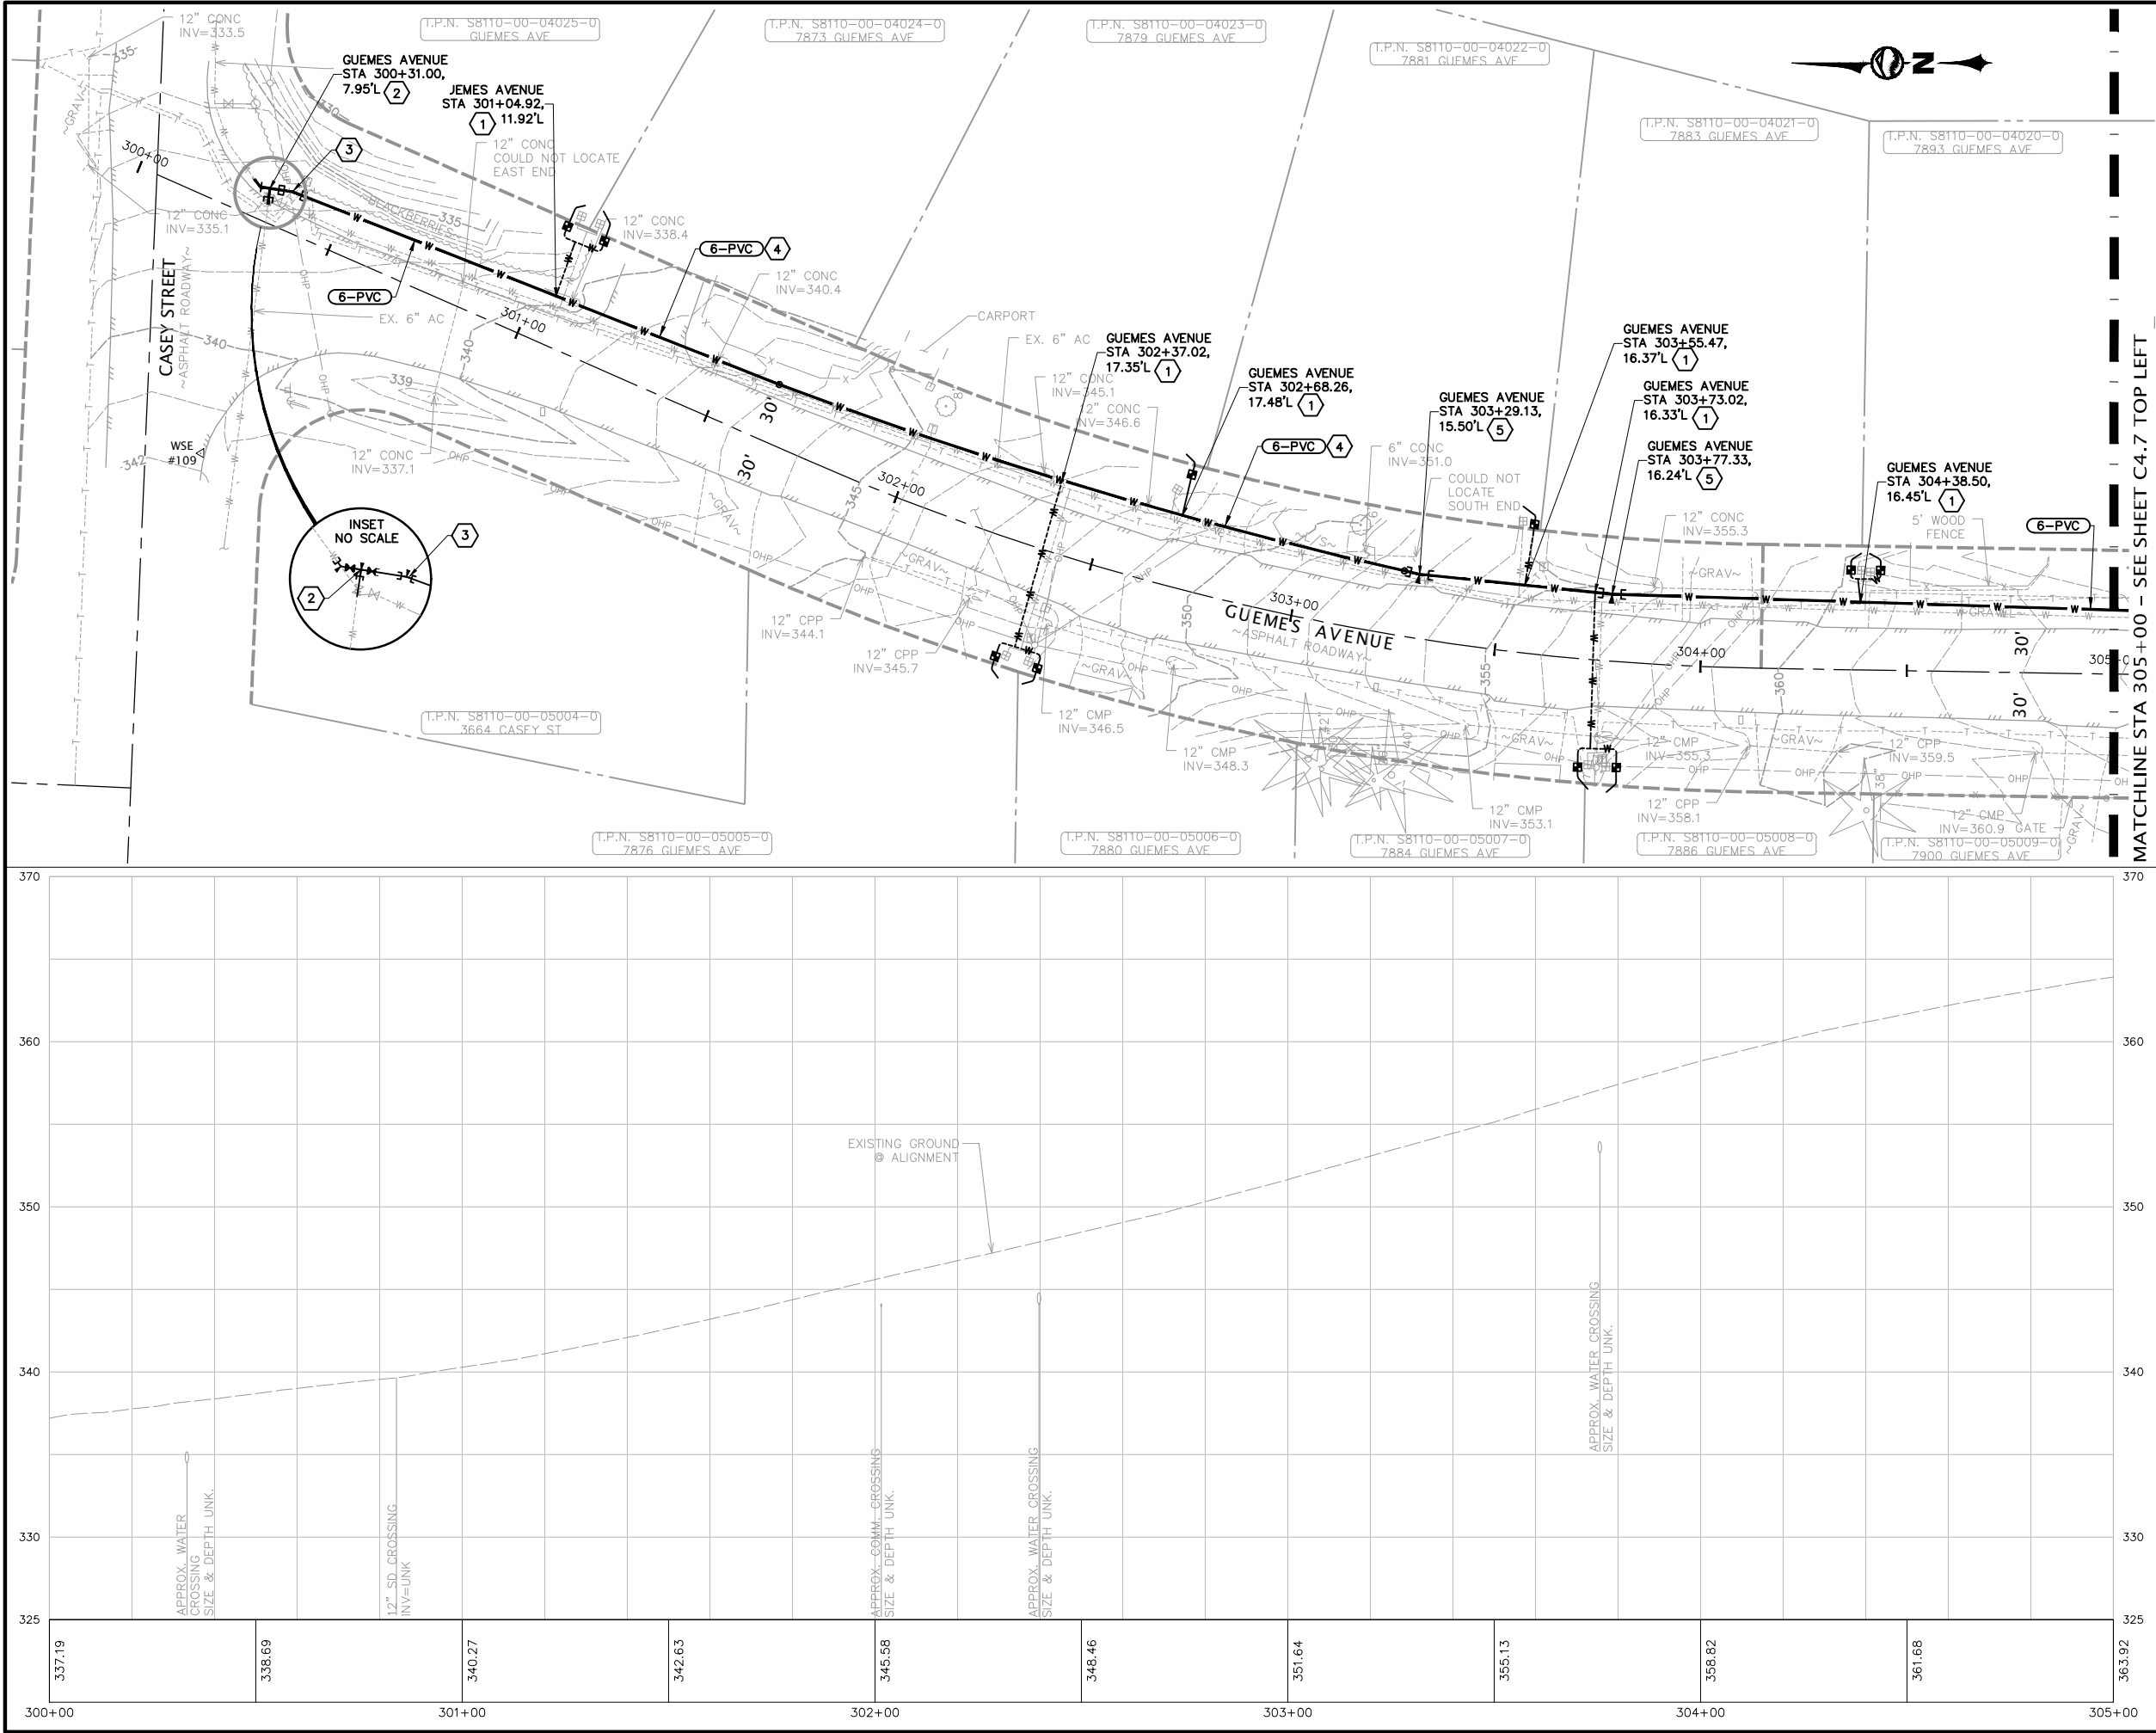

NO.

REVISIONS

BY

DATE

KEYED NOTES

1

= SERVICE CONNECTION PER

X

X

2

= 6" TEE FLxMJxFL, (2) 6" GVs MJxFL, 6" 45' BEND FLxMJ, THRUST BLOCKING, CONNECT TO EX. 6" PVC (NORTH), CONNECT TO EX. GV (WEST)

3

= 6" 11-1/4' BEND MJxMJ, THRUST BLOCKING

4

= MIN. 175' RADIUS

5

= BEND AS REQUIRED, THRUST BLOCKING

INSET NO SCALE

2

3

300+00

301+00

302+00

303+00

304+00

305+00

325

330

340

350

360

370

APPROX. WATER CROSSING SIZE & DEPTH UNK.

12" SD. CROSSING INV=UNK

APPROX. COMM. CROSSING SIZE & DEPTH UNK.

APPROX. WATER CROSSING SIZE & DEPTH UNK.

337.19

338.69

340.27

342.63

345.58

348.46

351.64

355.13

358.82

361.68

363.92

300+00

301+00

302+00

303+00

304+00

305+00

325

330

340

350

360

370

APPROX. WATER CROSSING SIZE & DEPTH UNK.

12" SD. CROSSING INV=UNK

APPROX. COMM. CROSSING SIZE & DEPTH UNK.

APPROX. WATER CROSSING SIZE & DEPTH UNK.

337.19

338.69

340.27

342.63

345.58

348.46

351.64

355.13

358.82

361.68

363.92

300+00

301+00

302+00

303+00

304+00

305+00

KEY MAP NOT TO SCALE

LEGEND

PLAN VIEW, THIS SHEET

20

0

20

40

SCALE

HORIZONTAL SCALE

FEET

811

Call 811

two business days before you dig

PRELIMINARY

DESIGNED BY

XXX

DRAWN BY

JGS

CHECKED BY

CDS

SCATCHET HEAD WATER DISTRICT

WASHINGTON

WHIDBEY ISLAND

WATER SYSTEM IMPROVEMENTS

GUEMES AVENUE - STA 300+00 TO STA 305+00

DATE

12-8-22

SCALE

AS SHOWN

JOB NUMBER

2022-013

SHEET

C4.6

PAGE

X

OF



X

WILSON ENGINEERING


WILSONENGINEERING.COM

PRELIMINARY

PLOT SETTINGS: AutoCAD PDF (General Documentation).pc3, ANSI full bleed B (17.00 x 11.00 inches), Portrait, 1:2, WE APWA_UNSCREENED.ctb
W:\2022\2022-013 SCATCHET HEAD WD WATER IMPROVEMENTS.MMM\DWG_V2019_NAD83_NAD88\2022_2022-013 C4.6-C4.9 GUEMES & HARPER PLAN & PROFILES.DWG - 12/8/2022 1:59 PM - Jeff Smith

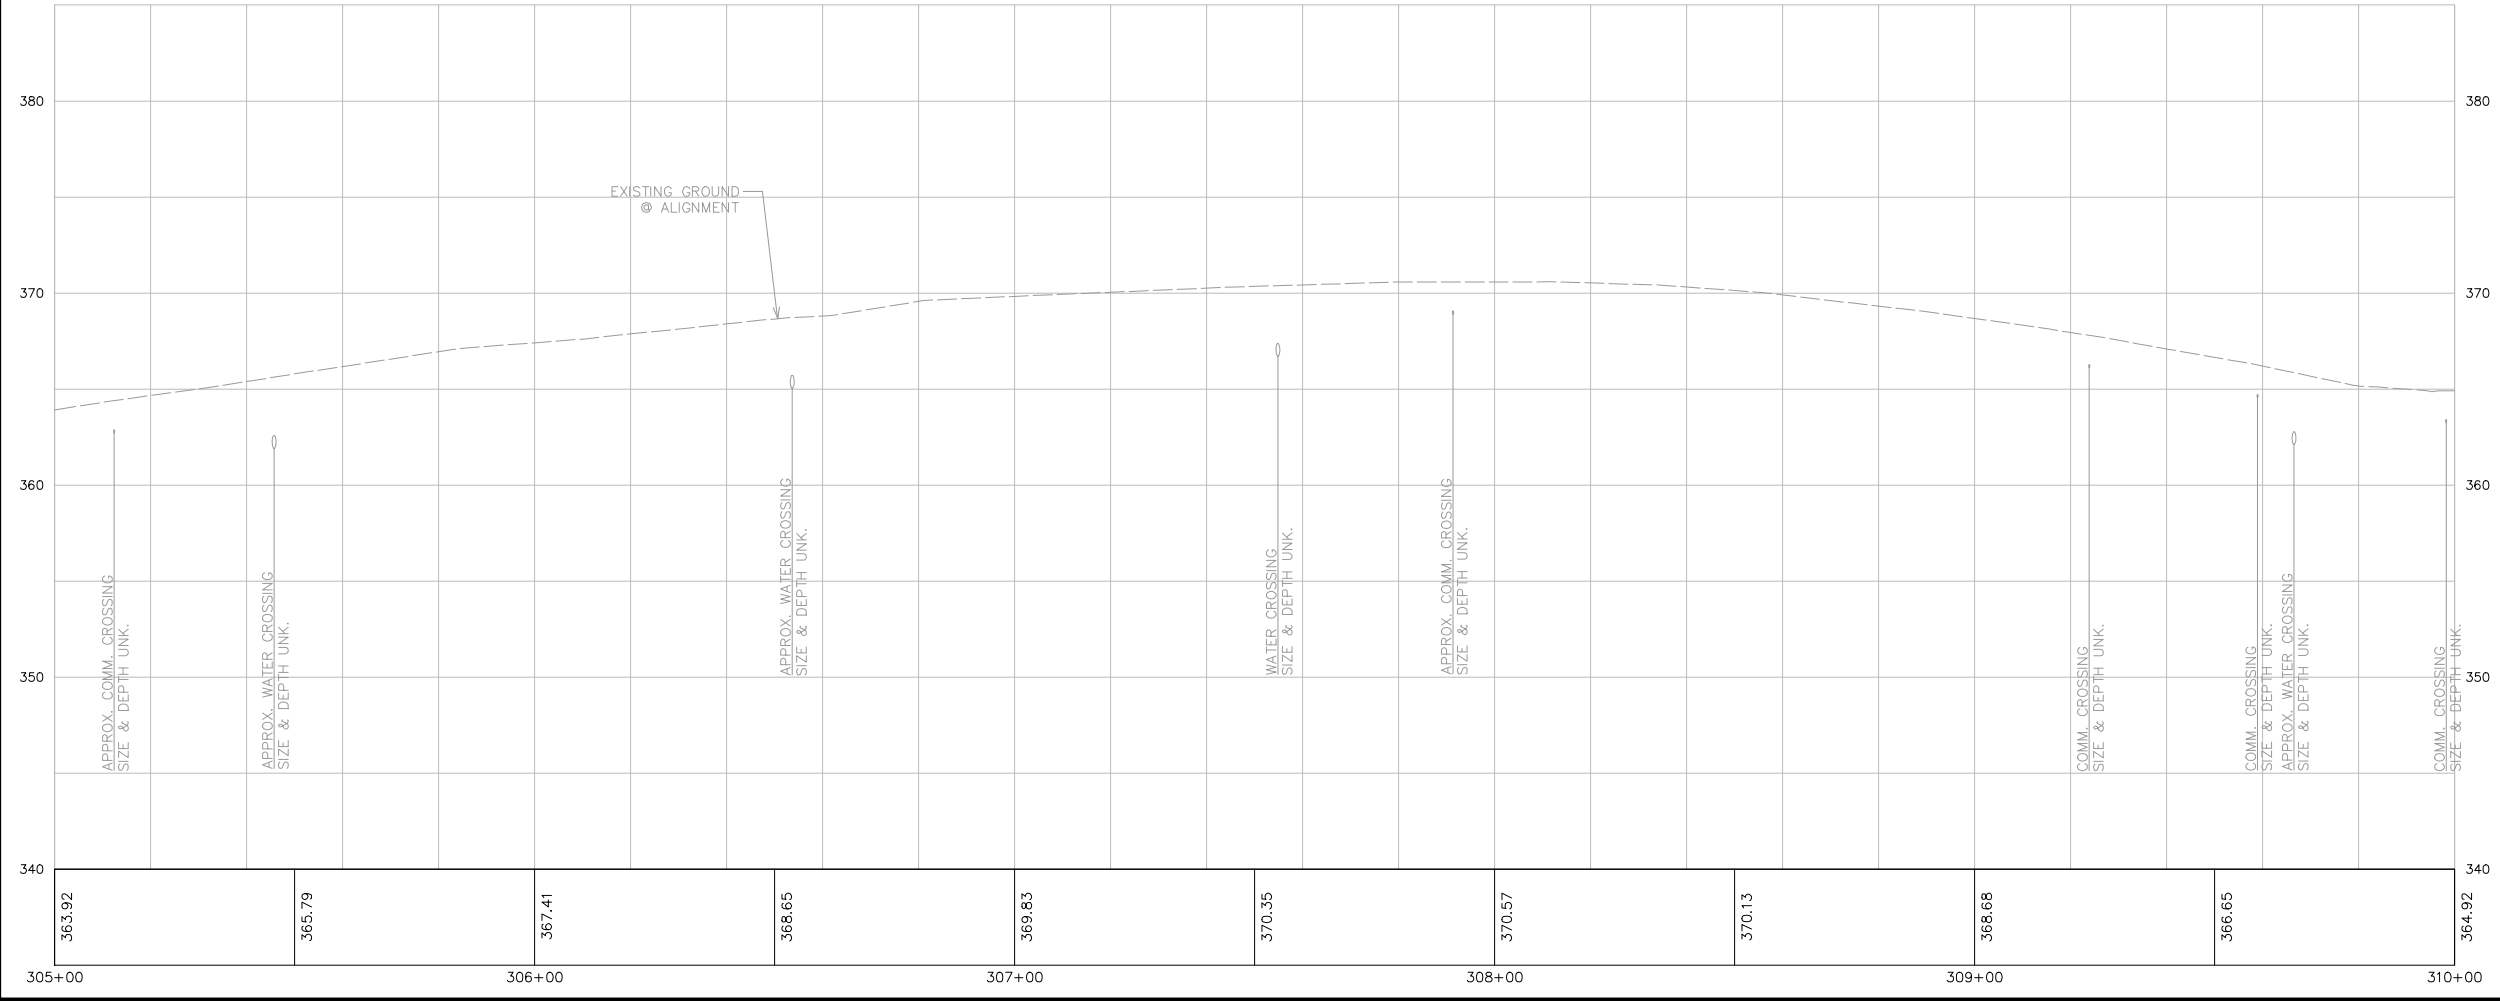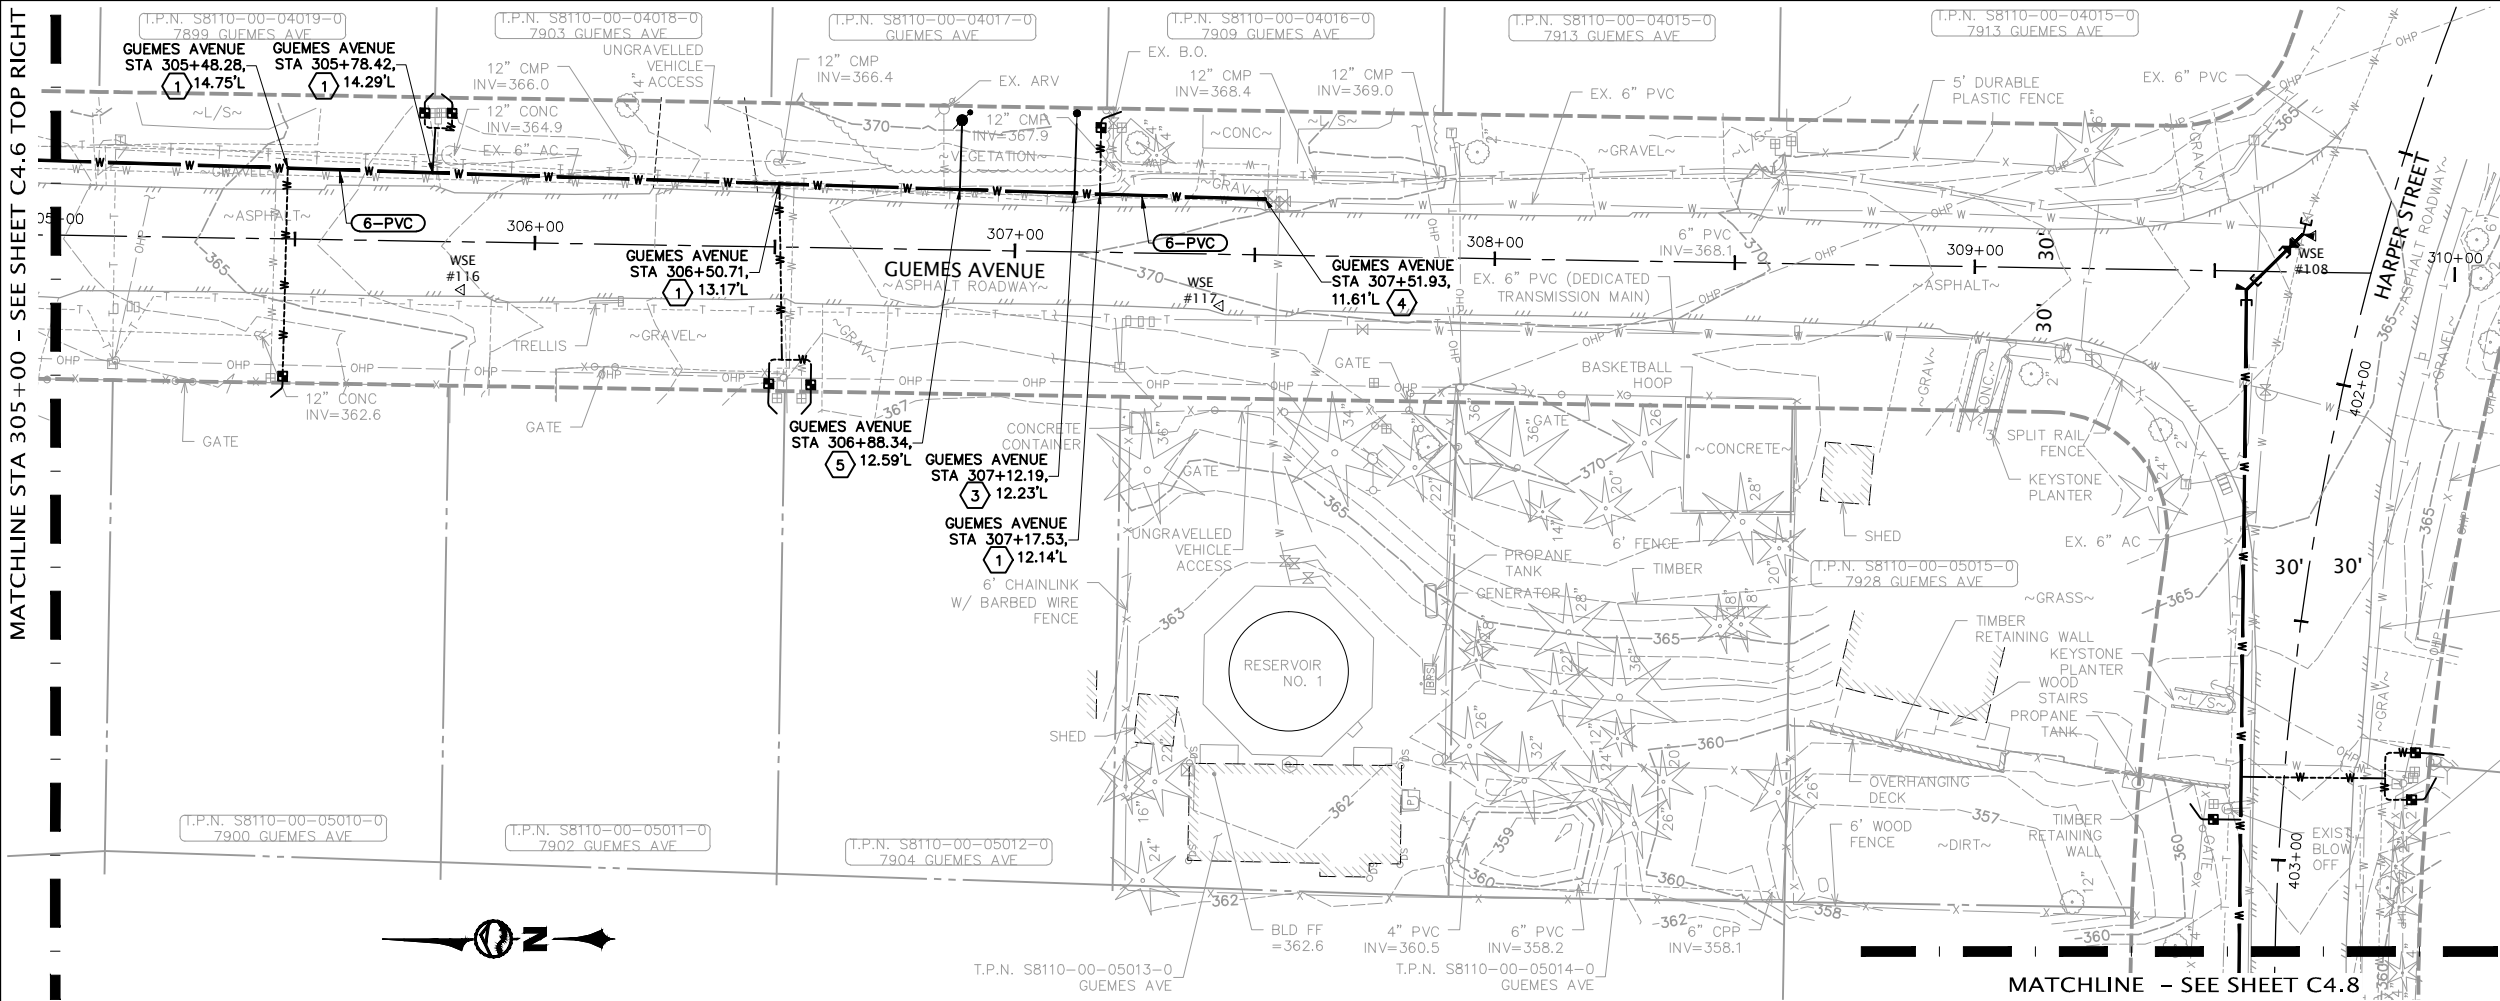

NO.	REVISIONS	BY	DATE
1	KEYED NOTES		
2	= SERVICE CONNECTION PER	X	X
3	= 6" BEND MxMJ AS REQUIRED, THRUST BLOCKING	X	X
4	= BLOW-OFF VALVE PER	X	X
5	= CONNECT TO EX. 6" GATE VALVE	X	X
6	= COMBINATION AIR/VACUUM RELIEF VALVE. LOCATE AT HIGH POINT PER	X	X

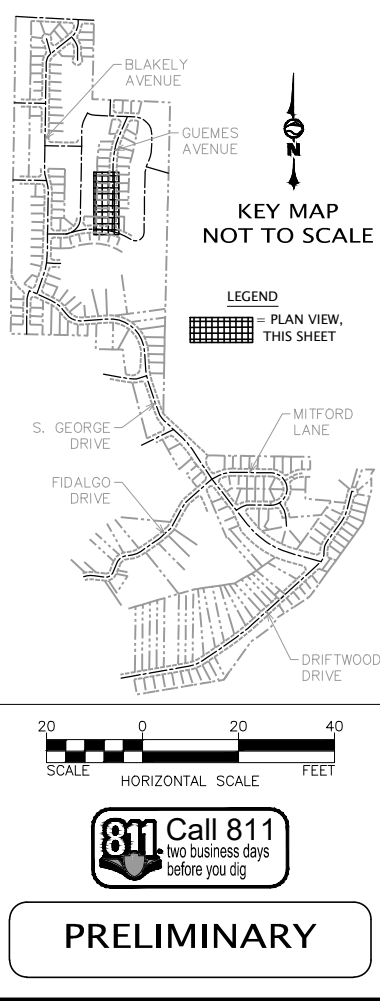

WILSON
ENGINEERING

WILSONENGINEERING.COM

PRELIMINARY

DESIGNED BY
XXX

DRAWN BY
JGS

CHECKED BY
CDS

SCATCHET HEAD WATER DISTRICT

WASHINGTON

WATER SYSTEM IMPROVEMENTS

WHIDBEY ISLAND

SHEET
C4.7

DATE
12-8-22



SCALE
AS SHOWN

JOB NUMBER
2022-013

PAGE
X

OF
X

PLOT SETTINGS: AutoCAD PDF (General Documentation).pc3, ANSI full bleed B (17.00 x 11.00 inches), Portrait, 1:2, WE APWA_UNSCREENED.ctb
W:\2022-013 SCATCHET HEAD WD WATER IMPROVEMENTS.MMM\DWG_V2019_NAD83_NAVD88\2022_013 C4.6-C4.9 GUEMES & HARPER PLAN & PROFILES.DWG - 12/8/2022 2:00 PM - Jeff Smith

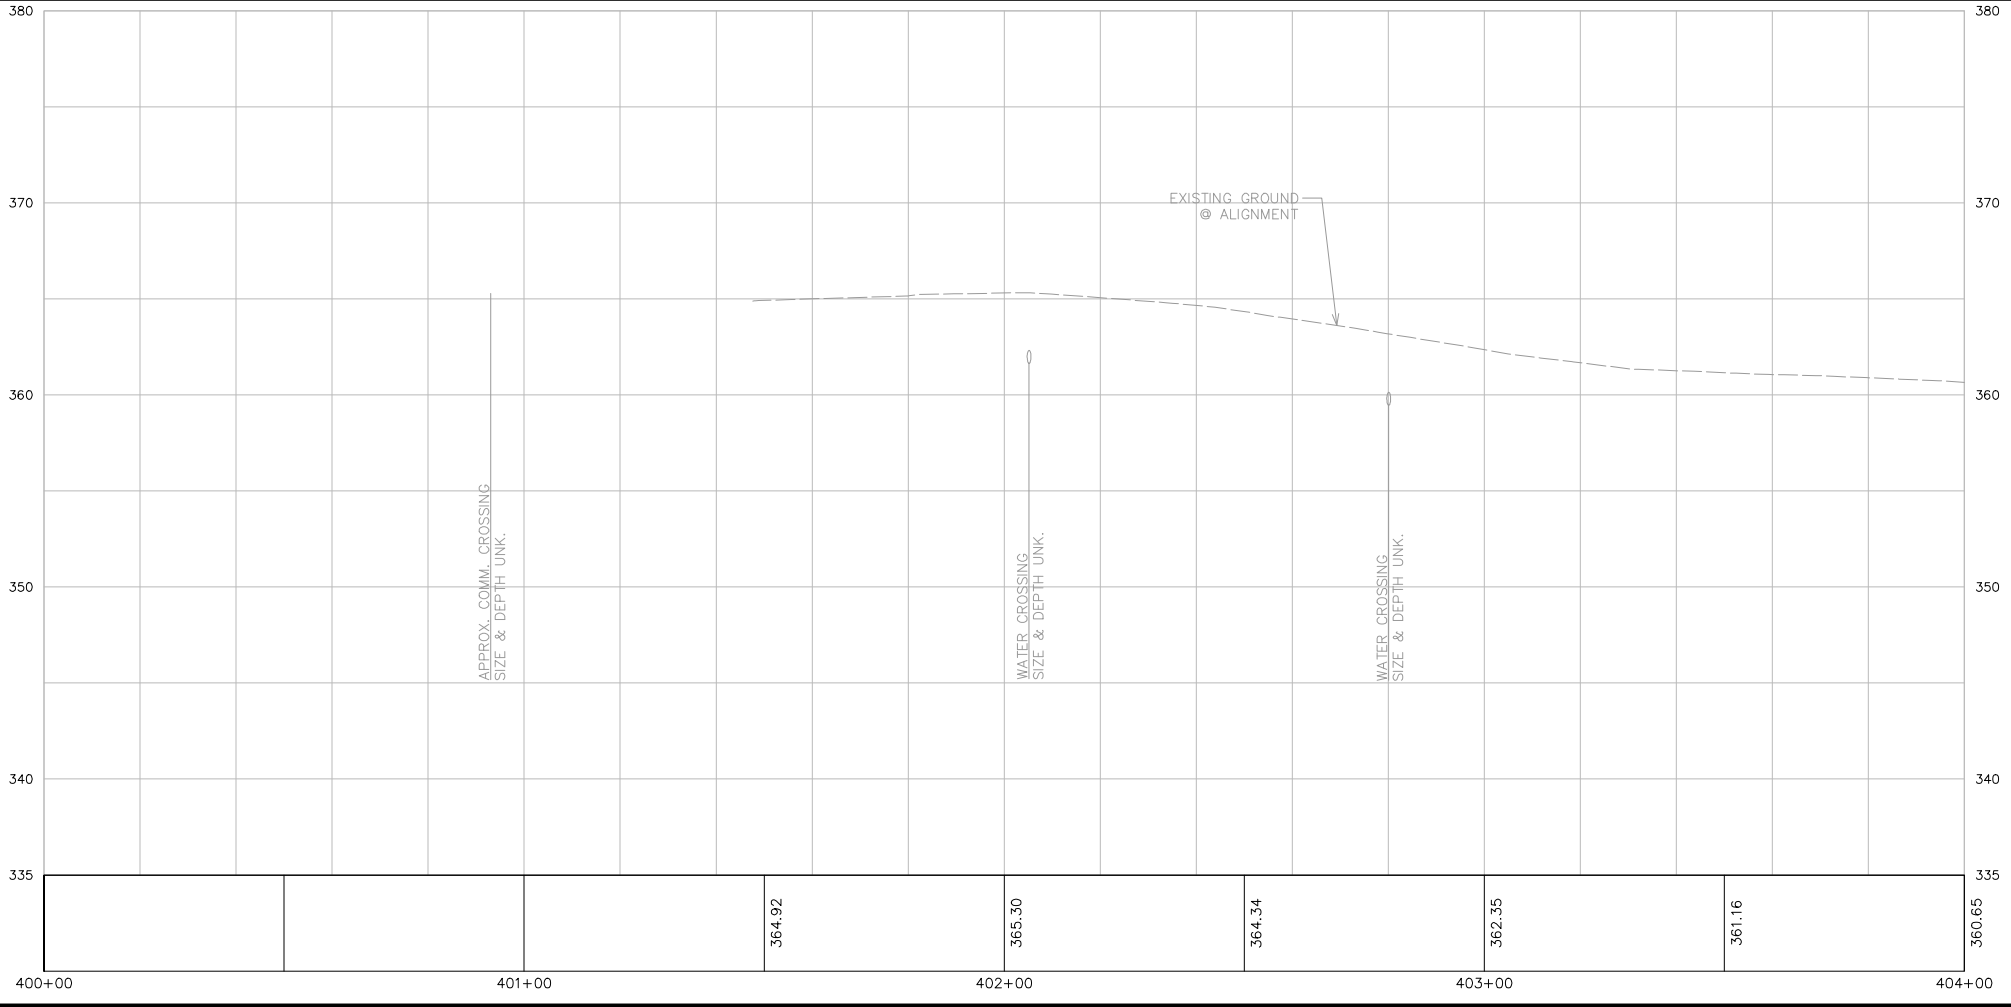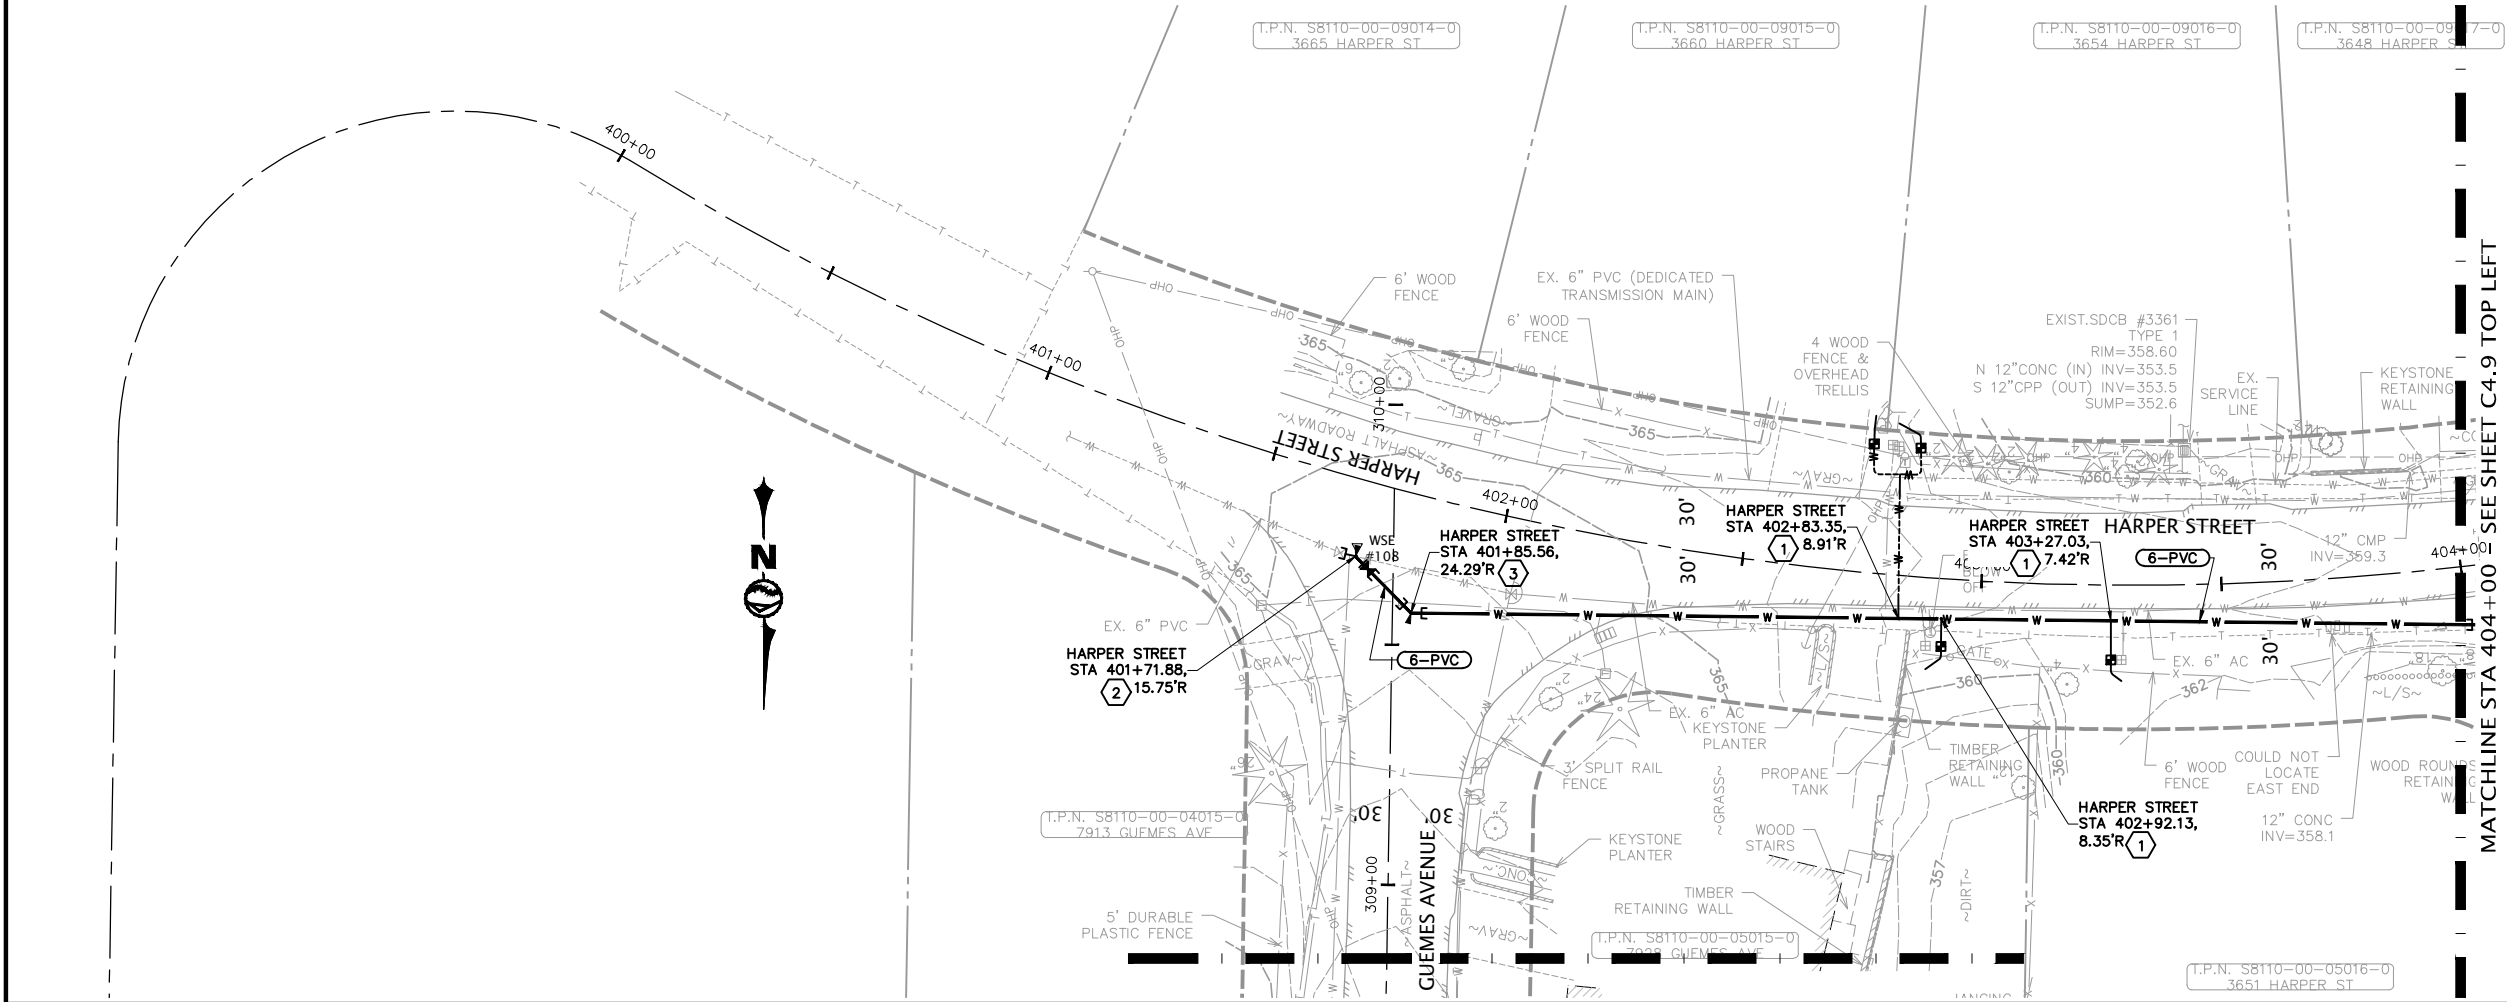

NO.	REVISIONS	BY	DATE
1	KEYED NOTES		
2	= SERVICE CONNECTION PER	X	X
3	= CONNECT TO EX. 6" PVC/DI TEE. 6" 45' BEND MxJFL 6" GV FLxMJ, THRUST BLOCKING		
4	= 6" 45' BEND, MxMJ, THRUST BLOCKING		

SEE SHEET C4.9 TOP LEFT

MATCHLINE STA 404+00

KEY MAP NOT TO SCALE

LEGEND

PLAN VIEW, THIS SHEET

20 0 20 40
SCALE HORIZONTAL SCALE FEET

811 Call 811
two business days
before you dig

PRELIMINARY

WILSON
ENGINEERING

WILSONENGINEERING.COM

PRELIMINARY

DESIGNED BY
XXX

DRAWN BY
JGS

CHECKED BY
CDS

SCATCHET HEAD WATER DISTRICT

WASHINGTON

WHIDBEY ISLAND

WATER SYSTEM IMPROVEMENTS

HARPER STREET - STA 400+00 TO STA 404+00

SHEET
C4.8

DATE
12-8-22



SCALE
AS SHOWN

JOB NUMBER
2022-013

PAGE
X

OF
X

PLOT SETTINGS: AutoCAD PDF (General Documentation).pc3, ANSI full bleed B (17.00 x 11.00 inches), Portrait, 1:2, WE APWA_UNSCREENED.ctb
W:\2022\2022-013 SCATCHET HEAD WD WATER IMPROVEMENTS.MMM\DWG_V2019_NAD83_NAD88\2022_013 C4.6-C4.9 GUEMES & HARPER PLAN & PROFILES.DWG - 12/8/2022 2:00 PM - Jeff Smith

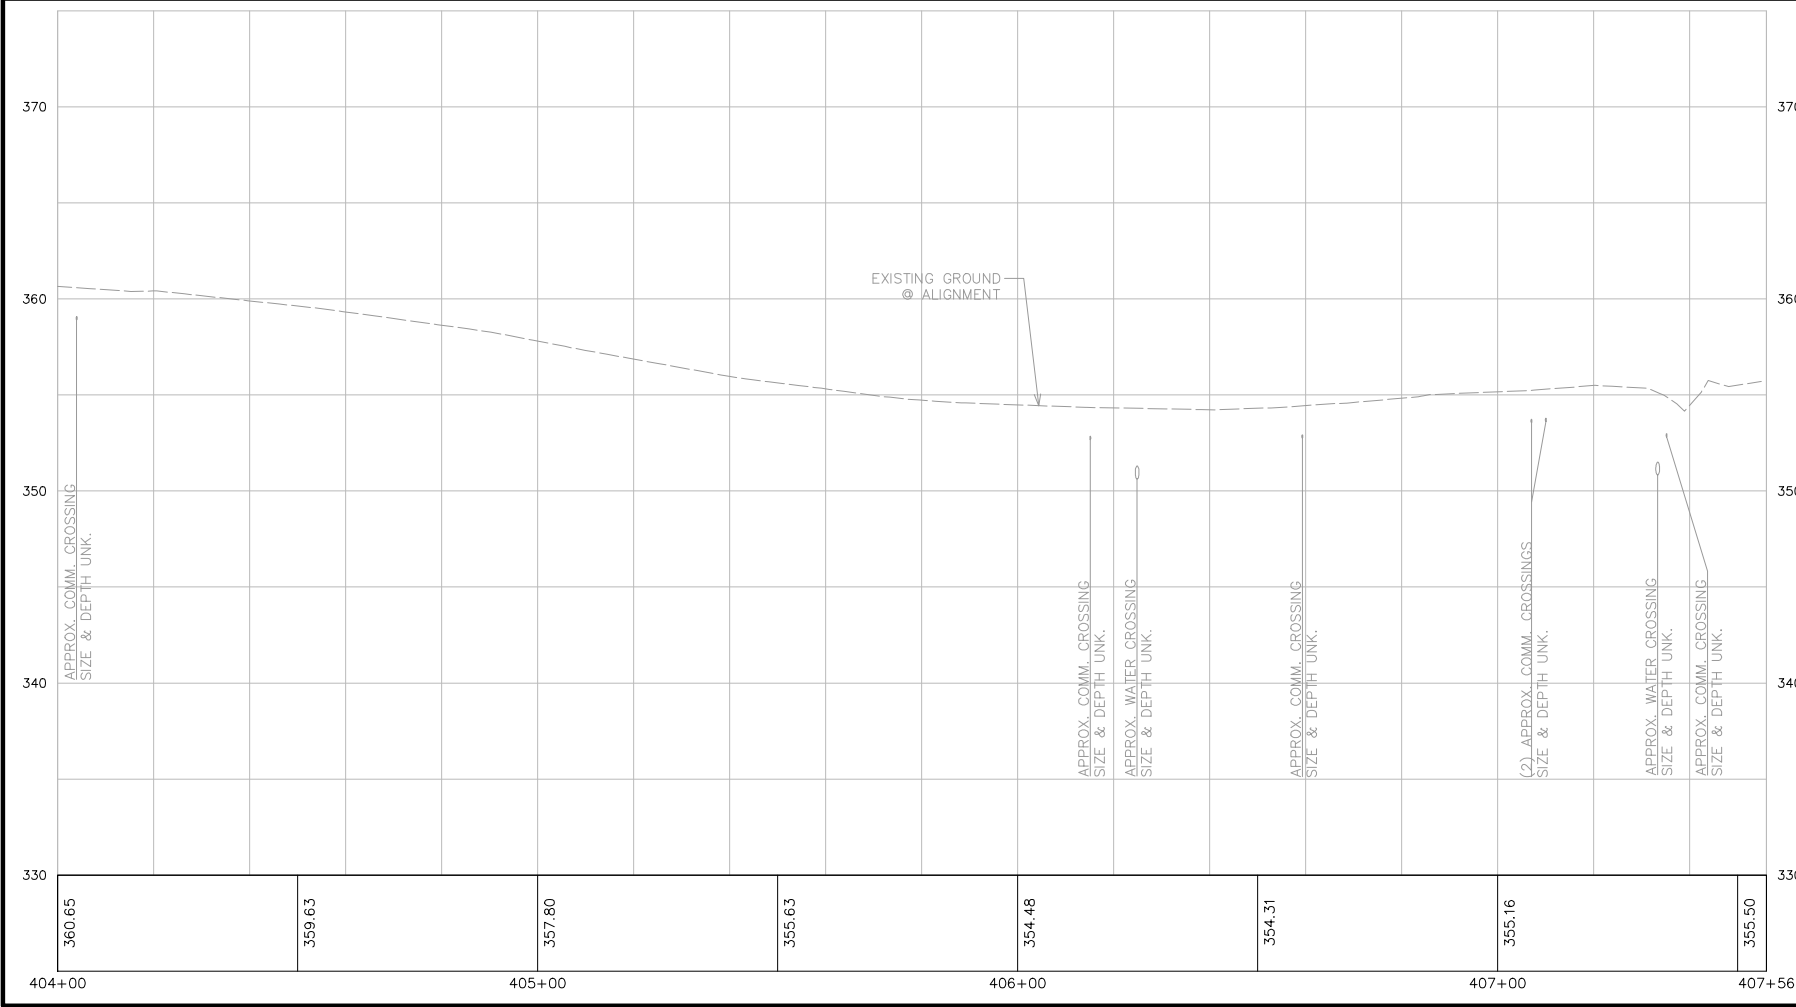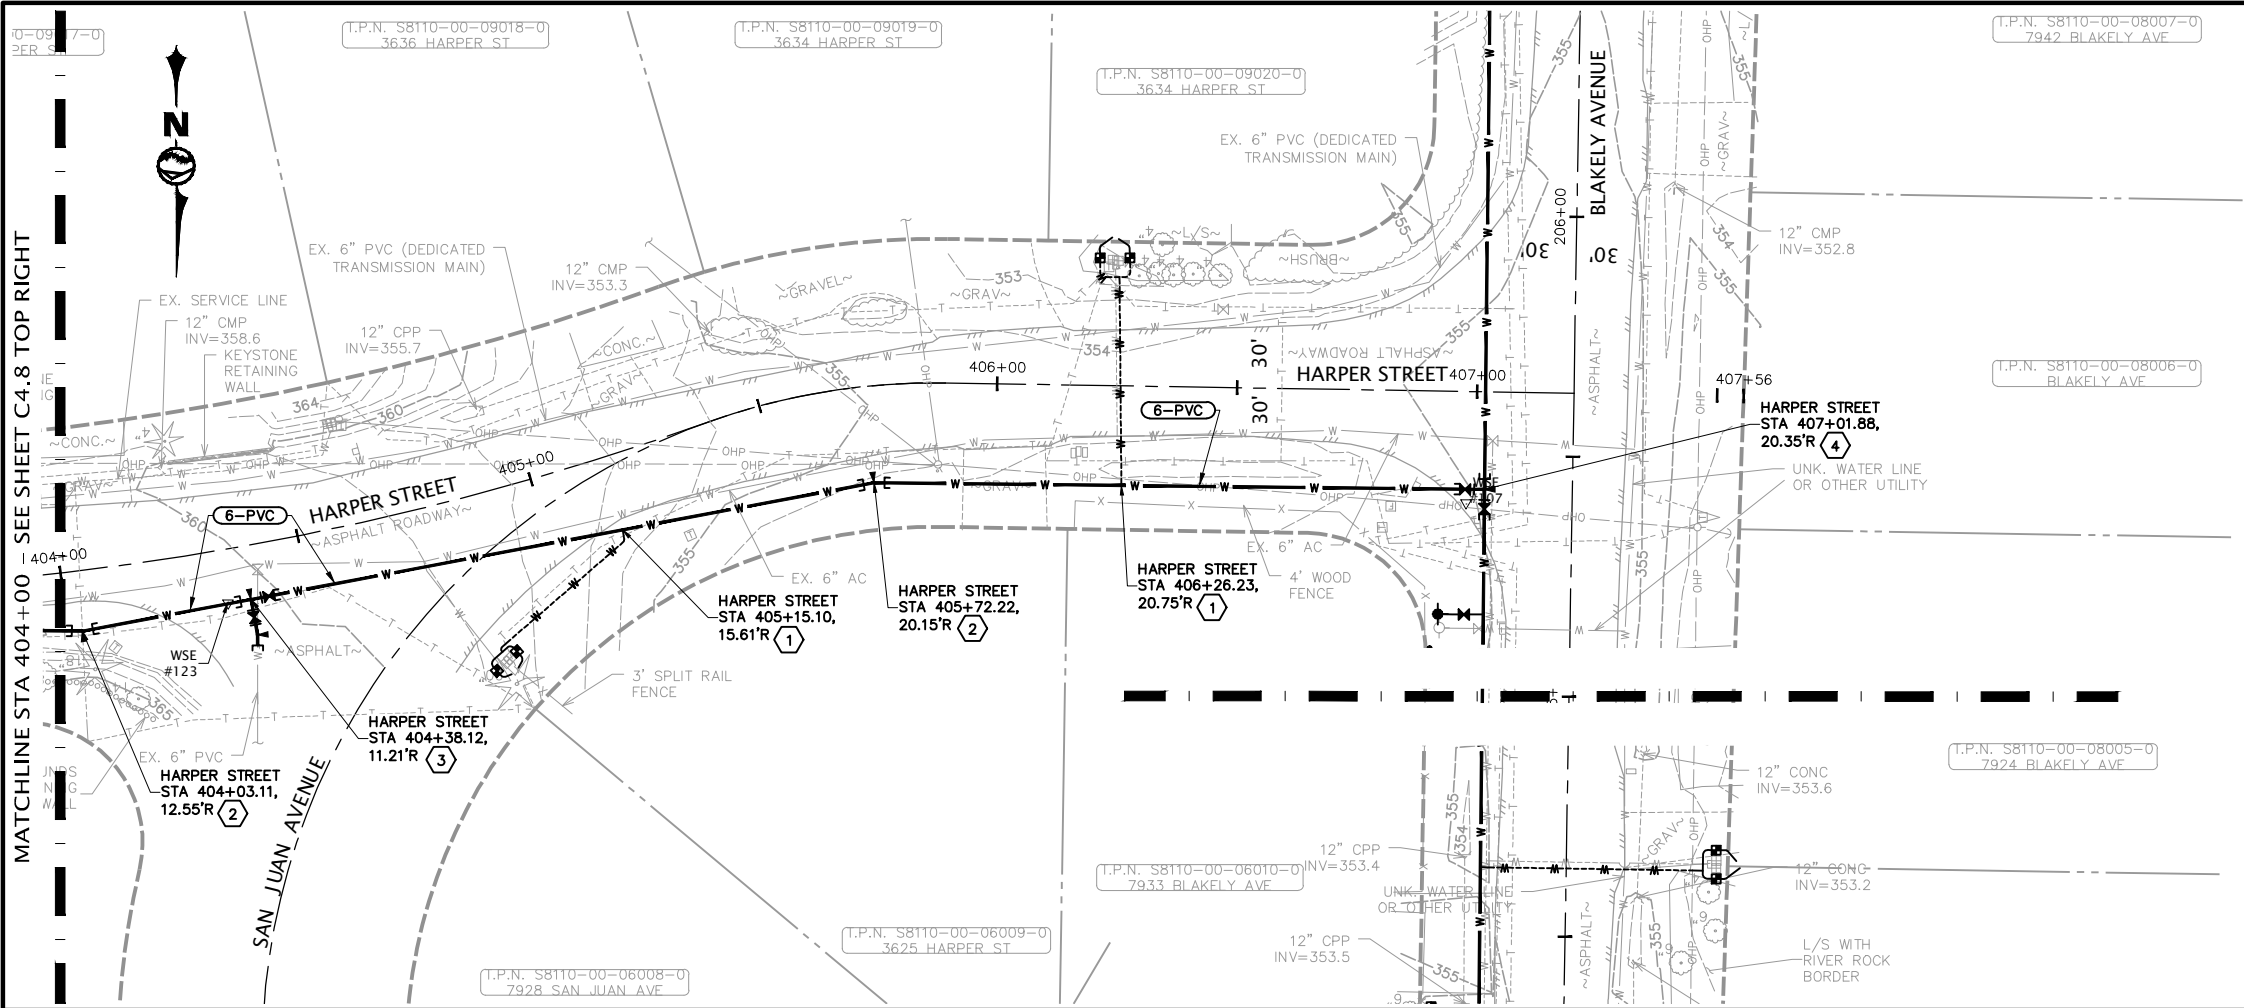

NO.	REVISIONS	BY	DATE

KEYED NOTES

① = SERVICE CONNECTION PER $\frac{X}{X}$

② = 6" 11-1/4" BEND MxMJ, THRUST BLOCKING

③ = 6" TEE FLxFLxMJ, 6" GV FLxMJ, 6" GV FLxFL, 6" 11-1/4" BEND FLxMJ, THRUST BLOCKING. CONNECT TO EX. 6" PVC

④ = 6" TEE FLxFLxMJ, (2) 6" GVs FLxMJ, THRUST BLOCKING

KEY MAP
NOT TO SCALE

LEGEND
PLAN VIEW, THIS SHEET

20 0 20 40
SCALE HORIZONTAL SCALE FEET

811 Call 811
two business days
before you dig

PRELIMINARY

SHEET		DATE	SCALE	JOB NUMBER	
C4.9		12-8-22	AS SHOWN	2022-013	

PAGE		OF
X		X

SCATCHET HEAD WATER DISTRICT


WATER SYSTEM IMPROVEMENTS

HARPER STREET - STA 404+00 TO STA 407+56

WILSON ENGINEERING

WILSONENGINEERING.COM

PLOT SETTINGS: AutoCAD PDF (General Documentation).pc3, ANSI full bleed B (17.00 x 11.00 inches), Portrait, 1:2, WE APWA_UNSCREENED.ctb
W:\2022\2022-013 SCATCHET HEAD WD WATER IMPROVEMENTS.MMM\DWG_V2019_NAD83_NAYD88\2022_2022-013 C4.10-C4.17 GEORGE PLAN & PROFILES.DWG - 12/8/2022 2:01 PM - Jeff Smith

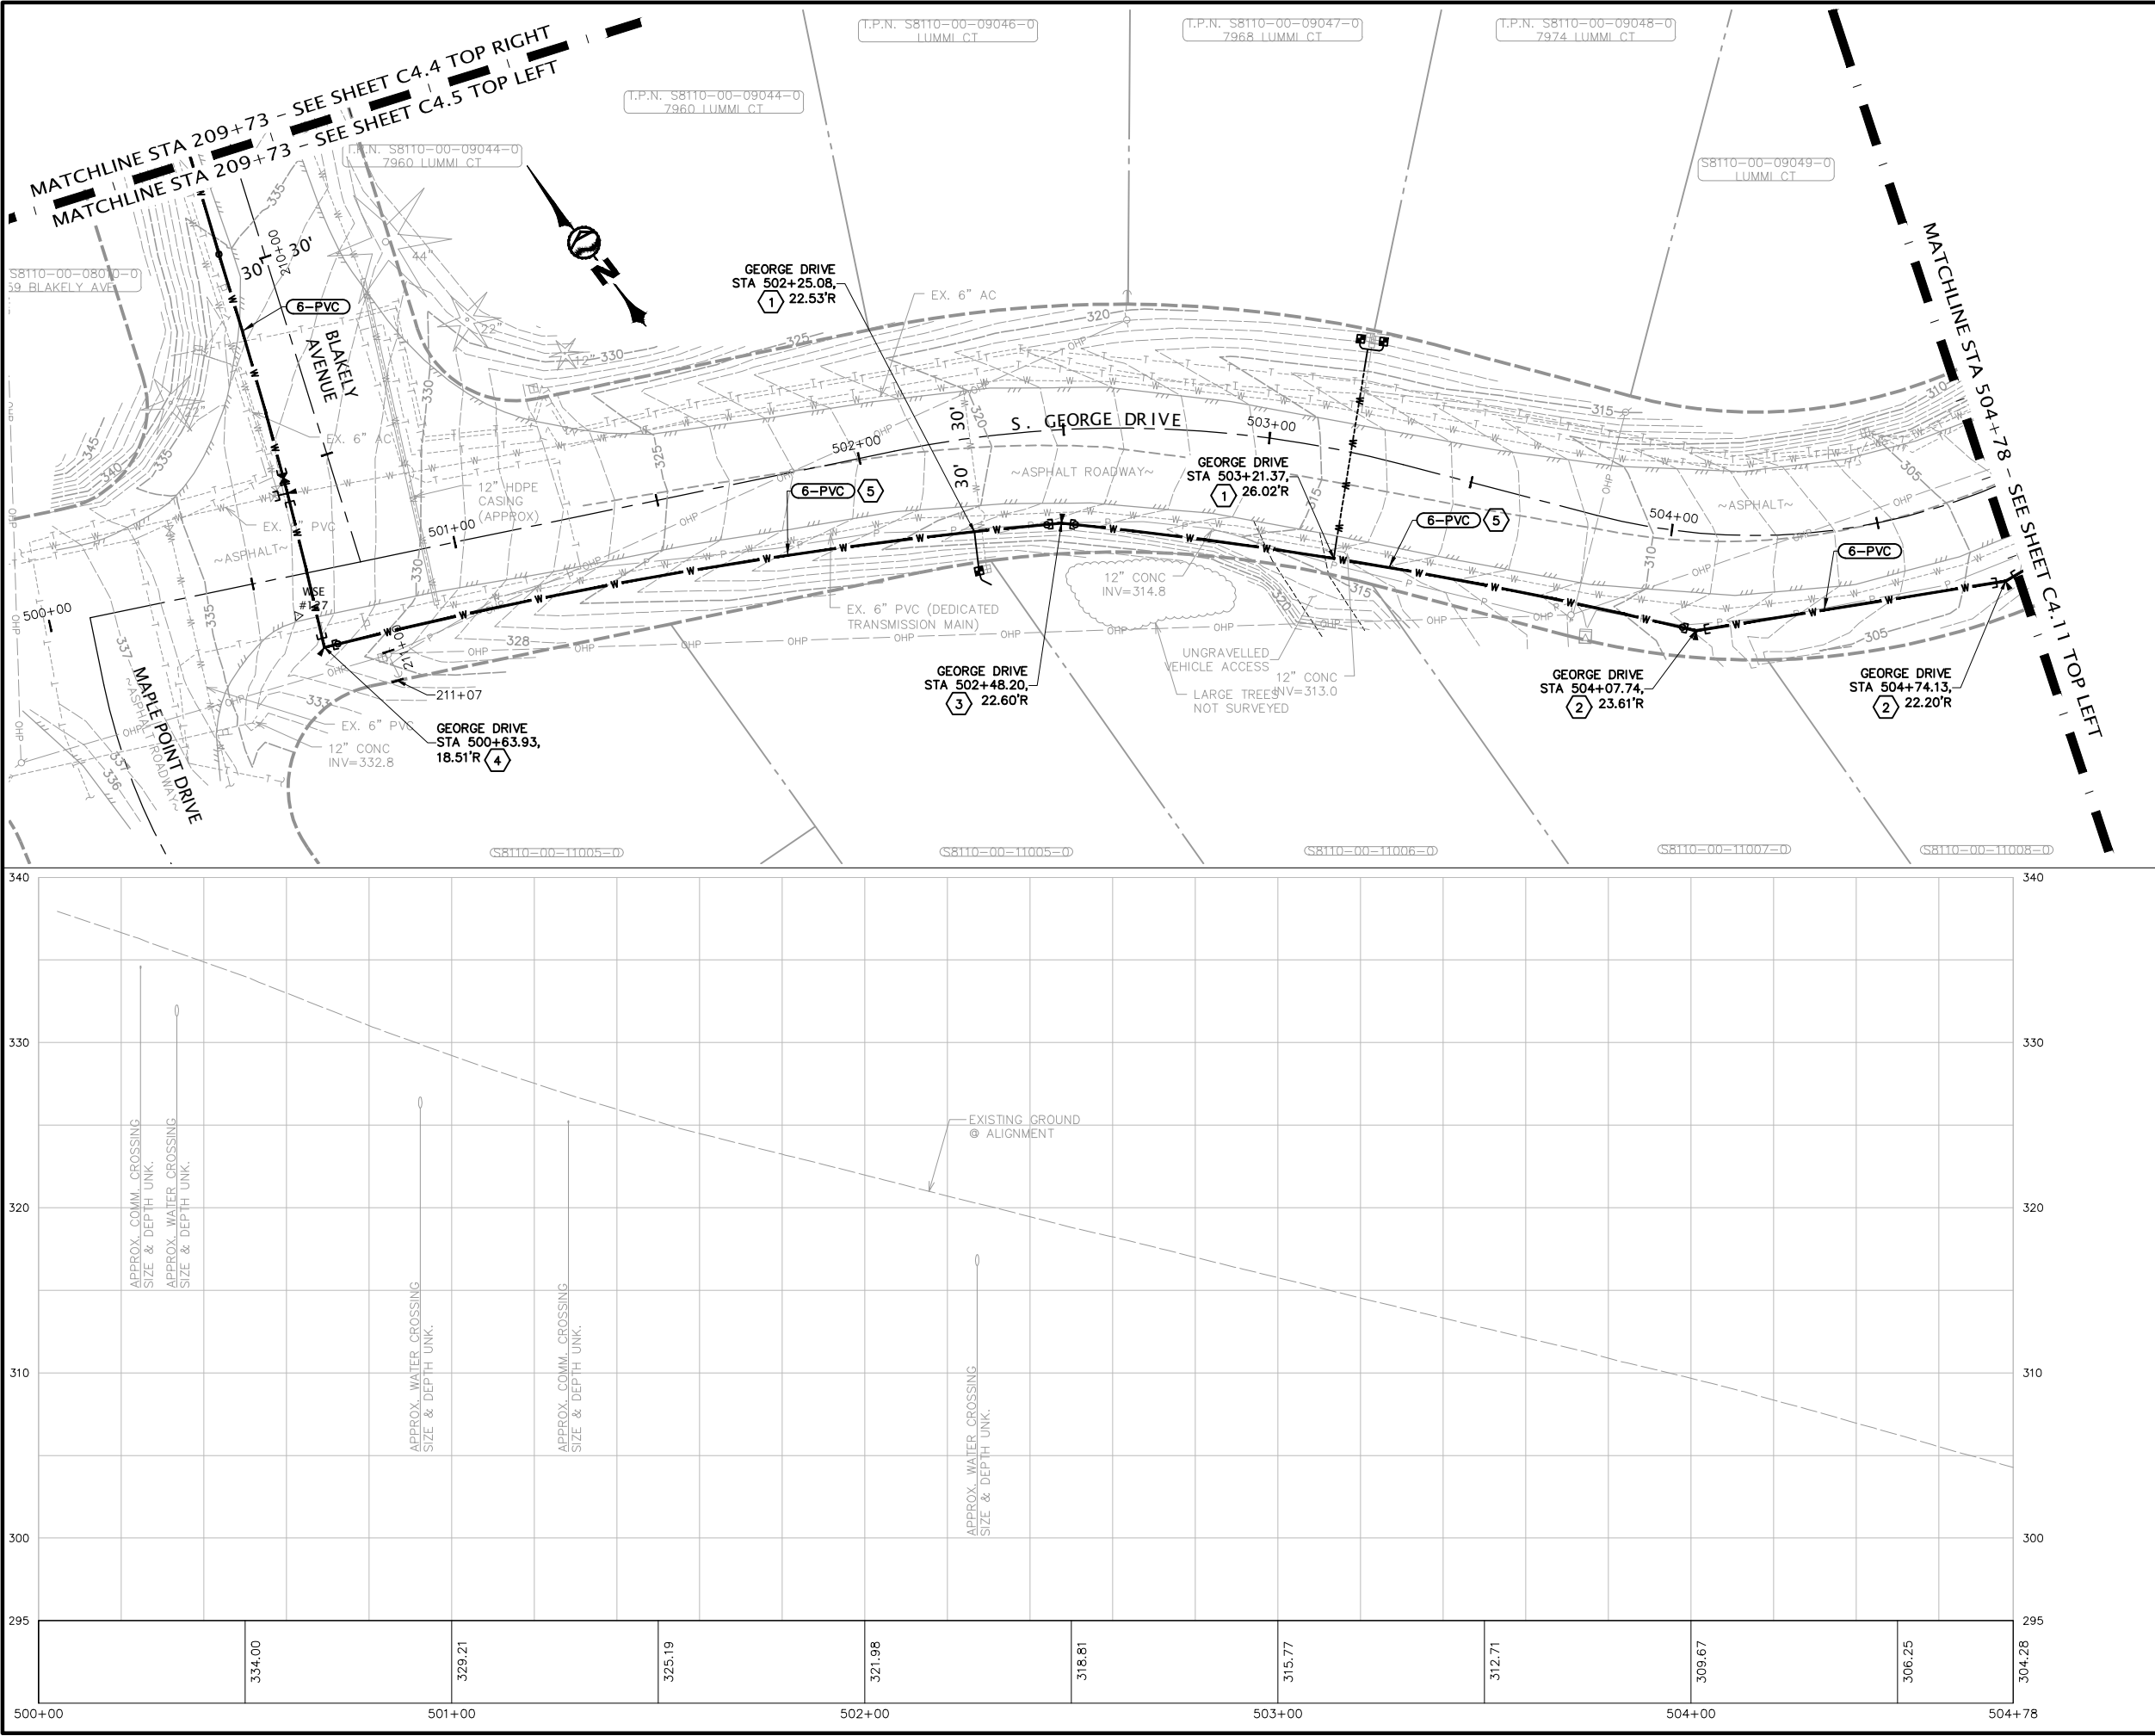

NO.

REVISIONS

BY

DATE

KEYED NOTES

1 = SERVICE CONNECTION PER $\frac{X}{X}$

2 = 6" 22-1/2" BEND MxMJ, THRUST BLOCKING

3 = 6" 11-1/4" BEND MxMJ, THRUST BLOCKING, RESTRAINED JOINTS EACH WAY

4 = 6" 90° BEND MxMJ, THRUST BLOCKING

5 = MIN 175' RADIUS

DESIGNED BY

CDS/MXW

DRAWN BY

JGS

CHECKED BY

MMM

SCATCHET HEAD WATER DISTRICT

WASHINGTON

DATE

12-8-22

SCALE

AS SHOWN

JOB NUMBER

2022-013

SHEET

C4.10

PAGE

X OF X

KEY MAP

NOT TO SCALE

LEGEND

PLAN VIEW, THIS SHEET

20 0 20 40

SCALE HORIZONTAL SCALE FEET

811 Call 811

two business days before you dig

PRELIMINARY

WILSON

ENGINEERING

WILSONENGINEERING.COM

PRELIMINARY

DESIGNED BY

CDS/MXW

DRAWN BY

JGS

CHECKED BY

MMM

SCATCHET HEAD WATER DISTRICT

WASHINGTON

DATE

12-8-22

SCALE

AS SHOWN

JOB NUMBER

2022-013

SHEET

C4.10

PAGE


X OF X

WATER SYSTEM IMPROVEMENTS

WHIDBEY ISLAND

S. GEORGE DRIVE - STA 500+00 TO STA 504+78

PLOT SETTINGS: AutoCAD PDF (General Documentation).pc3, ANSI full bleed B (17.00 x 11.00 inches), Portrait, 1:2, WE APWA_UNSCREENED.ctb
W:\2022\2022-013 SCATCHET HEAD WD WATER IMPROVEMENTS.MMM\DWG_V2019_NAD83_NAD88\2022_013 C4-10-C4-17 GEORGE PLAN & PROFILES.DWG - 12/8/2022 2:01 PM - Jeff Smith

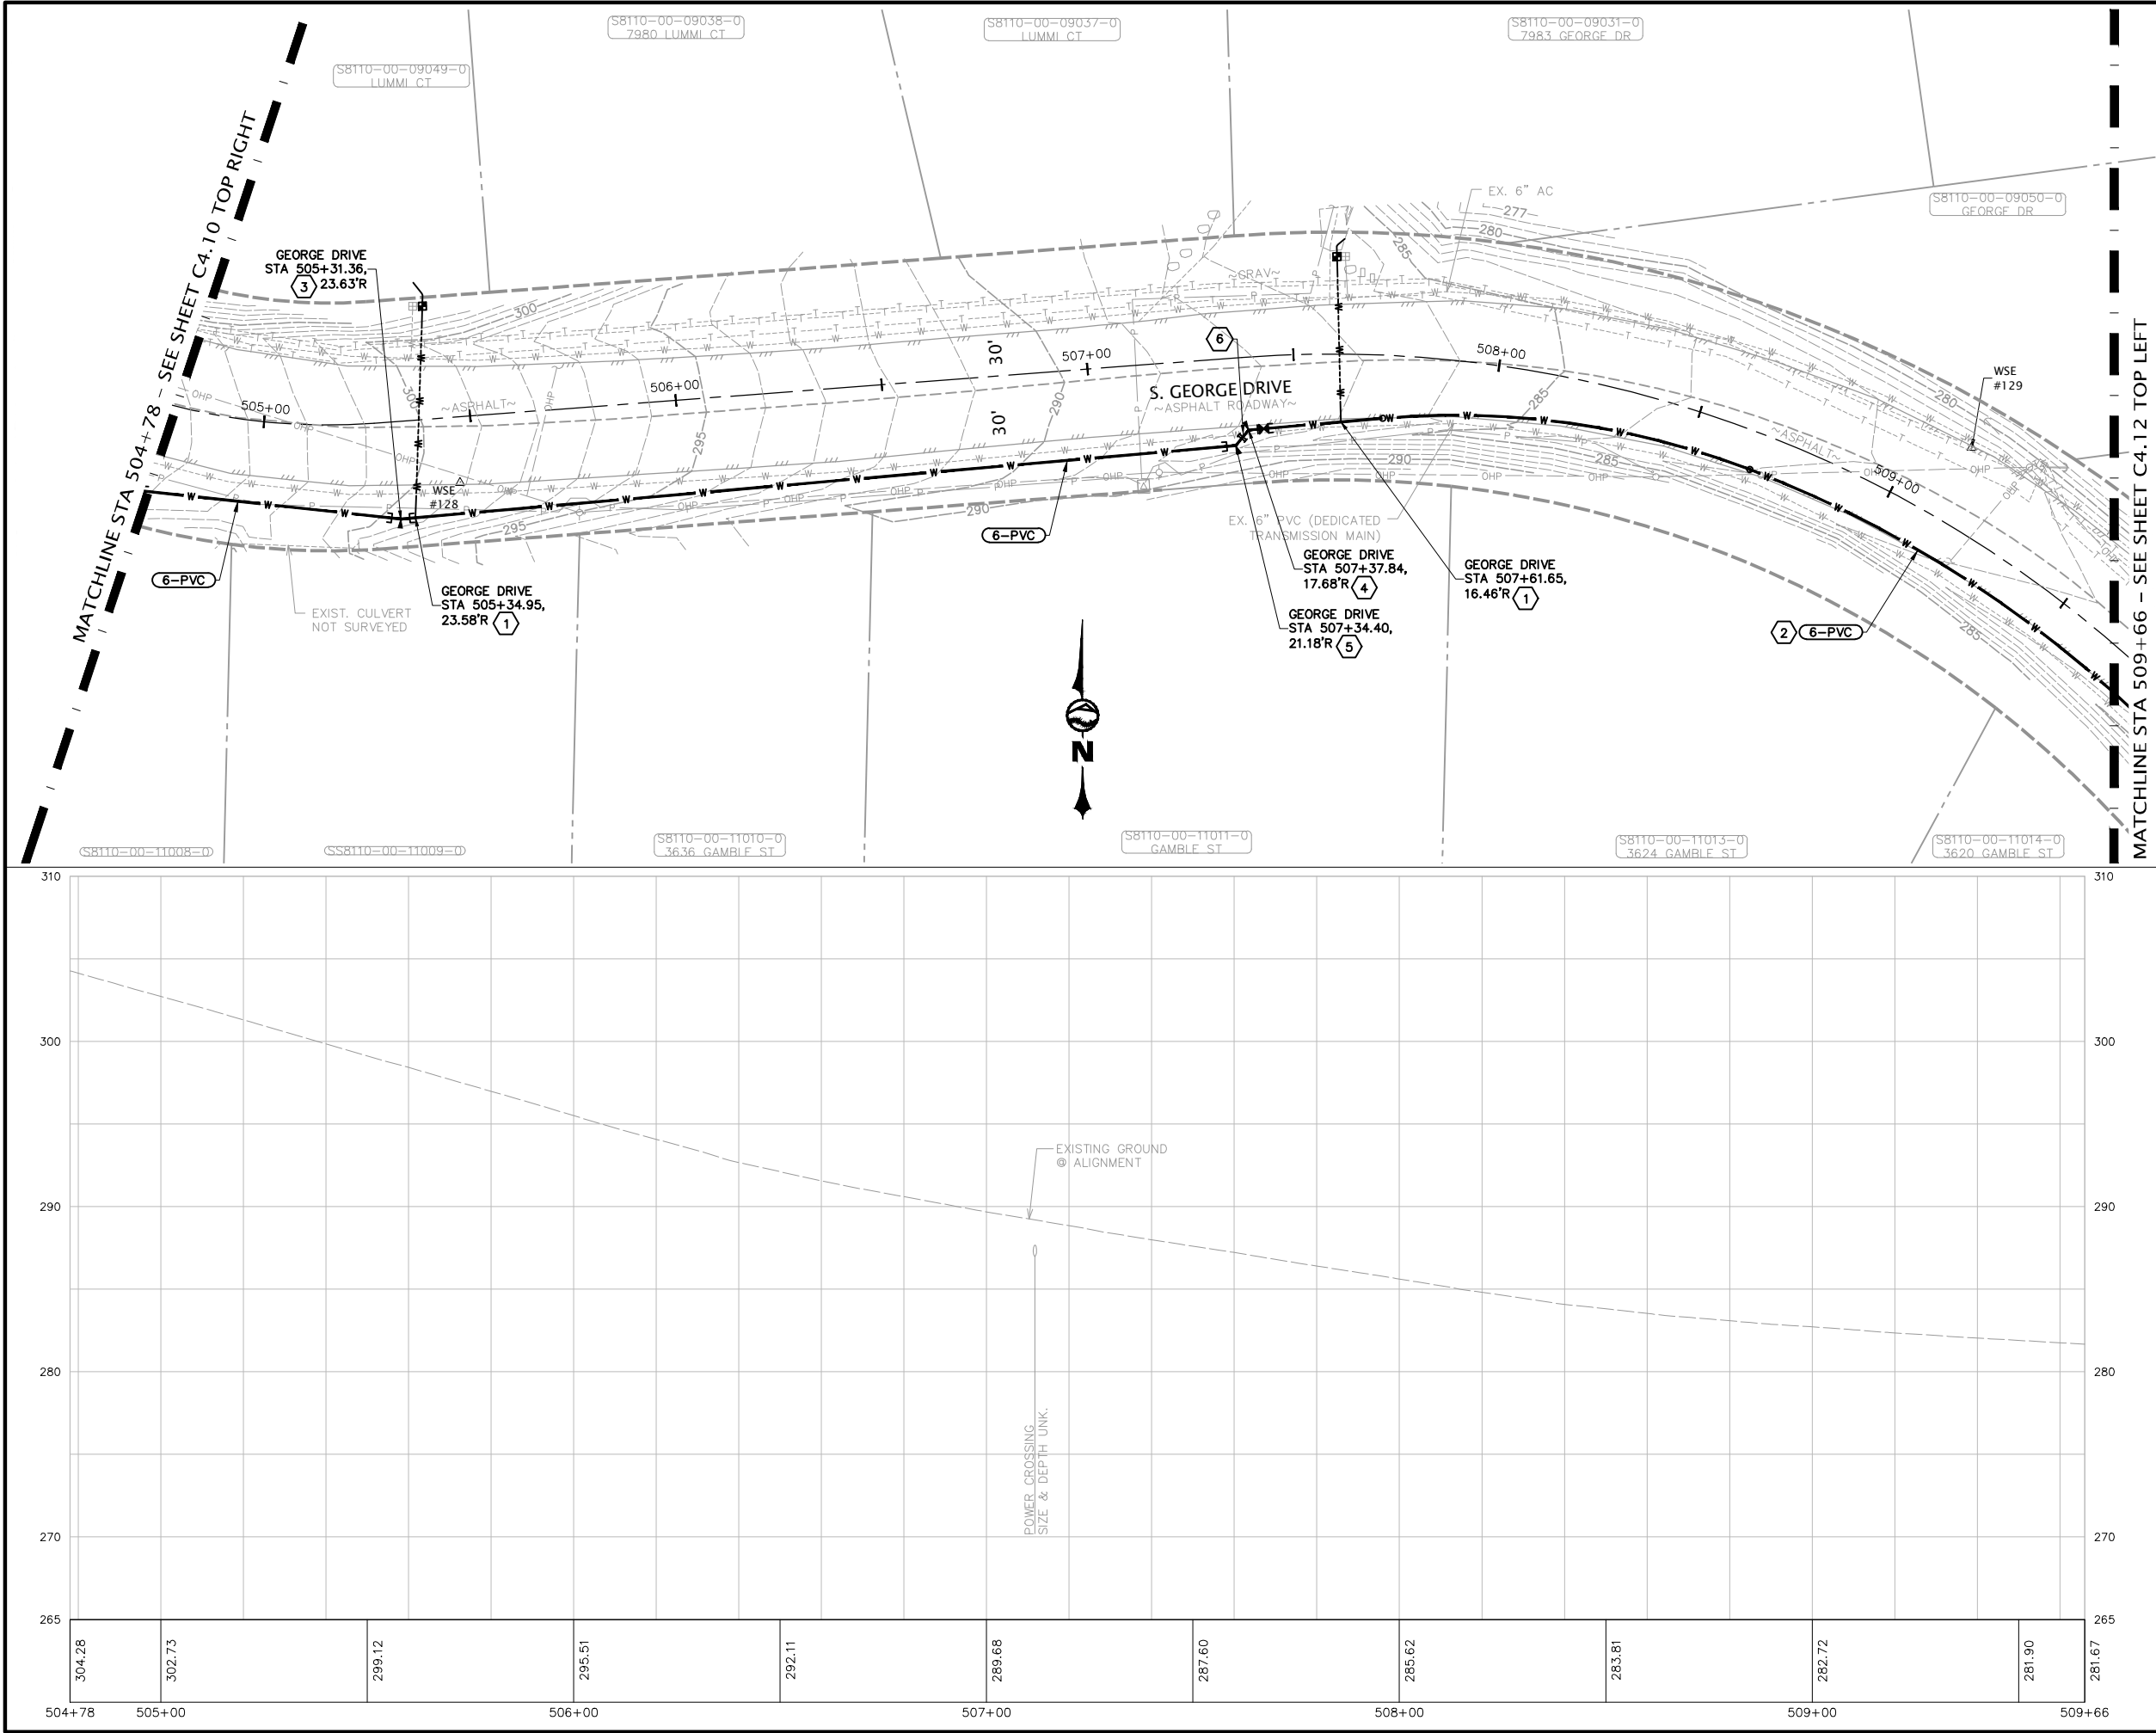

NO.	REVISIONS	BY	DATE
KEYED NOTES			
1	= SERVICE CONNECTION PER $\frac{X}{X}$		
2	= MIN 175' RADIUS		
3	= 6" 11-1/4" BEND MJxMJ, THRUST BLOCKING		
4	= 6" 45" BEND MJxFL, 6" GV FLxMJ, THRUST BLOCKING		
5	= 6" 45" BEND MJxMJ, THRUST BLOCKING		
6	= NOTE CROSSING OF EX. TRANSMISSION MAIN TO REMAIN ACTIVE DURING & AFTER CONSTRUCTION		

DESIGNED BY	CDS/MKW	DRAWN BY	JGS	CHECKED BY	MMM
WASHINGTON					

SHEET	DATE	SCALE	JOB NUMBER
C4.11	12-8-22	AS SHOWN	2022-013

PAGE	OF
X	X

20 0 20 40
SCALE HORIZONTAL SCALE FEET

811 Call 811
two business days
before you dig

PRELIMINARY

KEY MAP NOT TO SCALE
LEGEND PLAN VIEW, THIS SHEET
BLAKELY AVENUE GUEMES AVENUE S. GEORGE DRIVE FIDALGO DRIVE MITFORD LANE DRIFTWOOD DRIVE



WILSON ENGINEERING	
WILSONENGINEERING.COM	

SCATCHET HEAD WATER DISTRICT	
WATER SYSTEM IMPROVEMENTS	
WHIDBEY ISLAND	
S. GEORGE DRIVE - STA 504+78 TO STA 509+66	


SHEET	DATE	SCALE	JOB NUMBER
C4.11	12-8-22	AS SHOWN	2022-013

PAGE	OF
X	X

PLOT SETTINGS: AutoCAD PDF (General Documentation).pc3, ANSI full bleed B (17.00 x 11.00 inches), Portrait, 1:2, WE APWA_UNSCREENED.ctb
W:\2022\2022-013 SCATCHET HEAD WD WATER IMPROVEMENTS.MMM\DWG_V2019_NAD83_NAD88\2022_2022-013 C4.10-C4.17 GEORGE PLAN & PROFILES.DWG - 12/8/2022 2:01 PM - Jeff Smith

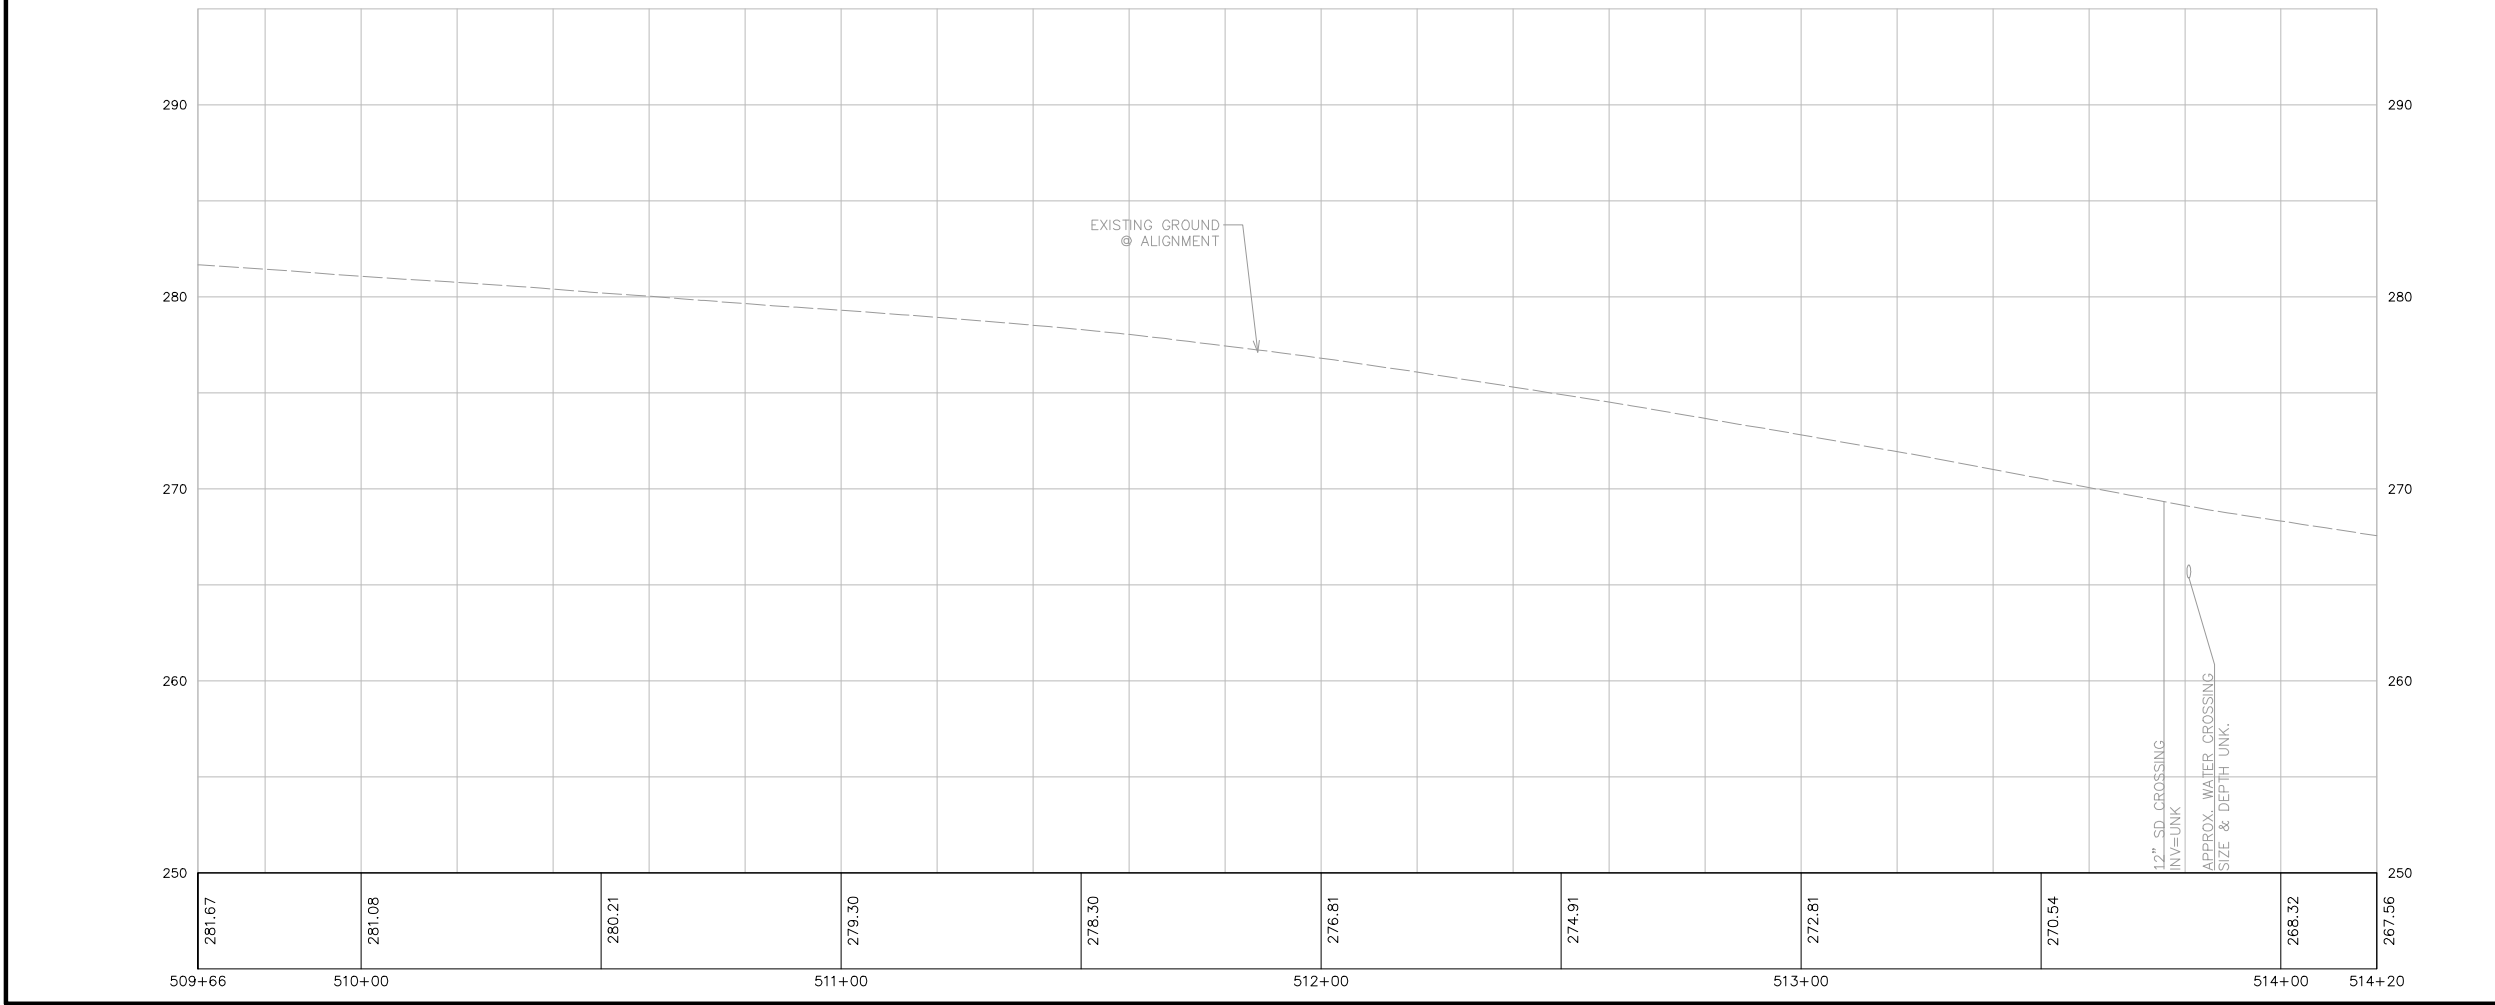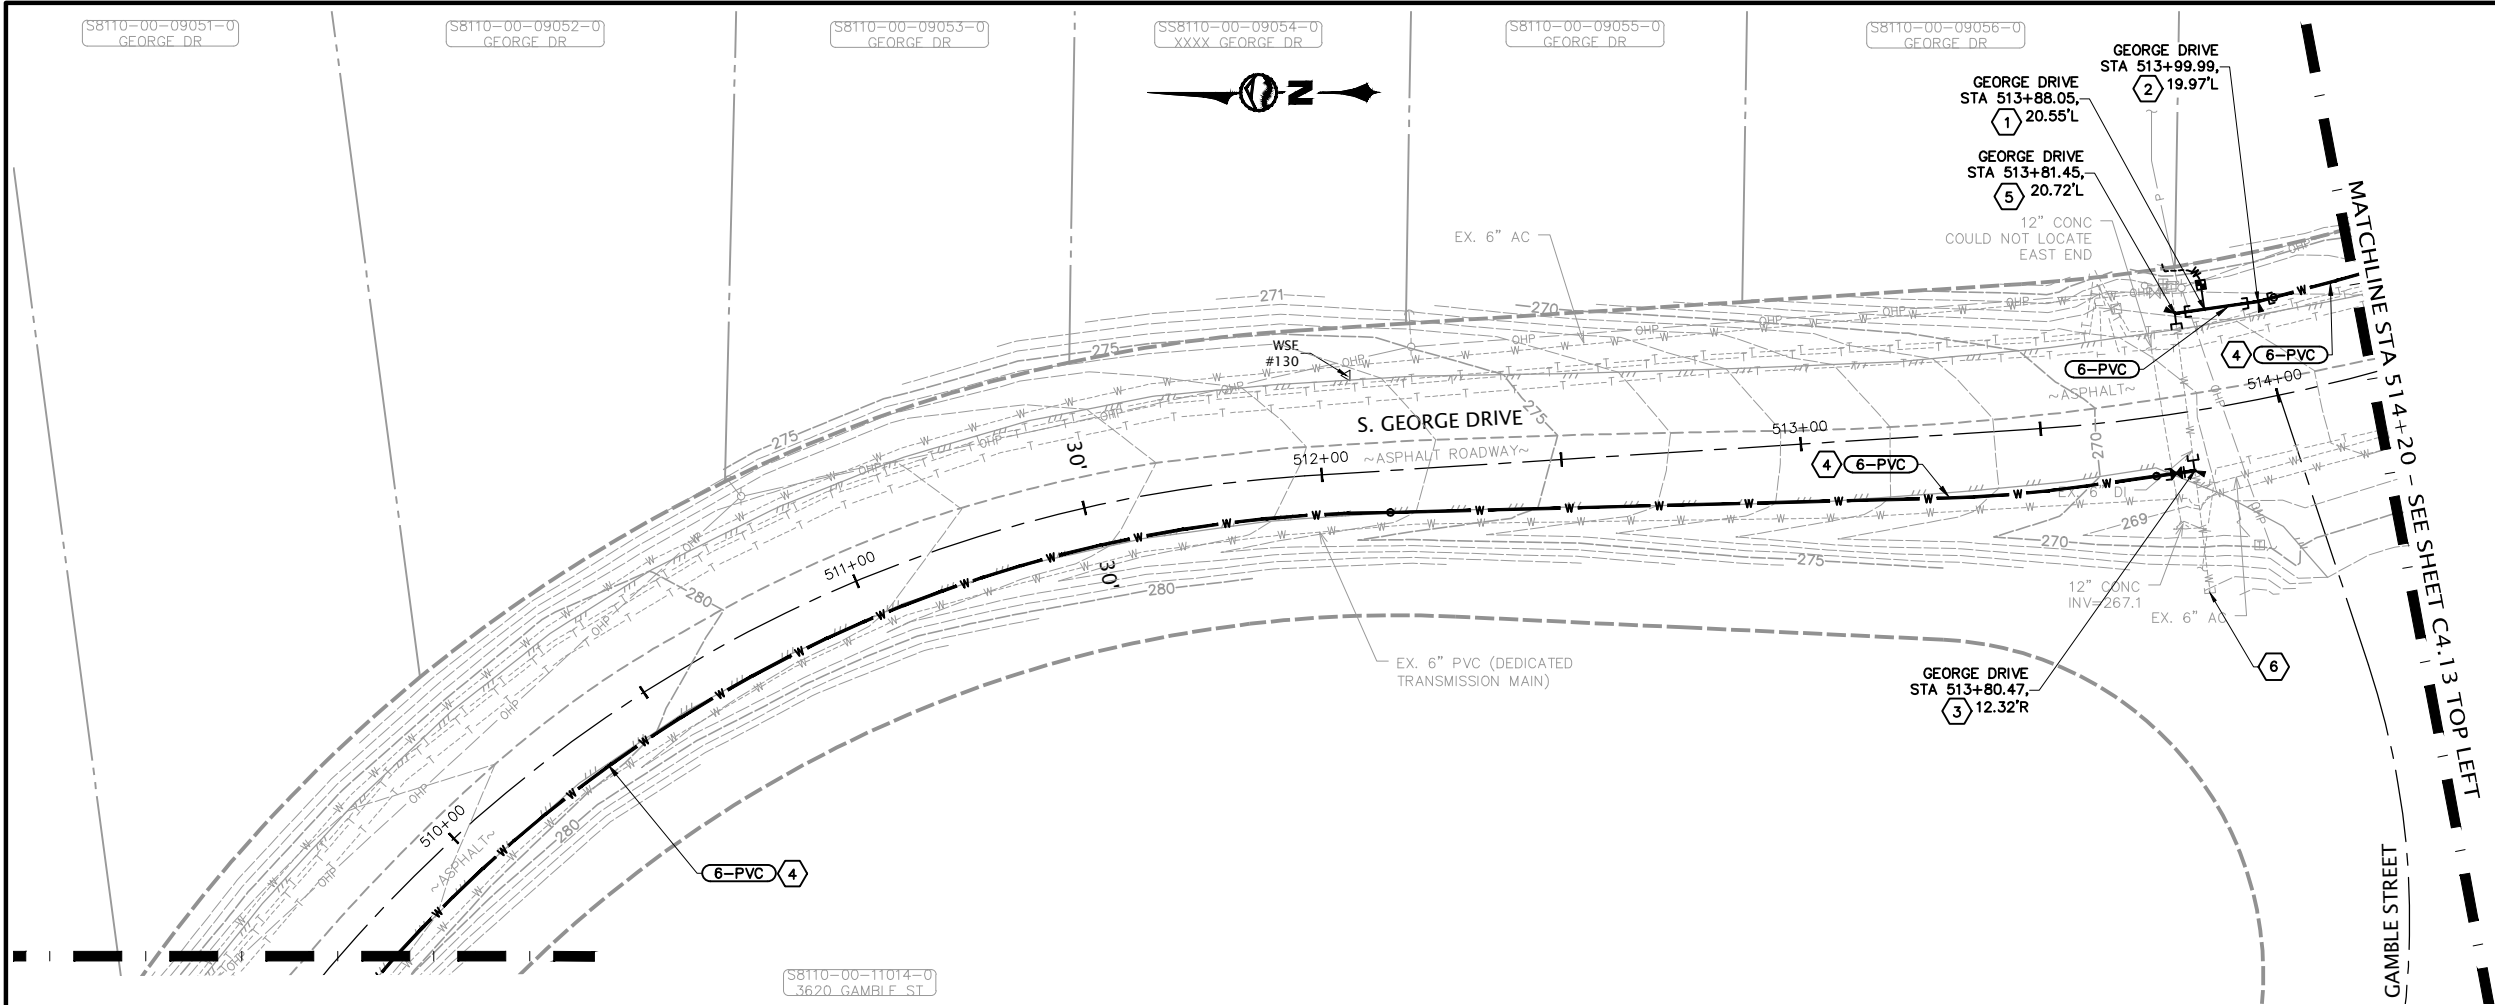


NO.	REVISIONS	BY	DATE
KEYED NOTES			
1	= SERVICE CONNECTION PER $\frac{X}{X}$		
2	= 6" BEND AS REQ'D MxMJ, THRUST BLOCKING		
3	= CONNECT TO EX. 6" DI 6" 90° BEND MxFL, 6" GV FLxMJ, THRUST BLOCKING		
4	= MIN 175' RADIUS		
5	= CONNECT TO EX. 6" DI 6" 90° BEND MxMJ, THRUST BLOCKING		
6	= EX. CAPPED & ABANDONED		

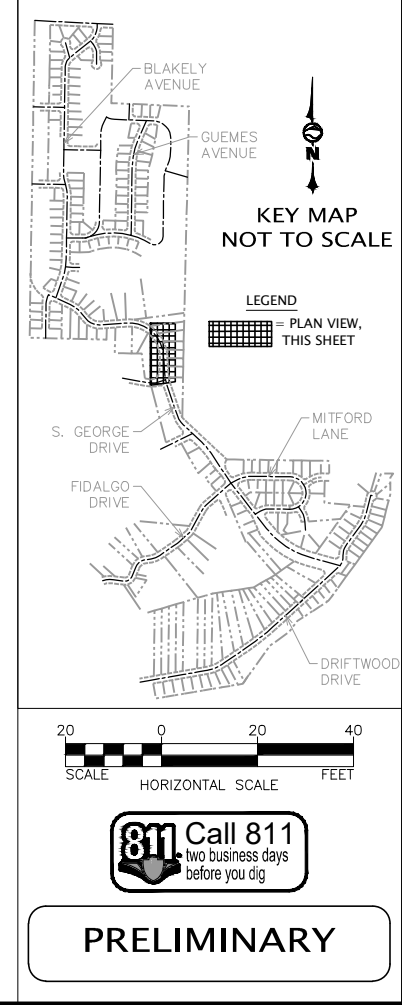

WILSON ENGINEERING WILSONENGINEERING.COM	
PRELIMINARY	
DESIGNED BY CDS/MKW	DRAWN BY JGS
CHECKED BY MMM	
SCATCHET HEAD WATER DISTRICT	
WASHINGTON	
WATER SYSTEM IMPROVEMENTS	
S. GEORGE DRIVE - STA 509+66 TO STA 514+20	
SHEET C4.12	DATE 12-8-22
PAGE X OF X	SCALE AS SHOWN
	JOB NUMBER 2022-013

PLOT SETTINGS: AutoCAD PDF (General Documentation).pc3, ANSI full bleed B (17.00 x 11.00 inches), Portrait, 1:2, WE APWA_UNSCREENED.ctb
W:\2022-013 SCATCHET HEAD WD WATER IMPROVEMENTS.MMM\DWG_V2019_NAD83_NAD88\2022_013 C4.10-C4.17 GEORGE PLAN & PROFILES.DWG - 12/8/2022 2:02 PM - Jeff Smith

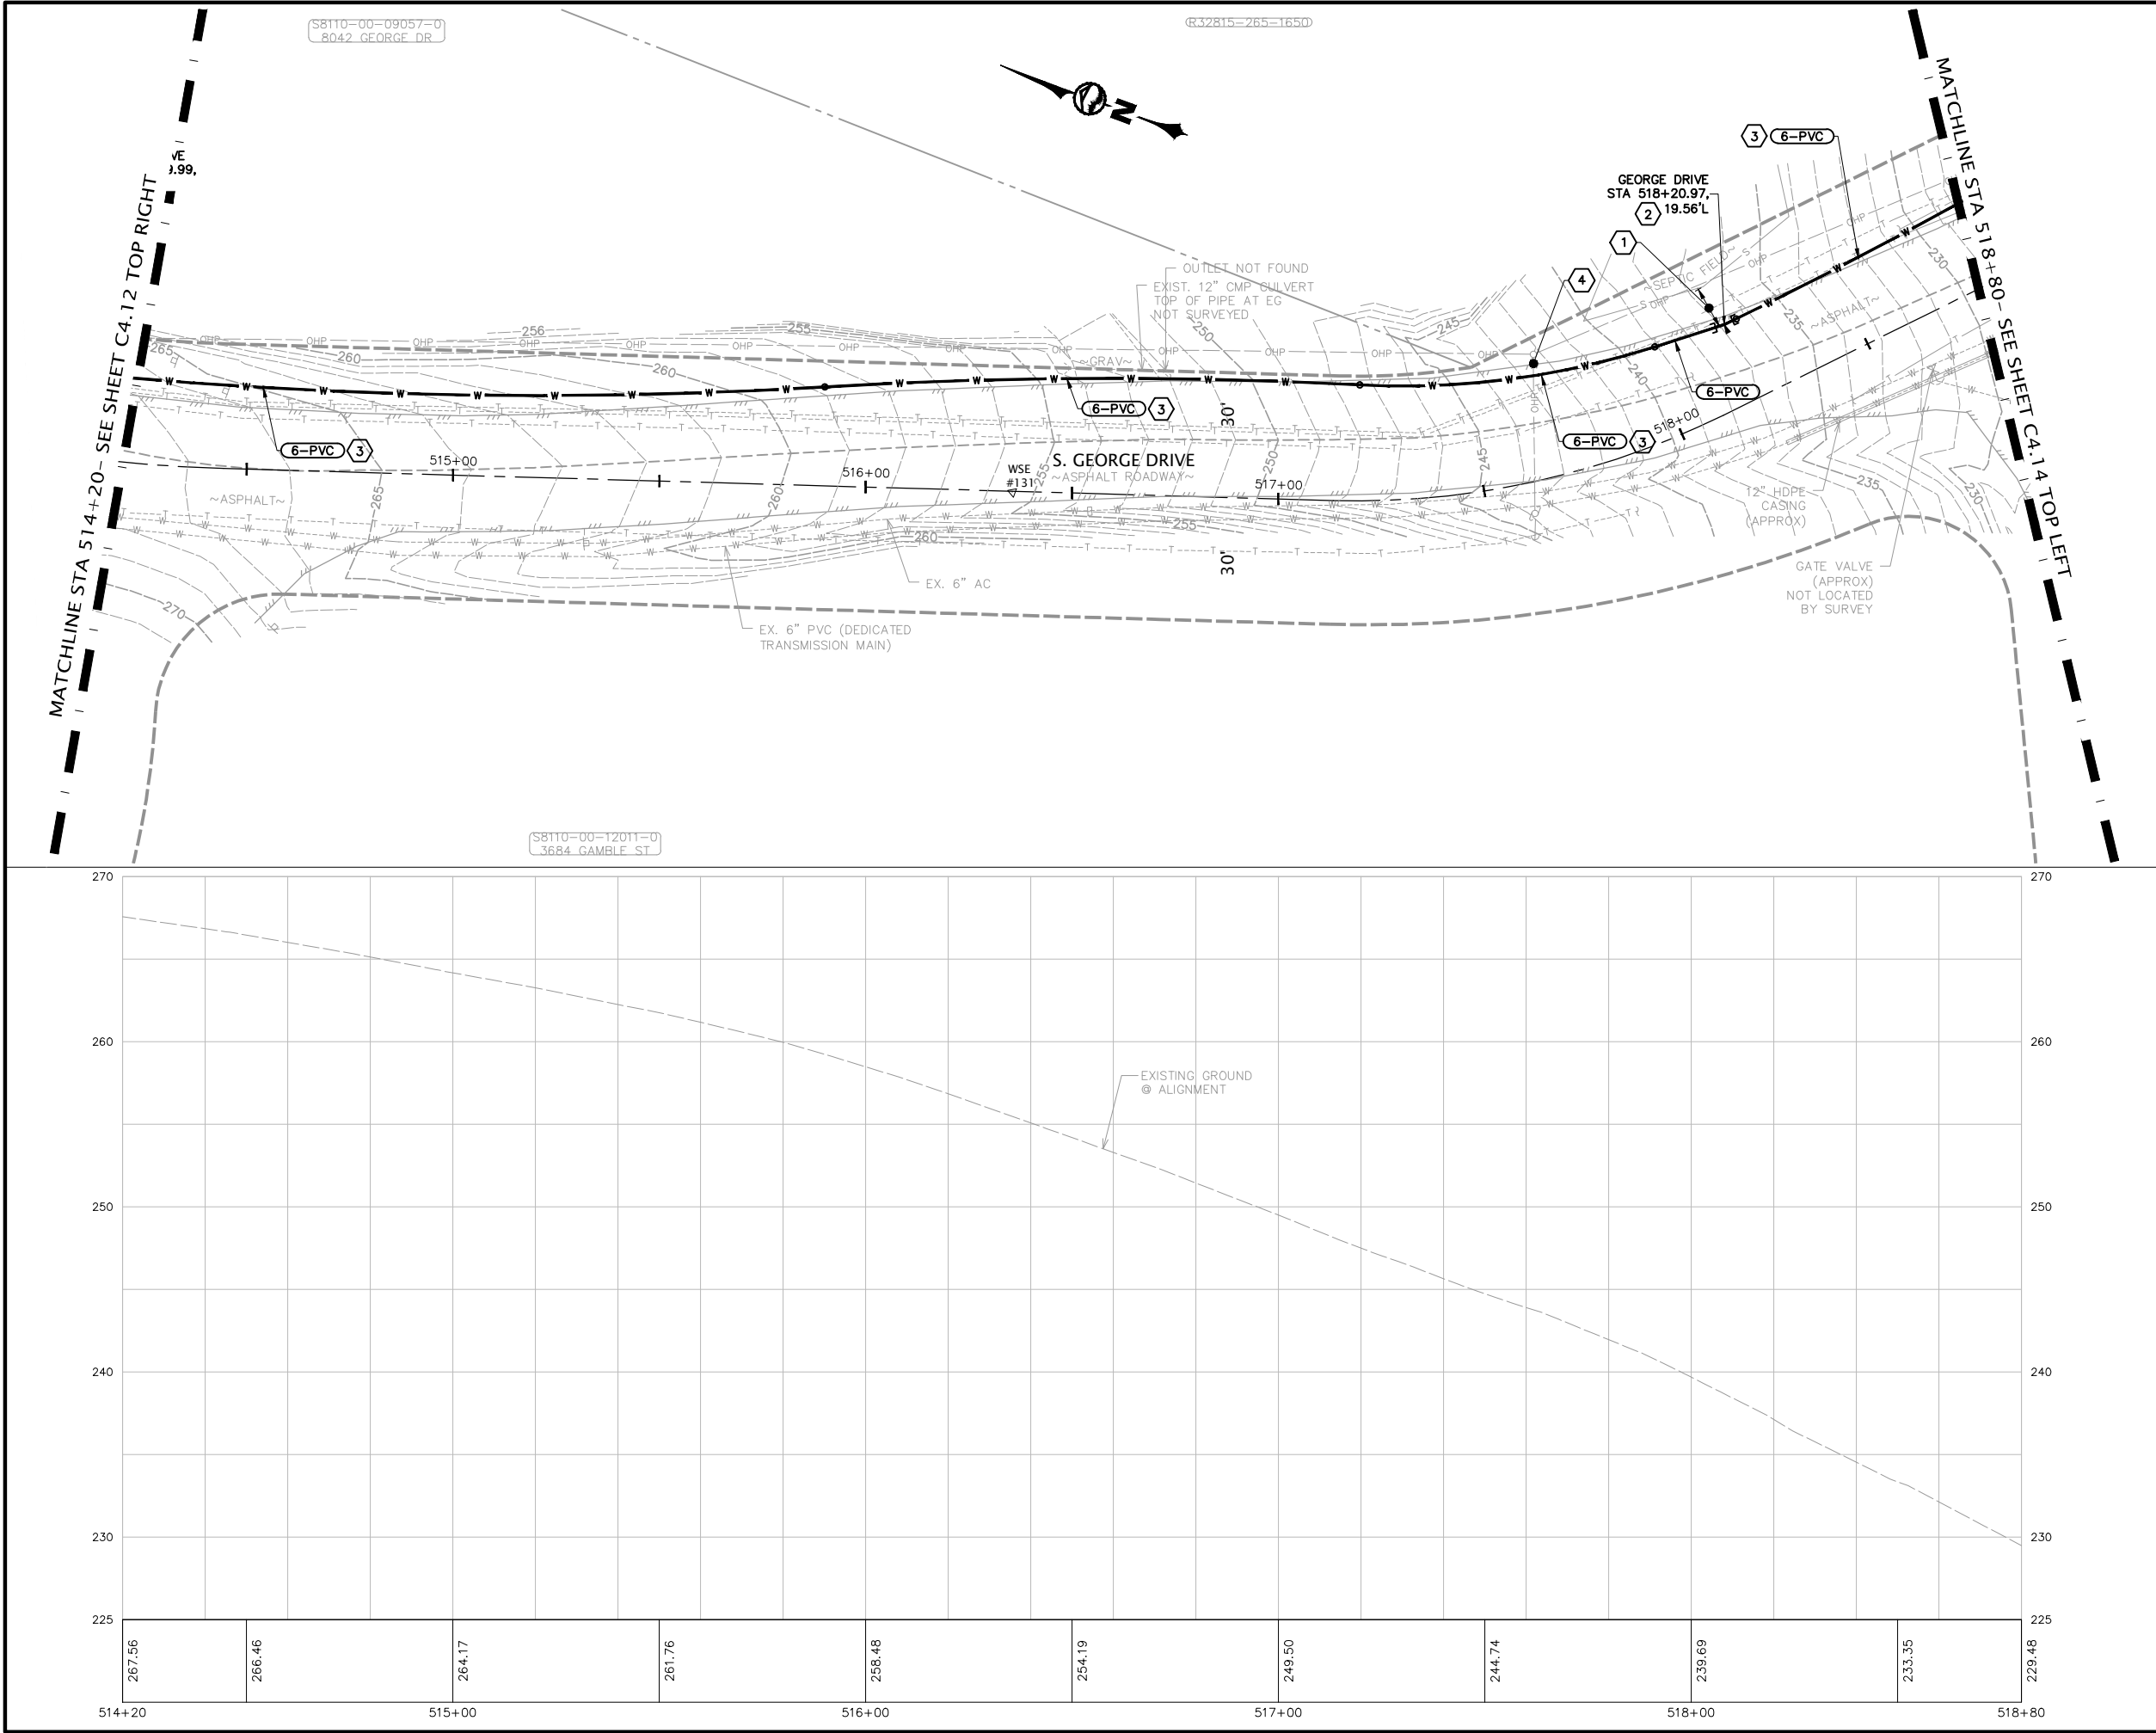

NO.	REVISIONS	BY	DATE

KEYED NOTES

- 1 = MAINTAIN MIN. 10' SEPARATION FROM SEPTIC FIELD
- 2 = 6" BEND AS REQ'D MxMJ, THRUST BLOCKING
- 3 = MIN 175' RADIUS
- 4 = MAINTAIN MIN. 3' SEPARATION FROM UTILITY POLE

KEY MAP
NOT TO SCALE

LEGEND
PLAN VIEW, THIS SHEET

SCALE
20 0 20 40
SCALE HORIZONTAL SCALE FEET

811 Call 811
two business days before you dig

PRELIMINARY

SHEET		DATE	SCALE		JOB NUMBER	
C4.13		12-8-22	AS SHOWN		2022-013	
PAGE		OF				
X		X				

SCATCHET HEAD WATER DISTRICT



WATER SYSTEM IMPROVEMENTS

S. GEORGE DRIVE - STA 514+20 TO STA 518+80

WILSON ENGINEERING
WILSONENGINEERING.COM

PRELIMINARY

PLOT SETTINGS: AutoCAD PDF (General Documentation).pc3, ANSI full bleed B (17.00 x 11.00 inches), Portrait, 1:2, WE APWA_UNSCREENED.ctb
W:\2022-2023-013 SCATCHET HEAD WD WATER IMPROVEMENTS.MMM\DWG_V2019_NAD83_NAD88\2022_2022-013 C4-10-C4-17 GEORGE PLAN & PROFILES.DWG - 12/8/2022 2:02 PM - Jeff Smith

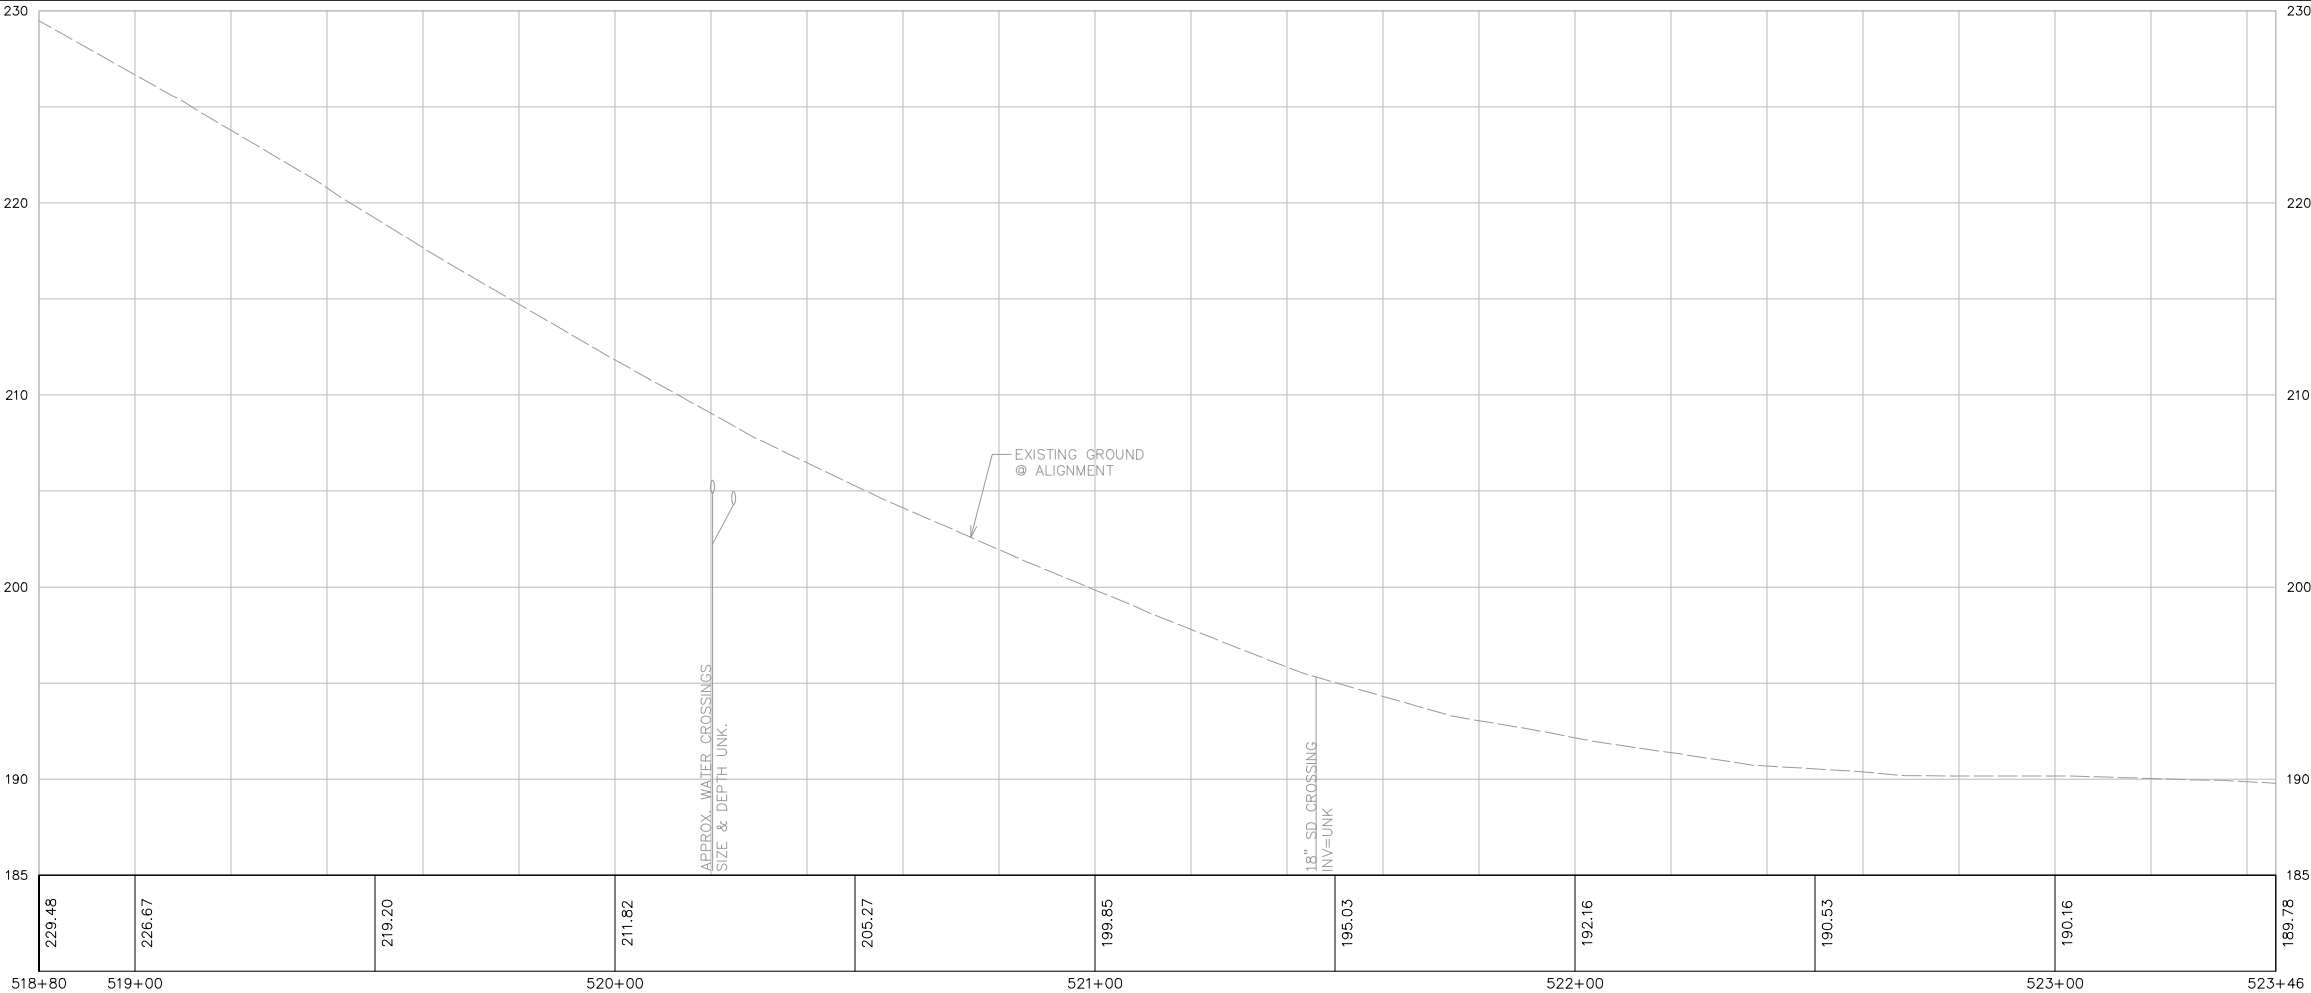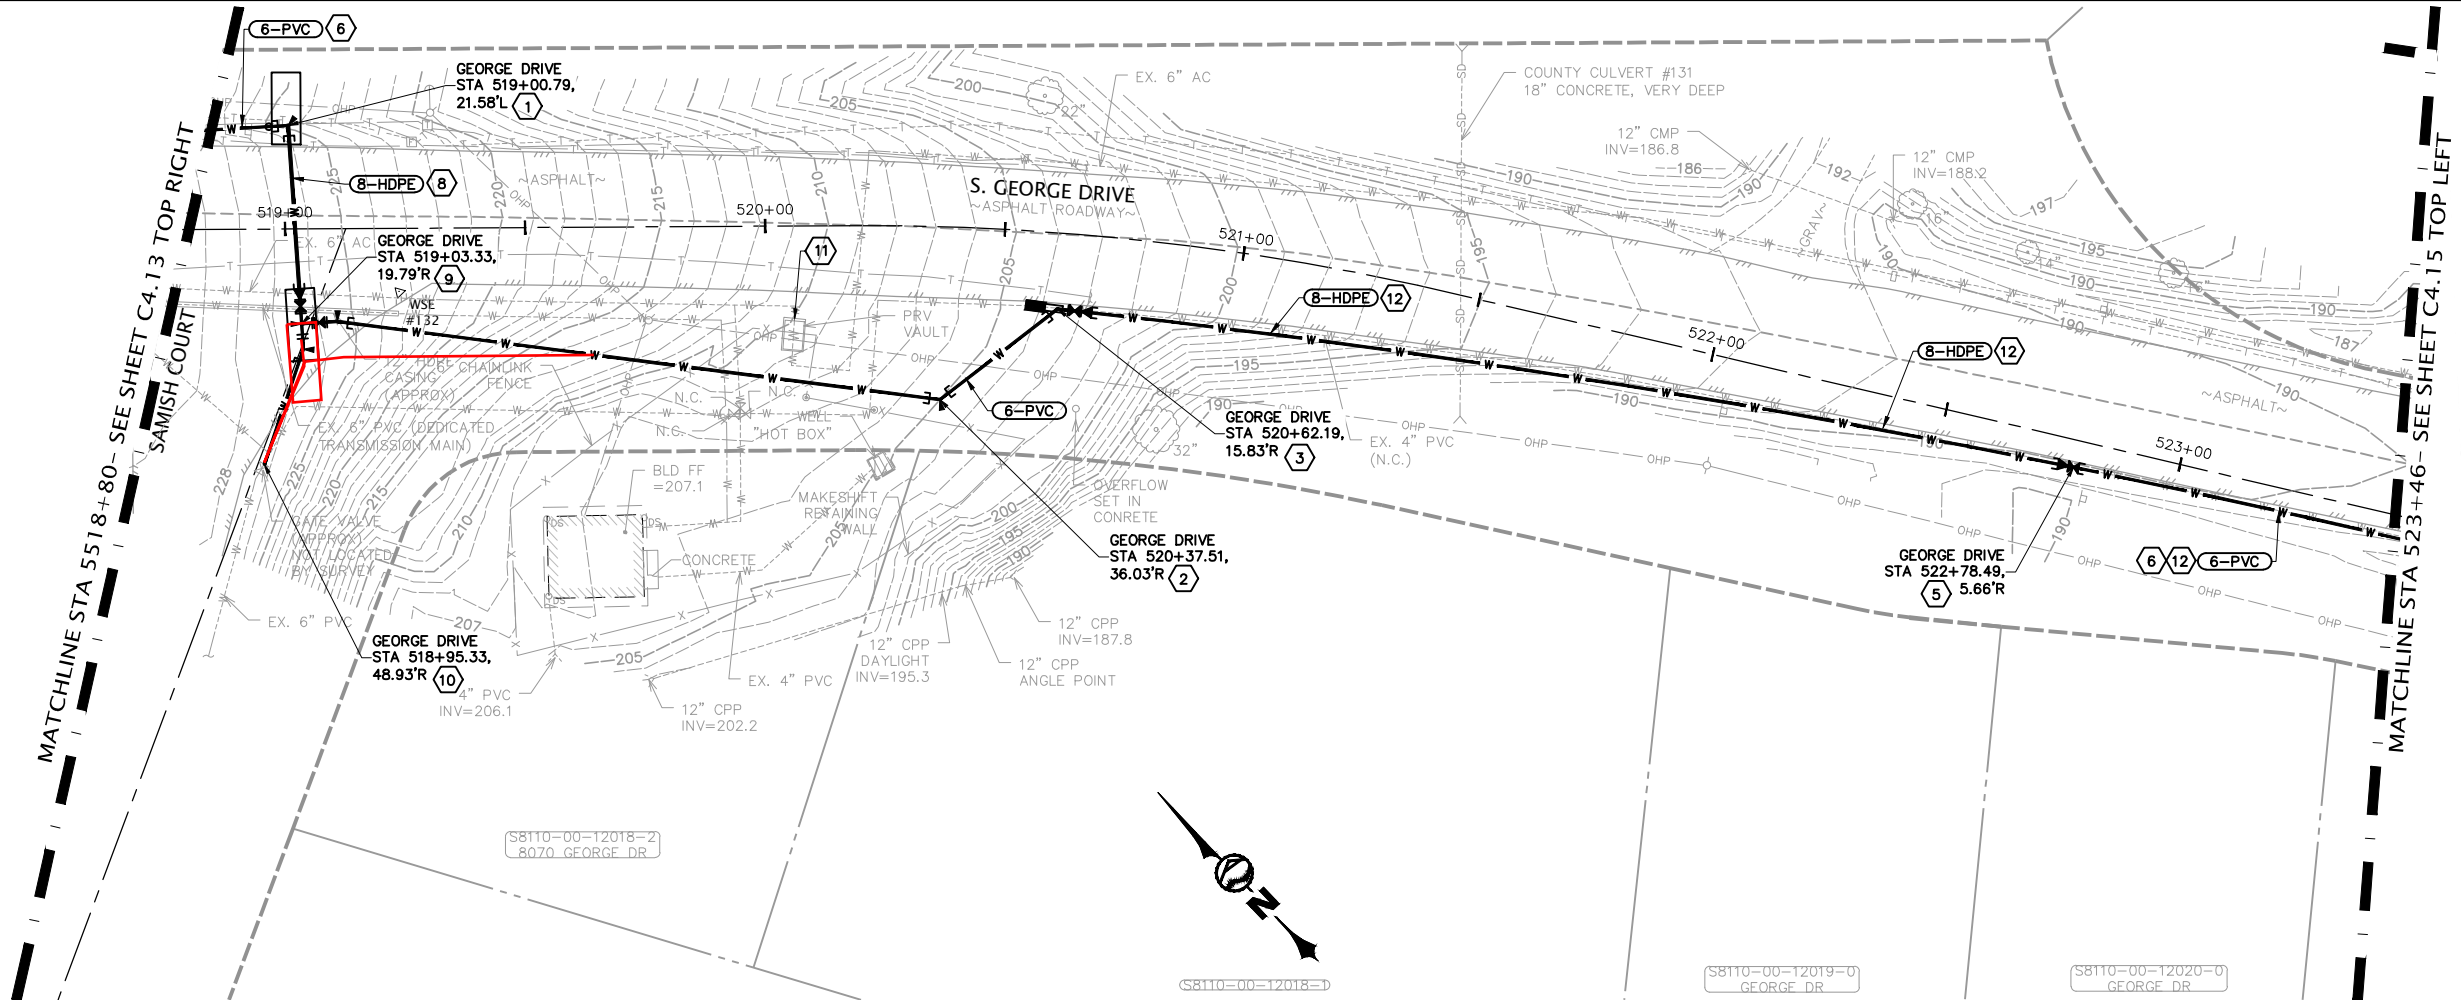

NO.	REVISIONS	BY	DATE
1	KEYED NOTES		
2			
3			
4			
5			
6			
7			
8			
9			
10			
11			
12			

KEYED NOTES

- 1 = 6"x8" 90° BEND MJxMJ, THRUST BLOCKING
- 2 = 6" 45° BEND MJxMJ, THRUST BLOCKING
- 3 = 6" 45° BEND MJxFL, 6" GV FLxFL FOR ISOLATION OF FUTURE CULVERT REPLACEMENT, 6"x8" REDUCER FLxMJ, HDPE MJ ADAPTER, REVERSE THRUST BLOCK PER
- 4 = 8" BEND AS REQ'D MJxMJ, THRUST BLOCKING
- 5 = HDPE MJ ADAPTER, 8"x6" REDUCER MJxFL, 6" GV FLxMJ FOR ISOLATION OF FUTURE CULVERT REPLACEMENT, REVERSE THRUST BLOCK PER
- 6 = 175' MIN RADIUS
- 7 = HORIZONTAL DIRECTIONAL DRILL PIT
- 8 = 8" HDPE INSTALLED BY HORIZONTAL DIRECTIONAL DRILLING, HDPE ADAPTERS & FITTINGS AS REQUIRED
- 9 = 6" TEE FLxFLxFL, 8"x6" REDUCER MJxFL, 6" GV FLxMJ, 6" GV FLxFL, (2) 11-1/4" BENDs FLxMJ, THRUST BLOCKING
- 10 = CONNECT TO EX. 6" GV
- 11 = PRV VAULT TO BE REMOVED & VOID BACKFILLED
- 12 = NEW WATER MAIN TRENCH INSTALLED IN SAME LOCATION OR ADJACENT TO EX. 4" PVC CURRENTLY ABANDONED

KEY MAP NOT TO SCALE

LEGEND

- PLAN VIEW, THIS SHEET

SCALE



20 0 20 40
SCALE HORIZONTAL SCALE FEET

811 Call 811
two business days before you dig


PRELIMINARY

WILSON ENGINEERING		WILSONENGINEERING.COM	
SCATCHET HEAD WATER DISTRICT			
WASHINGTON			
WATER SYSTEM IMPROVEMENTS			
WHIDBEY ISLAND			
S. GEORGE DRIVE - STA 518+80 TO STA 523+46			
DATE	12-8-22	SCALE	AS SHOWN
SHEET	C4.14	PAGE	X OF X
JOB NUMBER	2022-013		

PLOT SETTINGS: AutoCAD PDF (General Documentation).pc3, ANSI full bleed B (17.00 x 11.00 inches), Portrait, 1:2, WE APWA_UNSCREENED.ctb
W:\2022\2022-013 SCATCHET HEAD WD WATER IMPROVEMENTS.MMM\DWG_V2019_NAD83_NAVD88\2022_2022-013 C4.10-C4.17 GEORGE PLAN & PROFILES.DWG - 12/8/2022 2:03 PM - Jeff Smith

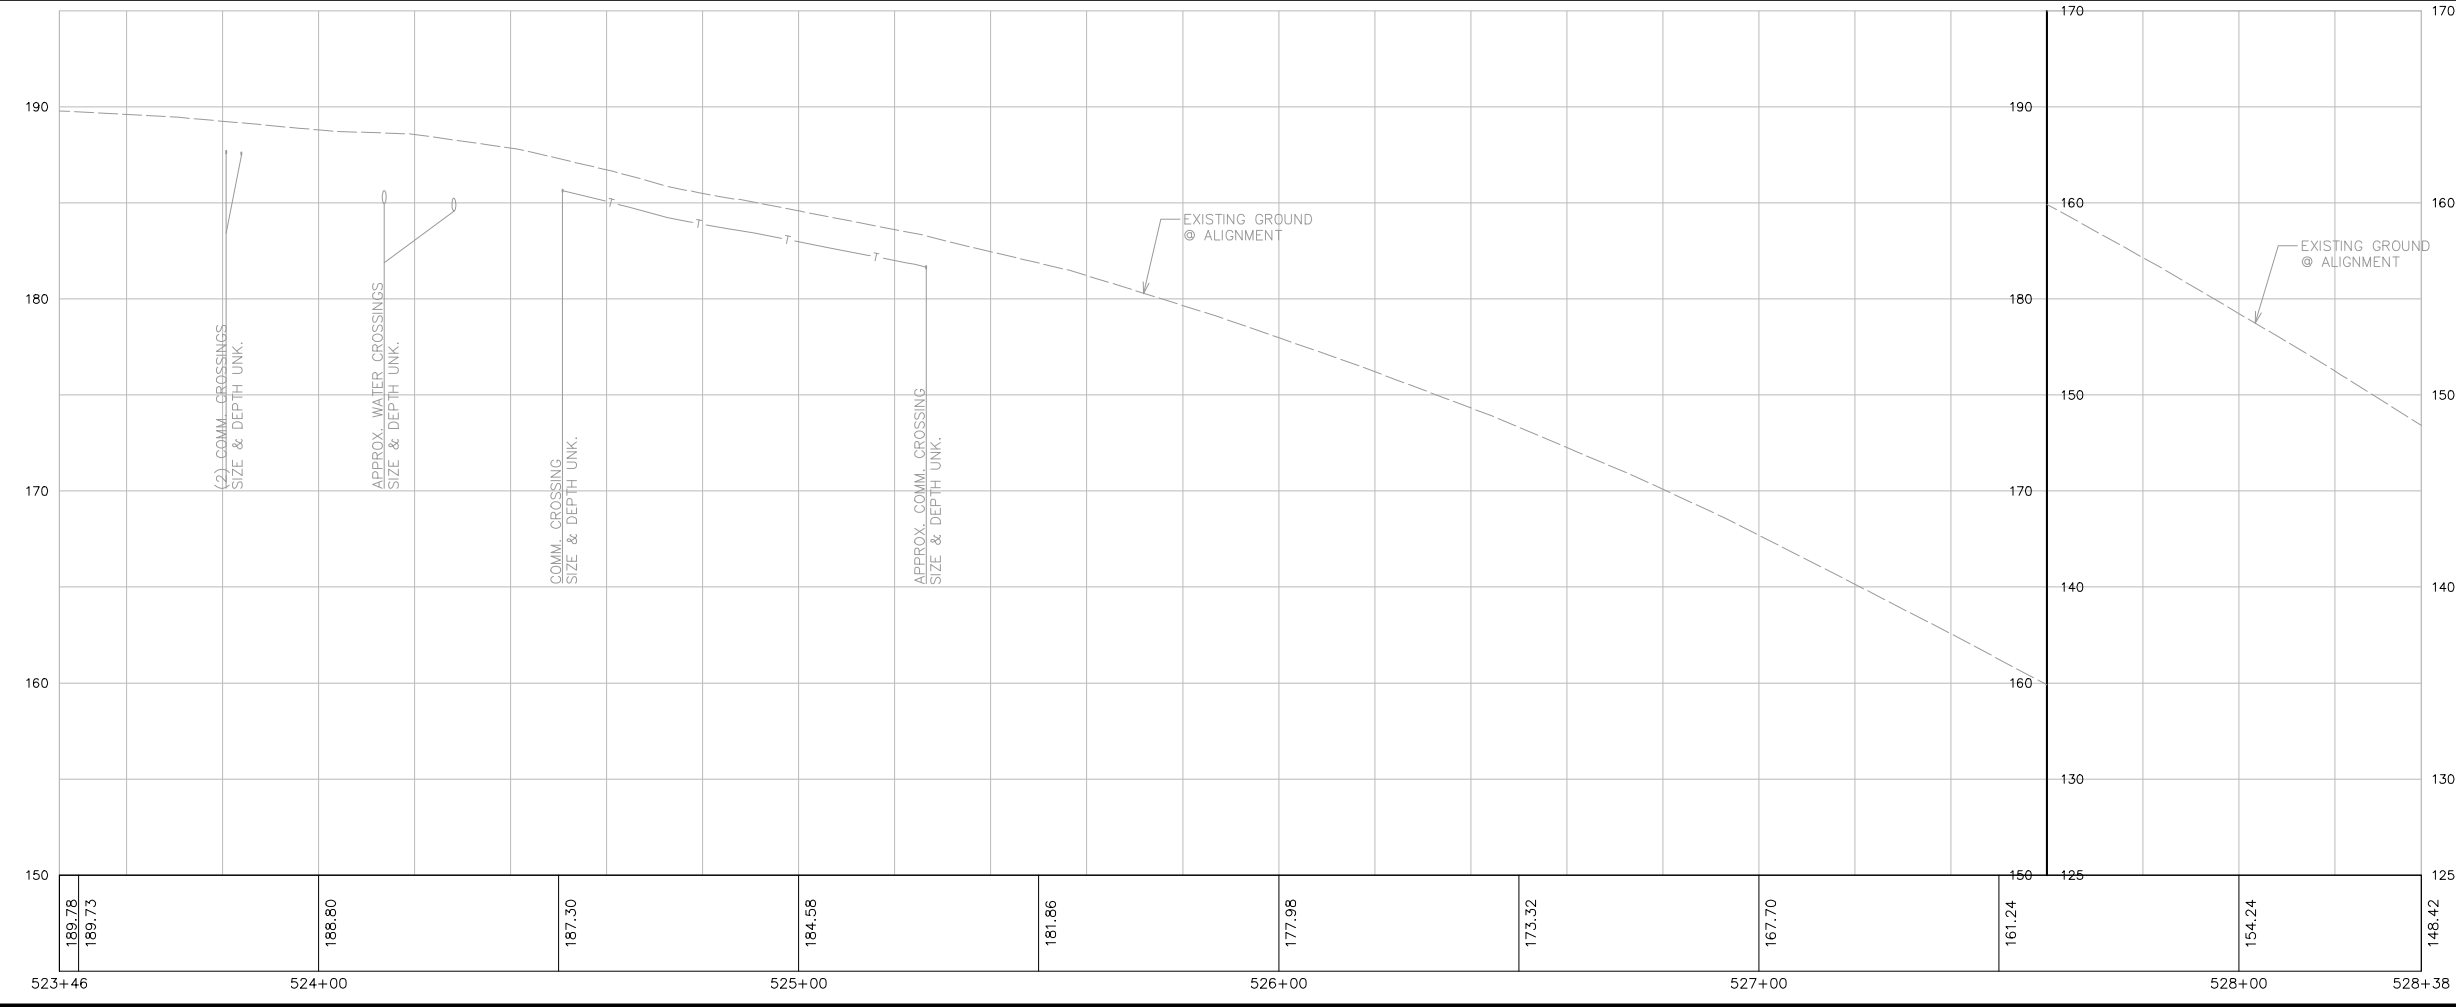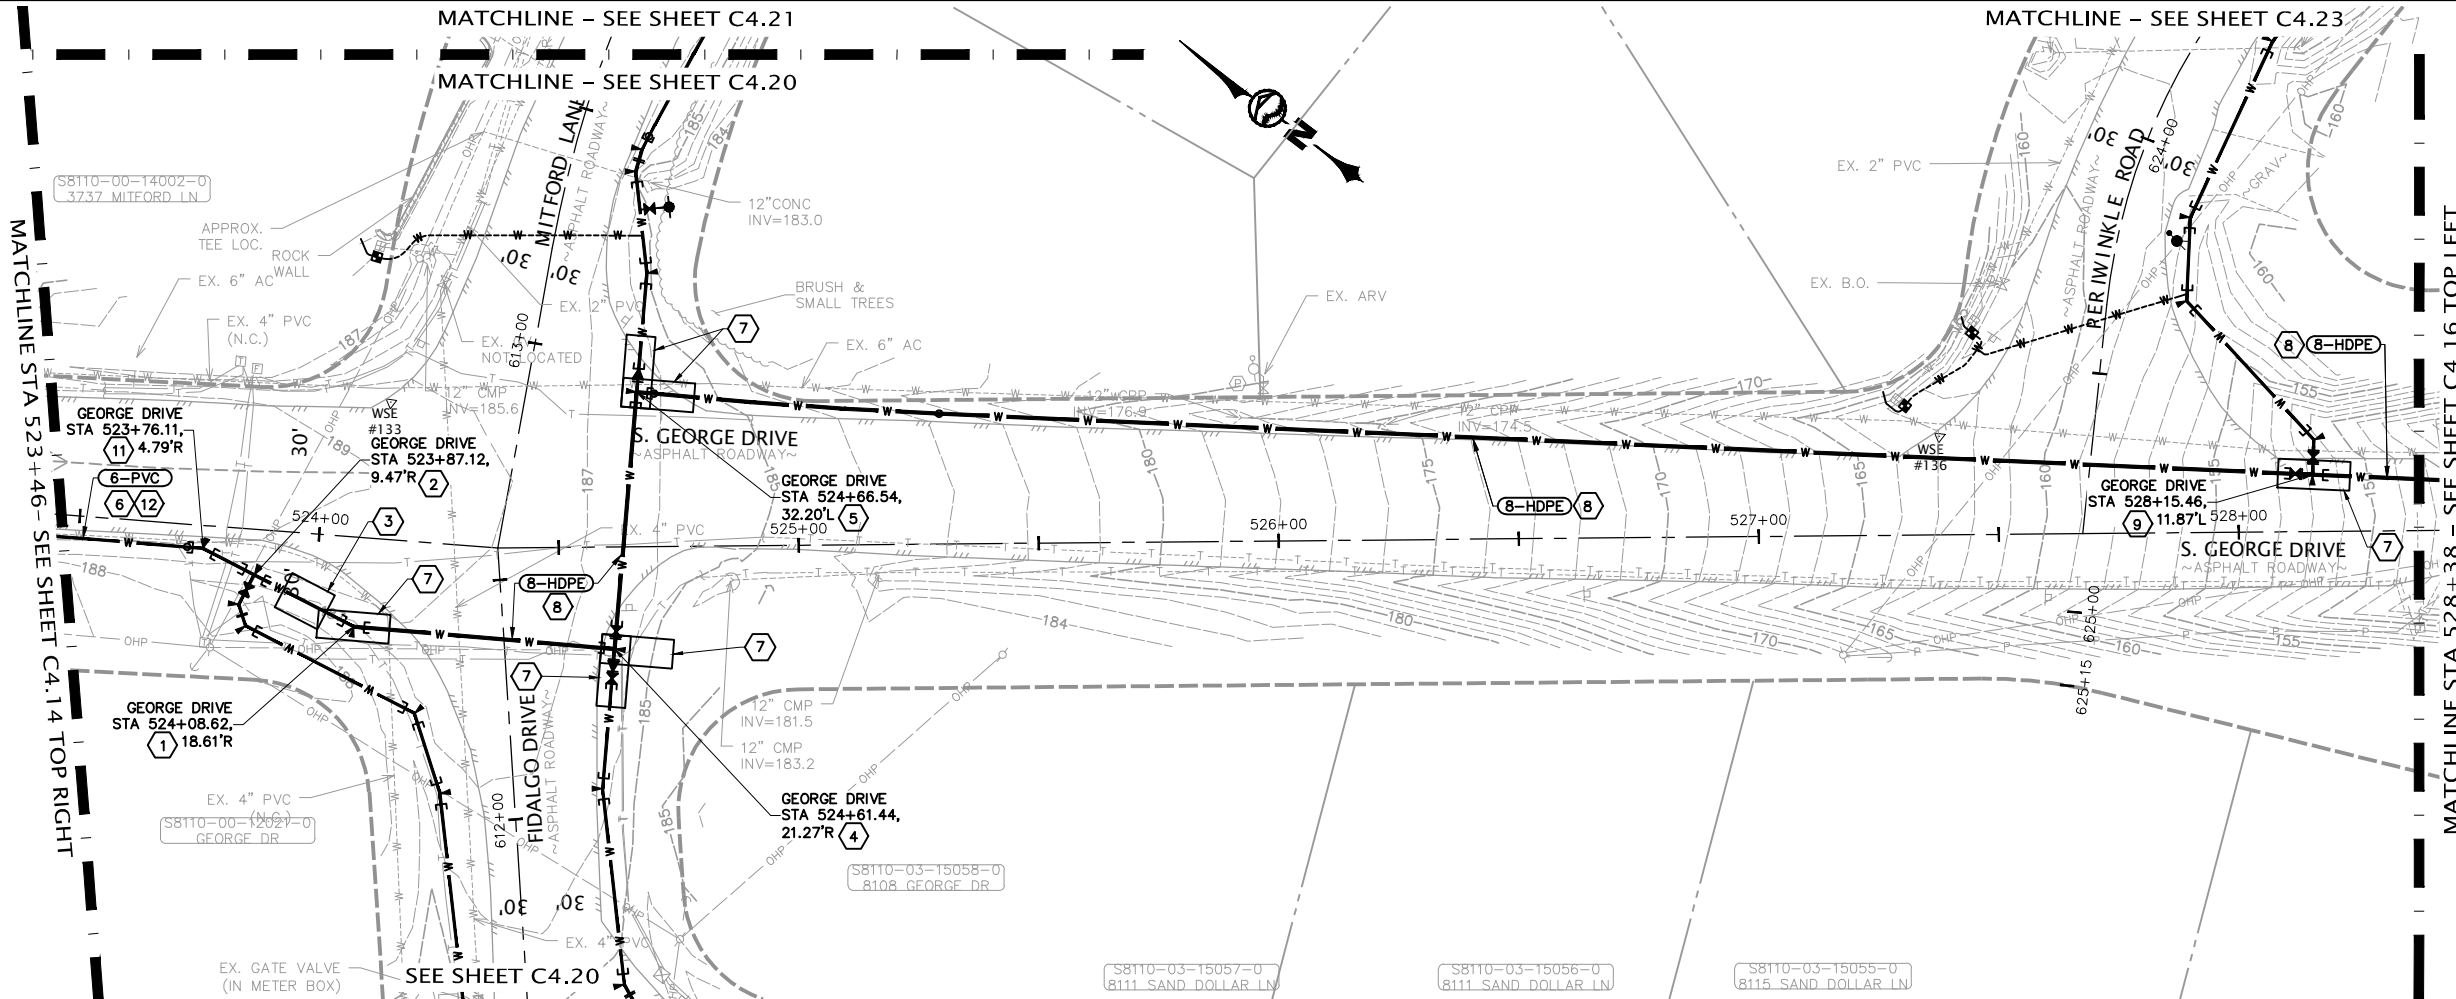

NO.	REVISIONS	BY	DATE
1	KEYED NOTES		
2	= 6"x8" REDUCING 22-1/2' BEND MxMJ, THRUST BLOCKING		
3	= 6" TEE MxMJxFL, 6" GV FLxFL, 6" 45° BEND FLxFL, 6" 45° BEND FLxMJ, THRUST BLOCKING		
4	= PRV VAULT PER (X)		
5	= 8" TEE FLxMJxFL, 8" GV FLxMJ, 8" GV FLxFL, 8"x6" REDUCER FLxMJ, THRUST BLOCKING		
6	= 8" TEE FLxMJxMJ, 8"x6" REDUCER FLxMJ, THRUST BLOCKING		
7	= 175' MIN RADIUS		
8	= HDD ACCESS PIT		
9	= 8" HDPE INSTALLED BY HORIZONTAL DIRECTIONAL DRILLING, HDPE ADAPTERS & FITTINGS AS REQUIRED		
10	= 8"x6" TEE FLxFLxMJ, 8" GV FLxFL, 6" GV FLxFL, 6" 45° BEND FLxMJ, THRUST BLOCKING		
11	= CONNECT TO EX. 6" GV		
12	= 6" 22-1/2' BEND MxMJ, THRUST BLOCKING		
13	= NEW WATER MAIN TRENCH INSTALLED IN SAME LOCATION OR ADJACENT TO EX. 4" PVC CURRENTLY ABANDONED		

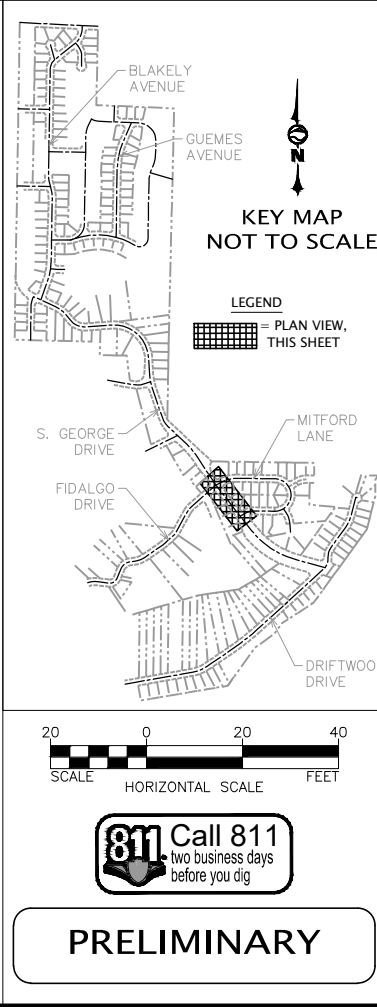

WILSON
ENGINEERING

WILSONENGINEERING.COM

PRELIMINARY

DESIGNED BY CDS/MKW
DRAWN BY JGS
CHECKED BY MMM

SCATCHET HEAD WATER DISTRICT

WASHINGTON

WHIDBEY ISLAND

WATER SYSTEM IMPROVEMENTS

S. GEORGE DRIVE - STA 523+46 TO STA 528+38


SHEET C4.15

DATE 12-8-22

SCALE AS SHOWN

PAGE X OF X

PLOT SETTINGS: AutoCAD PDF (General Documentation).pc3, ANSI full bleed B (17.00 x 11.00 inches), Portrait, 1:2, WE APWA_UNSCREENED.ctb
W:\2022\2022-013 SCATCHET HEAD WD WATER IMPROVEMENTS.MMM\DWG_V2019_NAD83_NAYD88\2022_013 C4.10-C4.17 GEORGE PLAN & PROFILES.DWG - 12/8/2022 2:03 PM - Jeff Smith

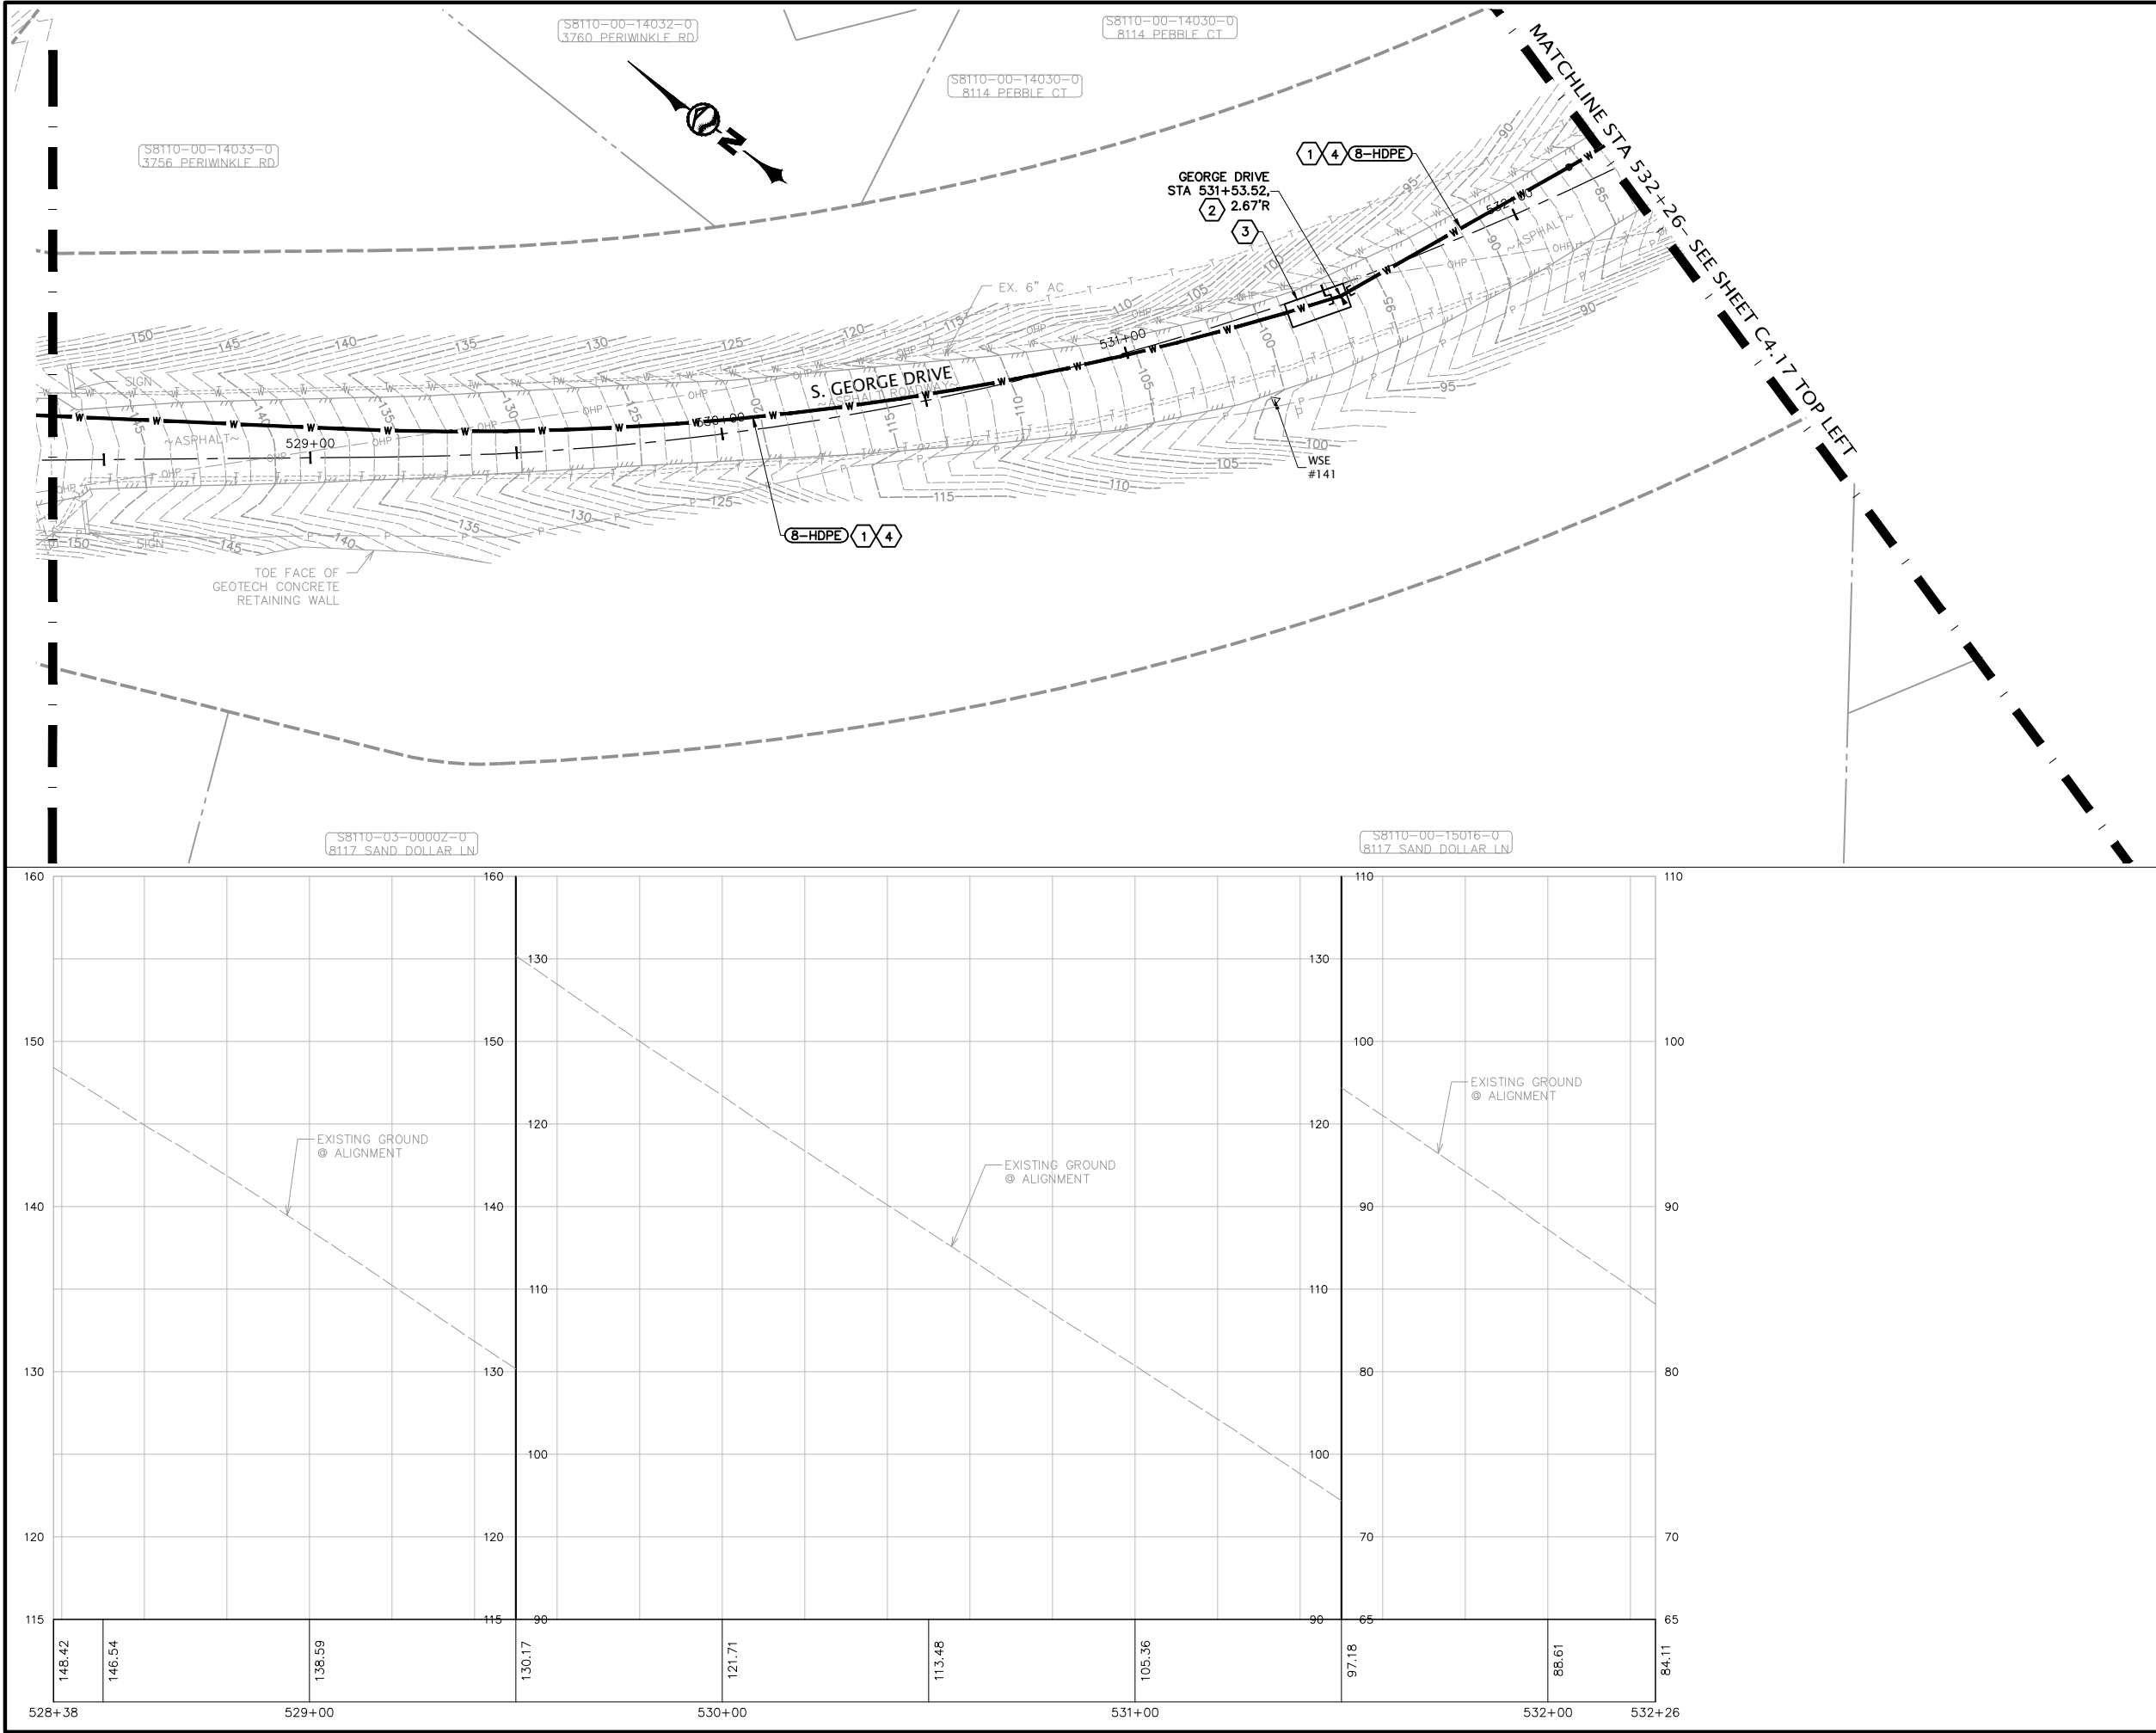

NO.	REVISIONS	BY	DATE

KEYED NOTES

1 = 8" HDPE INSTALLED BY HORIZONTAL DIRECTIONAL DRILLING, HDPE ADAPTERS & FITTINGS AS REQUIRED

2 = 8" 11-1/4" BEND MJxMJ, HDPE MJ ADAPTERS AS NEEDED.

3 = HDD ACCESS PIT

4 = 200' MIN BENDING RADIUS

20 0 20 40
SCALE HORIZONTAL SCALE FEET

PRELIMINARY

WILSON
ENGINEERING
WILSONENGINEERING.COM

DESIGNED BY CDS/MXW	DRAWN BY JGS	CHECKED BY MMM
------------------------	-----------------	-------------------


SCATCHET HEAD WATER DISTRICT
WHIDBEY ISLAND

WATER SYSTEM IMPROVEMENTS

S. GEORGE DRIVE - STA 528+38 TO STA 532+26

SHEET C4.16	DATE 12-8-22	SCALE AS SHOWN	JOB NUMBER 2022-013
PAGE	X	OF	X

PLOT SETTINGS: AutoCAD PDF (General Documentation).pc3, ANSI full bleed B (17.00 x 11.00 inches), Portrait, 1:2, WE APWA_UNSCREENED.ctb
W:\2022\2022-013 SCATCHET HEAD WD WATER IMPROVEMENTS.MMM\DWG_V2019_NAD83_NAD88\2022_2022-013 C4.10-C4.17 GEORGE PLAN & PROFILES.DWG - 12/8/2022 2:04 PM - Jeff Smith

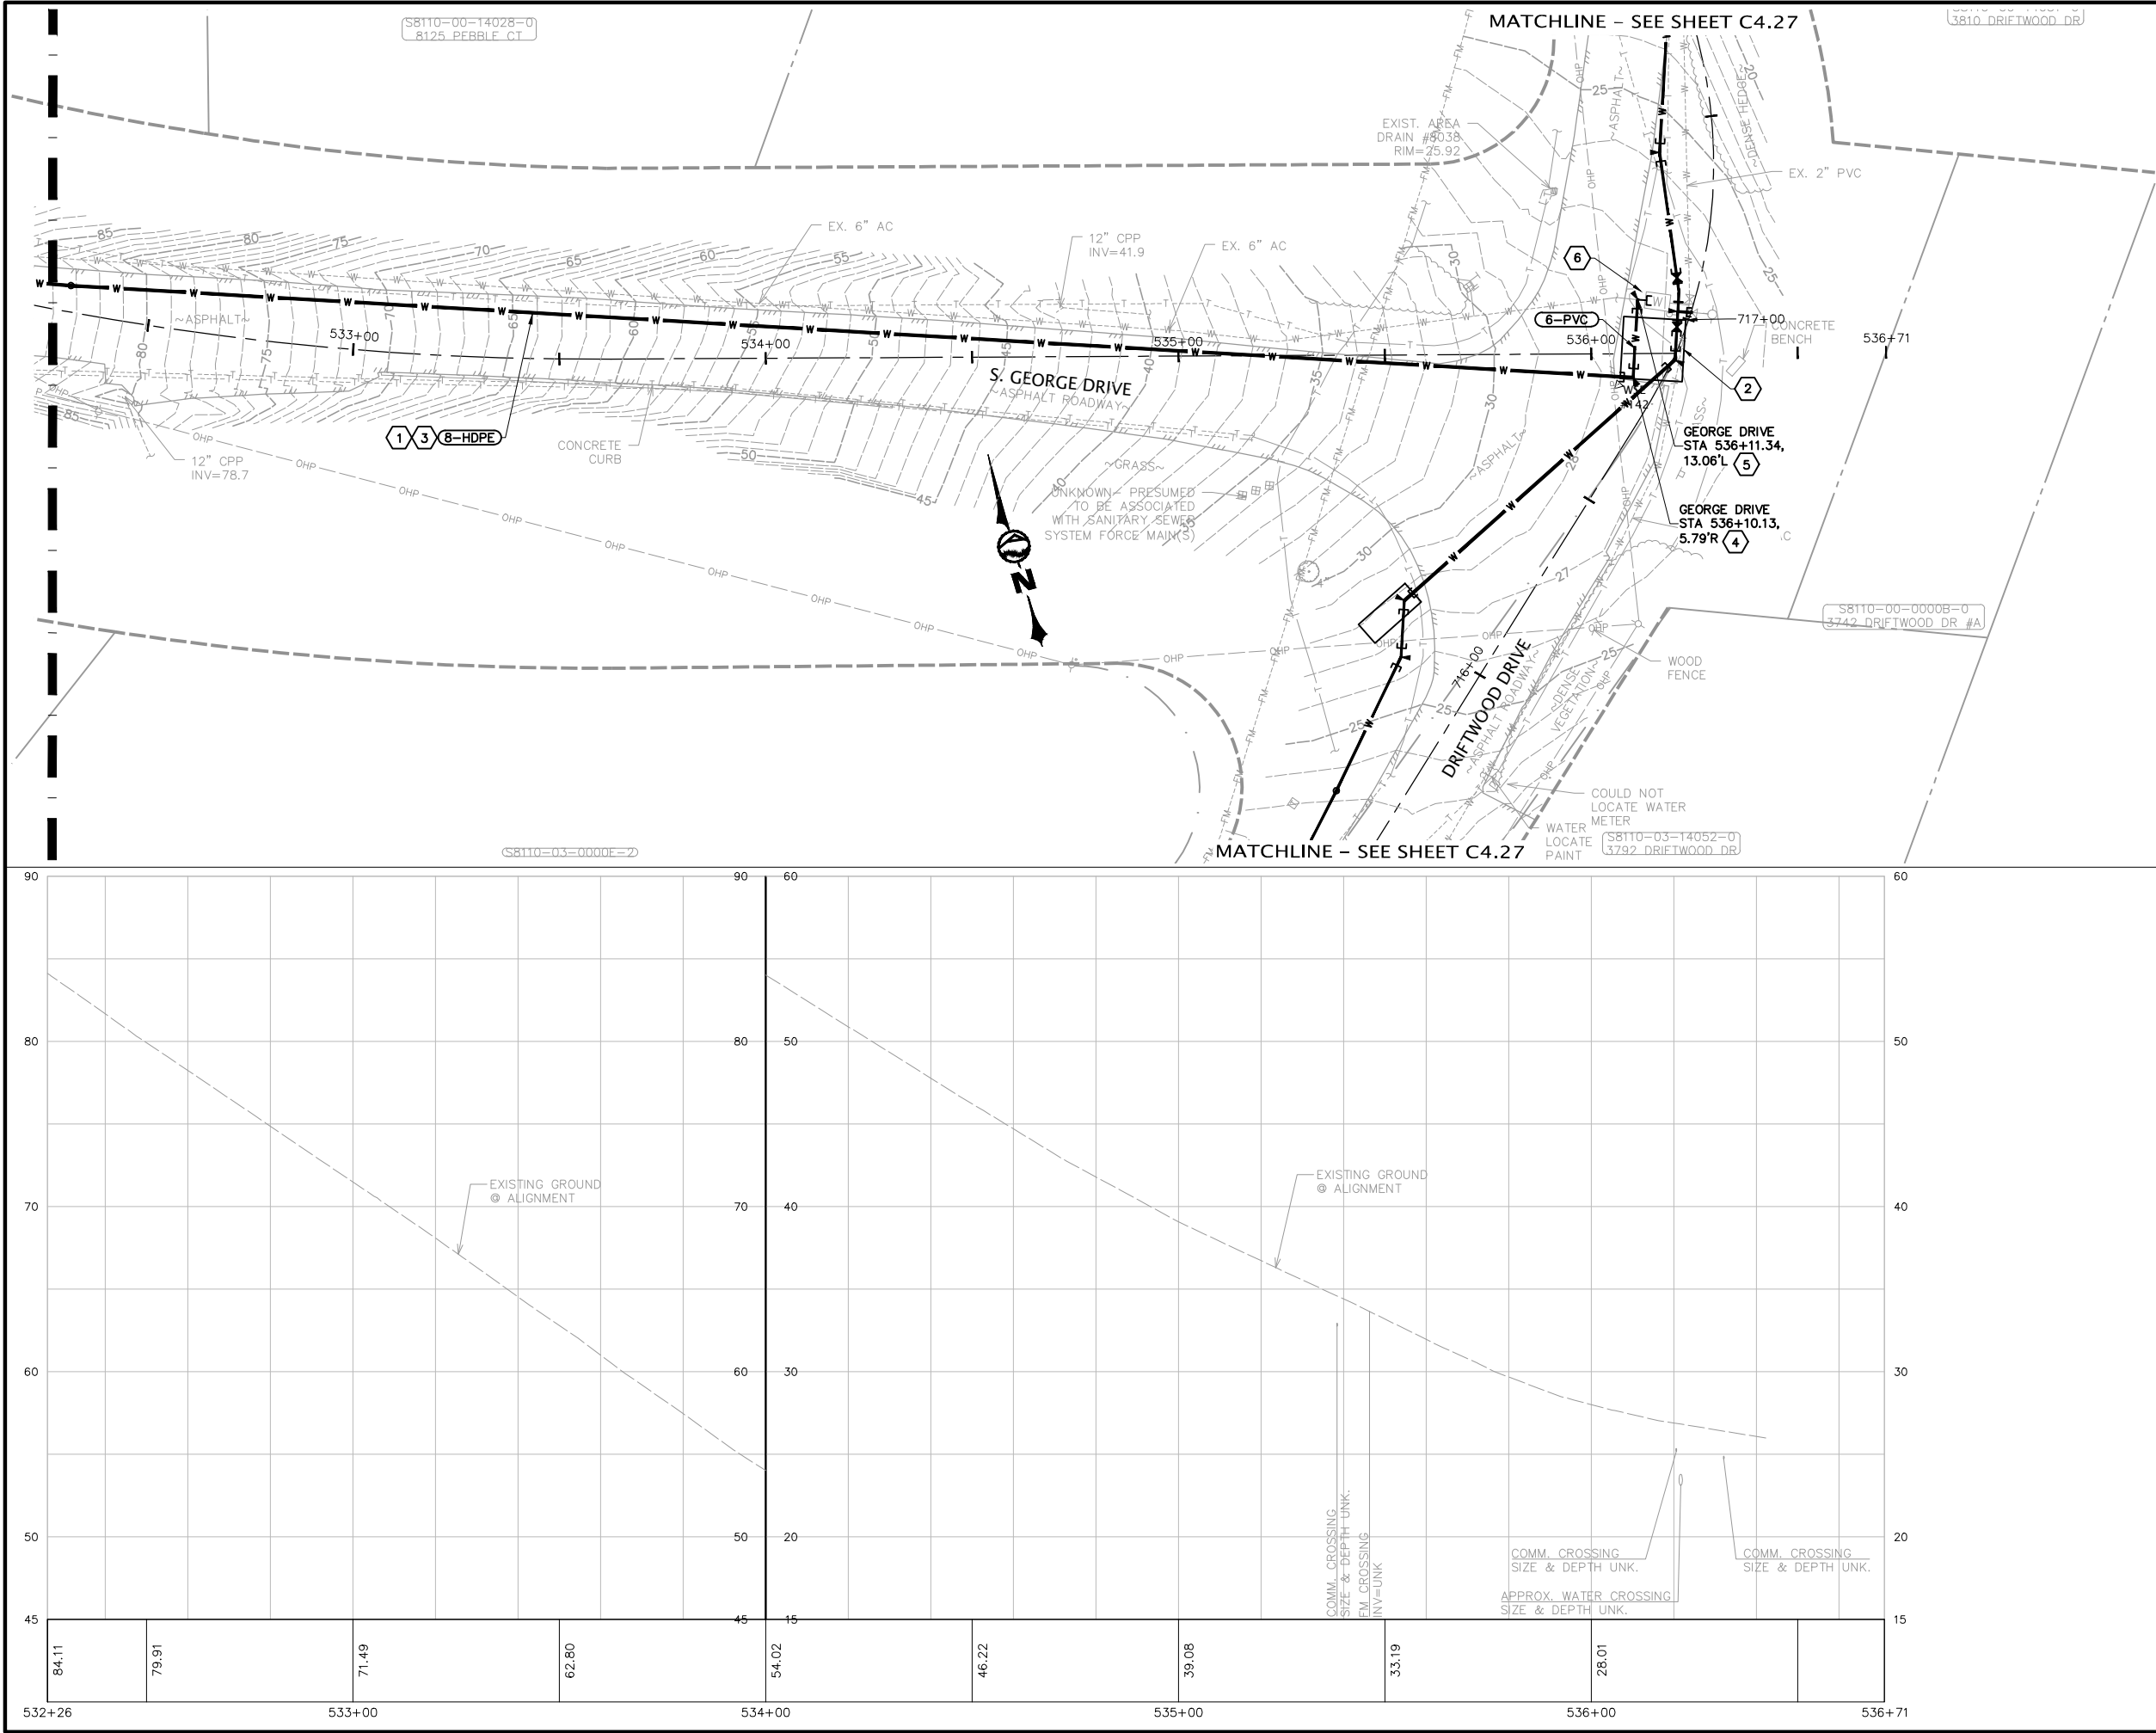

NO.	REVISIONS	BY	DATE
1	KEYED NOTES		
2	= 8" HDPE INSTALLED BY HORIZONTAL DIRECTIONAL DRILLING, HDPE ADAPTERS & FITTINGS AS REQUIRED		
3	= HDD ACCESS PIT		
4	= 200' MIN BENDING RADIUS		
5	= 8"x6" 90° BEND MJxMJ, THRUST BLOCKING		
6	= CONNECT TO EX. 4" DI PRV INLET PIPE. 6" 90° BEND MJxMJ, 6"x4" REDUCER, THRUST BLOCKING		
7	= CONNECT TO EXISTING PRV VAULT. PROVIDE ALL FITTINGS & APPURTENANCES		

KEY MAP NOT TO SCALE

LEGEND

PLAN VIEW, THIS SHEET

20 0 20 40
SCALE HORIZONTAL SCALE FEET

811 Call 811
two business days before you dig

PRELIMINARY


SCATCHET HEAD WATER DISTRICT		WATER SYSTEM IMPROVEMENTS		S. GEORGE DRIVE - STA 532+26 TO STA 536+71	
DESIGNED BY	CDS/MXW	DRAWN BY	JGS	CHECKED BY	MMM
WASHINGTON		WASHINGTON		WASHINGTON	
DATE	12-8-22	SCALE	AS SHOWN	JOB NUMBER	2022-013
SHEET	C4.17	PAGE	X	OF	X

WILSON ENGINEERING

WILSONENGINEERING.COM

PRELIMINARY

PLOT SETTINGS: AutoCAD PDF (General Documentation).pc3, ANSI full bleed B (17.00 x 11.00 inches), Portrait, 1:2, WE APWA_UNSCREENED.ctb
W:\2022\2022-013 SCATCHET HEAD WD WATER IMPROVEMENTS.MMM\DWG_V2019_NAD83_NAD88\2022_013 C4.18-C4.23 FIDALGO PLAN & PROFILES.DWG - 12/8/2022 2:04 PM - Jeff Smith

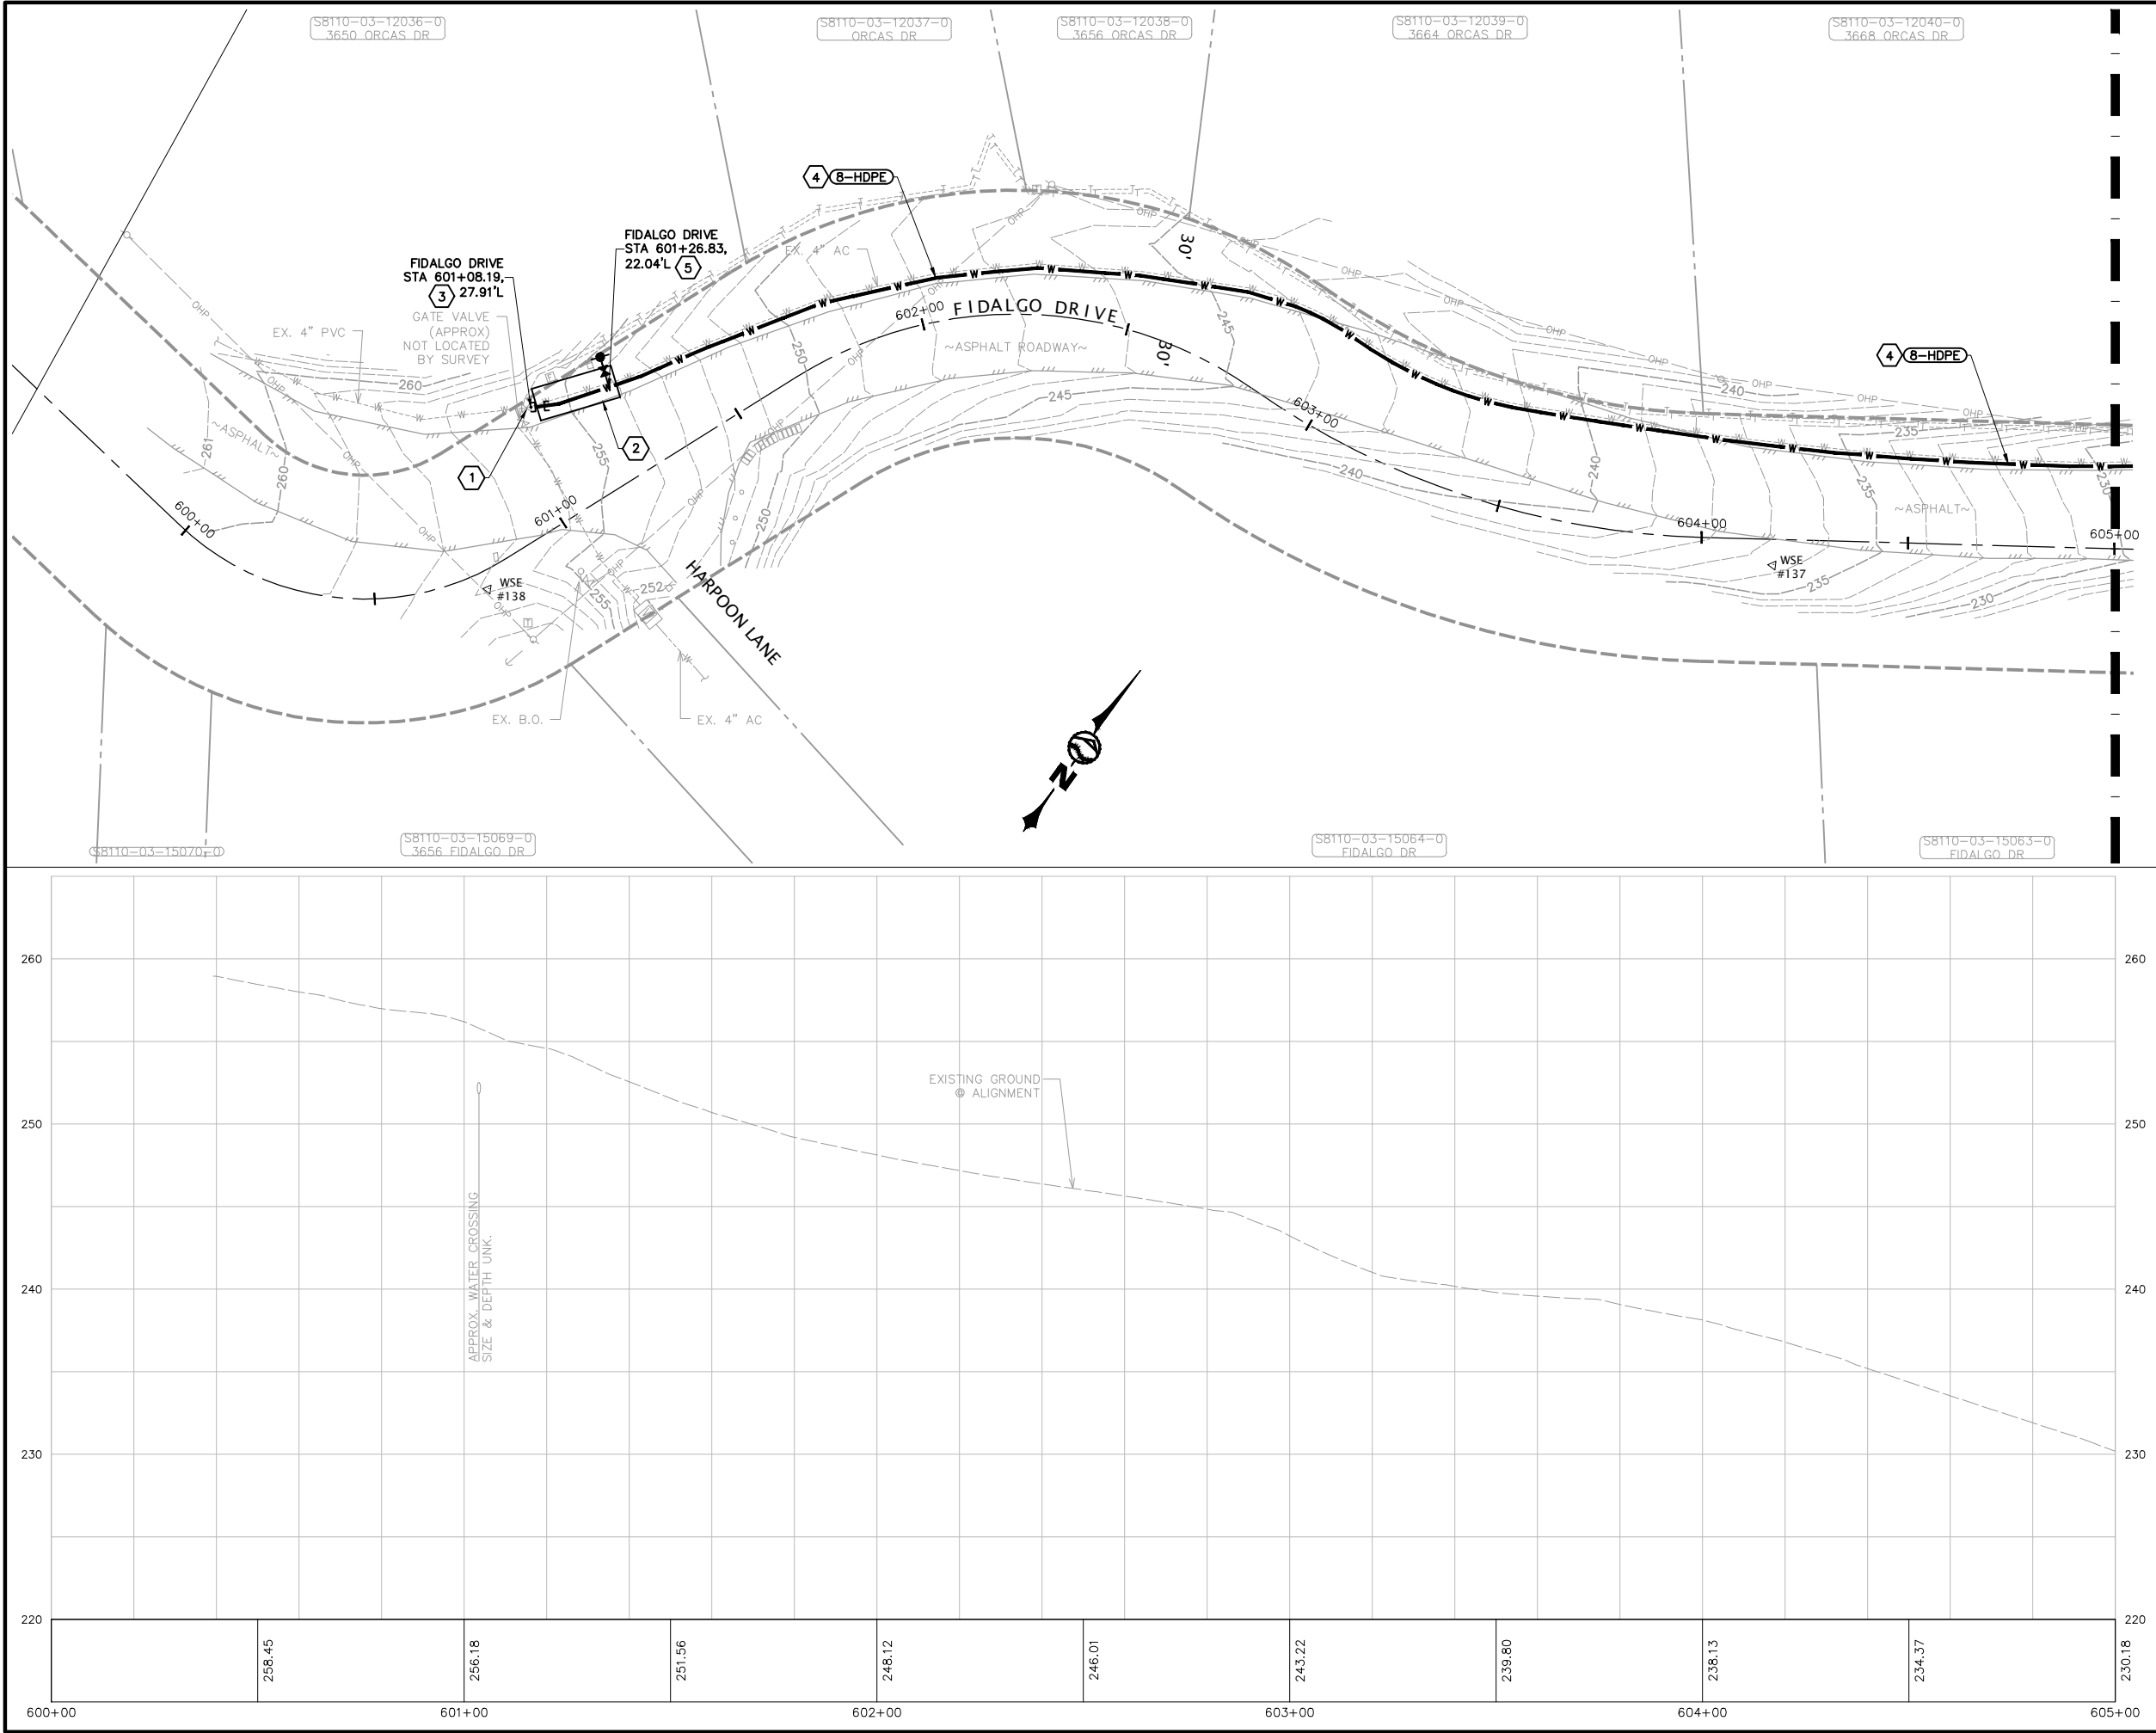

NO.	REVISIONS	BY	DATE
KEYED NOTES 1 = CLOSE EX. GV. SEE NOTE 1 2 = 20'x8' ACCESS PIT 3 = CONNECT TO EX. 4" GV 4 = STATIC PIPE-BURSTING INSTALLATION, HDPE ADAPTERS & FITTINGS AS REQUIRED 5 = HYDRANT ASS'Y PER			
SHEET NOTES: 1) EX. SUPPLY TO MITFORD LANE & SAND DOLLAR LANE AND AREAS DOWNSTREAM IS FROM FIDALGO DRIVE AND THROUGH THE EXISTING PRV VAULT (TO BE REPLACED). ISOLATION OF THE EXISTING FIDALGO DRIVE MAIN TO BE PIPE-BURSTED CANNOT OCCUR UNTIL THE NEW PRV VAULT AND ASSOCIATED WATER MAINS ARE COMPLETE AND IN OPERATION SUCH THAT MITFORD LANE AND SAND DOLLAR LANE IS SUPPLIED THROUGH THE NEW PRV VAULT.			

DESIGNED BY	XXX	DRAWN BY	JGS	CHECKED BY	CDS
WASHINGTON					

DATE	12-8-22	SCALE	AS SHOWN	JOB NUMBER	2022-013
SCATCHET HEAD WATER DISTRICT					
WATER SYSTEM IMPROVEMENTS					
FIDALGO DRIVE - STA 600+00 TO STA 605+00					

SHEET	C4.18	PAGE	X	OF	X
PRELIMINARY					

KEY MAP
NOT TO SCALE

LEGEND
= PLAN VIEW, THIS SHEET

SCALE 0 20 40 FEET

811 Call 811 two business days before you dig

WILSON
ENGINEERING

WILSONENGINEERING.COM

PRELIMINARY

SCATCHET HEAD WATER DISTRICT

WASHINGTON

WATER SYSTEM IMPROVEMENTS

WHIDBEY ISLAND

FIDALGO DRIVE - STA 600+00 TO STA 605+00

DATE 12-8-22



SCALE AS SHOWN

JOB NUMBER 2022-013

SHEET C4.18

PAGE X OF X

PLOT SETTINGS: AutoCAD PDF (General Documentation).pc3, ANSI full bleed B (17.00 x 11.00 inches), Portrait, 1:2, WE APWA_UNSCREENED.ctb
W:\2022\2022-013 SCATCHET HEAD WD WATER IMPROVEMENTS.MMM\DWG_V2019_NAD83_NAD88\2022_2022-013 C4.18-C4.23 FIDALGO PLAN & PROFILES.DWG - 12/8/2022 2:05 PM - Jeff Smith

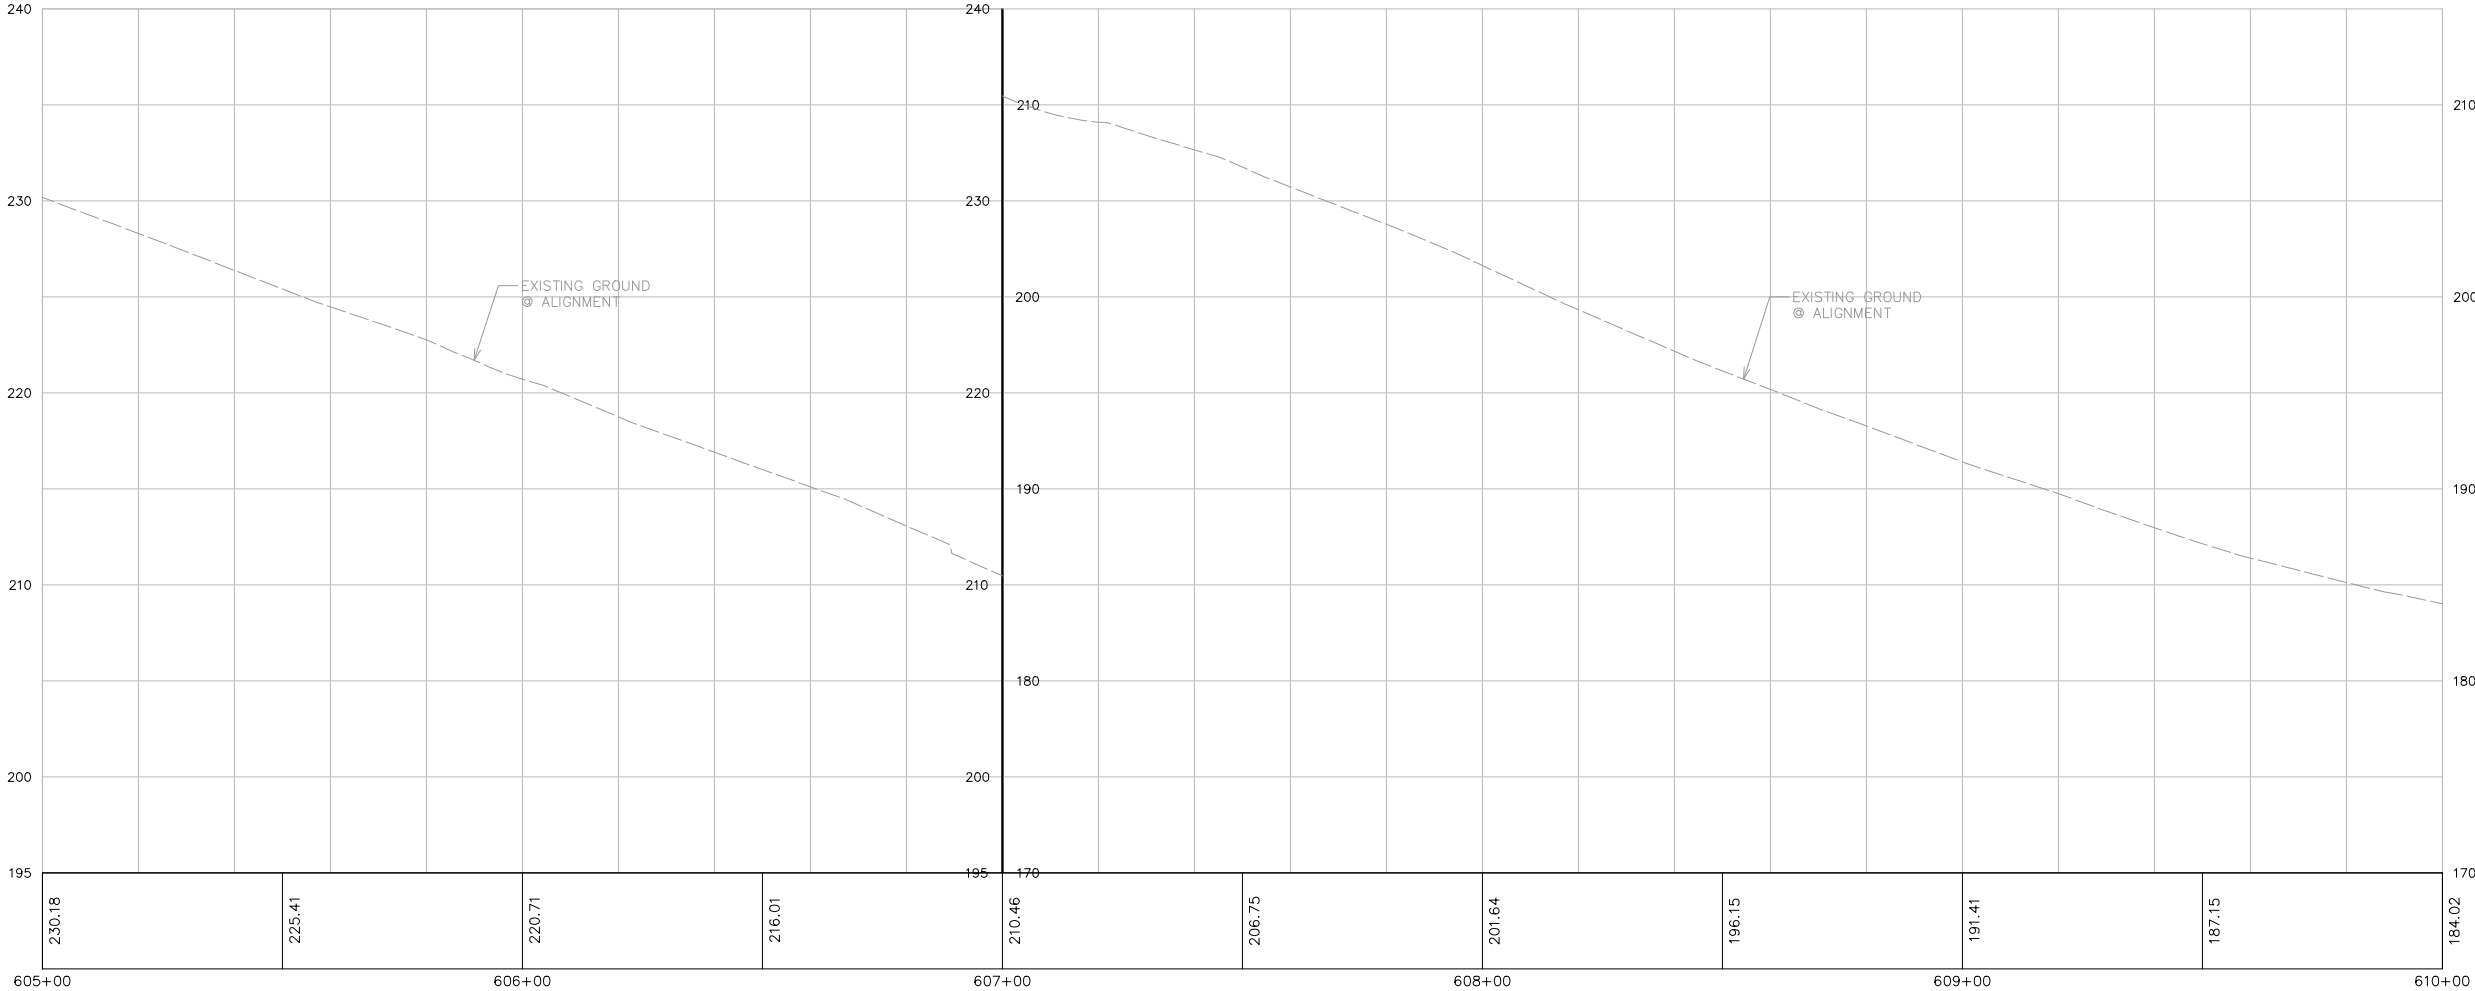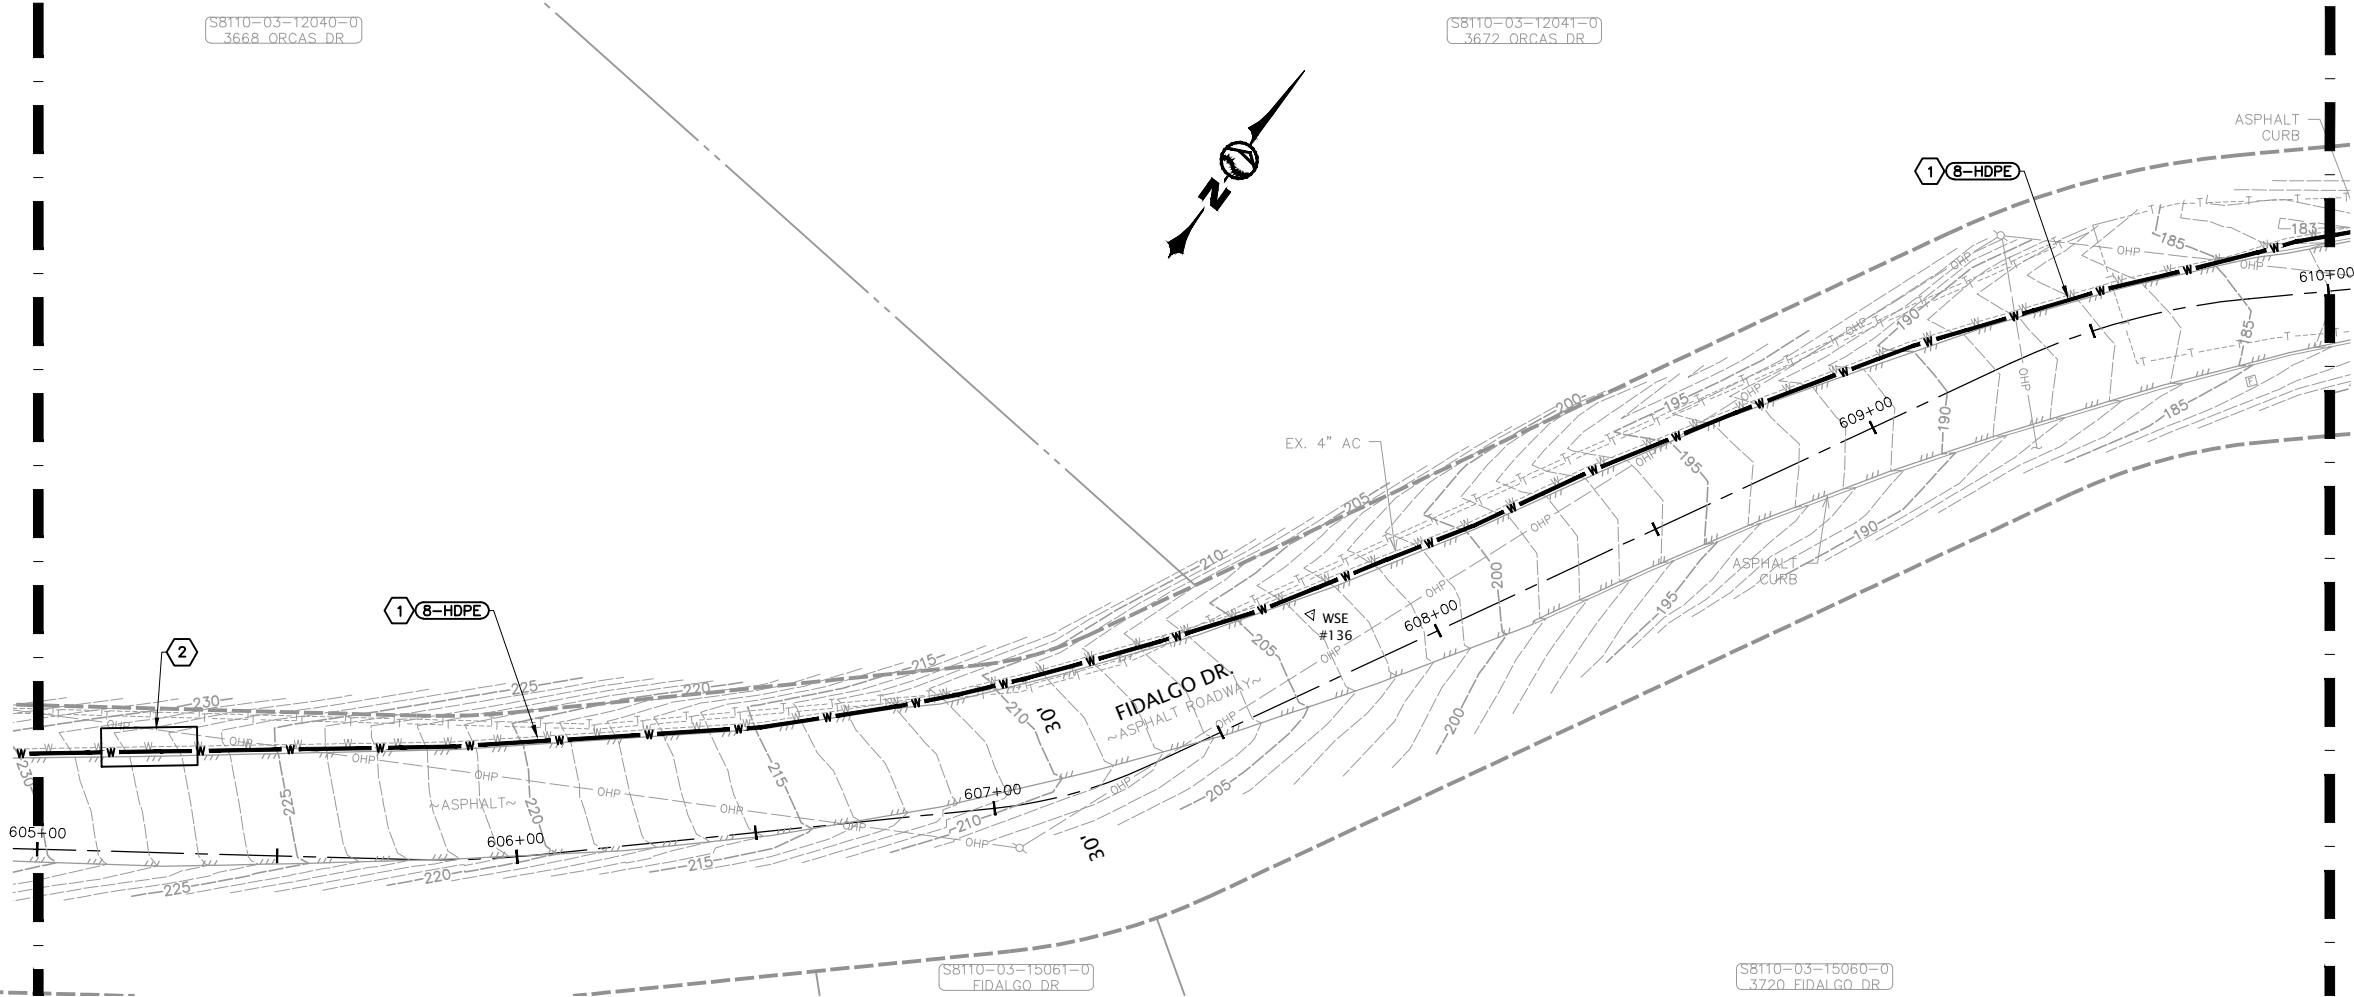

NO.

REVISIONS

BY

DATE

1

KEYED NOTES

= STATIC PIPE-BURSTING INSTALLATION, HDPE ADAPTERS & FITTINGS AS REQUIRED

2

= PIPE BURST ACCESS PIT

SHEET NOTES:

1) EX. SUPPLY TO MITFORD LANE & SAND DOLLAR LANE AND AREAS DOWNSTREAM IS FROM FIDALGO DRIVE AND THROUGH THE EXISTING PRV VAULT (TO BE REPLACED). ISOLATION OF THE EXISTING FIDALGO DRIVE MAIN TO BE PIPE-BURSTED CANNOT OCCUR UNTIL THE NEW PRV VAULT AND ASSOCIATED WATER MAINS ARE COMPLETE AND IN OPERATION SUCH THAT MITFORD LANE AND SAND DOLLAR LANE IS SUPPLIED THROUGH THE NEW PRV VAULT.

KEY MAP

NOT TO SCALE

LEGEND

= PLAN VIEW, THIS SHEET

20 0 20 40

SCALE HORIZONTAL SCALE FEET

811 Call 811

two business days before you dig

PRELIMINARY

SCATCHET HEAD WATER DISTRICT

WATER SYSTEM IMPROVEMENTS

FIDALGO DRIVE - STA 605+00 TO STA 610+00

DATE

12-8-22

SCALE

AS SHOWN

JOB NUMBER

2022-013

SHEET

C4.19

PAGE

X

OF

X

WILSON ENGINEERING

WILSONENGINEERING.COM

PRELIMINARY

SCATCHET HEAD WATER DISTRICT

WATER SYSTEM IMPROVEMENTS

FIDALGO DRIVE - STA 605+00 TO STA 610+00

DATE

12-8-22

SCALE

AS SHOWN

JOB NUMBER

2022-013

SHEET

C4.19



PAGE

X

OF

X


PLOT SETTINGS: AutoCAD PDF (General Documentation).pc3, ANSI full bleed B (17.00 x 11.00 inches), Portrait, 1:2, WE APWA_UNSCREENED.ctb
W:\2022\2022-013 SCATCHET HEAD WD WATER IMPROVEMENTS.MMM\DWG_V2019_NAD83_NAD88\2022_013 C4.18-C4.23 FIDALGO PLAN & PROFILES.DWG - 12/8/2022 2:05 PM - Jeff Smith

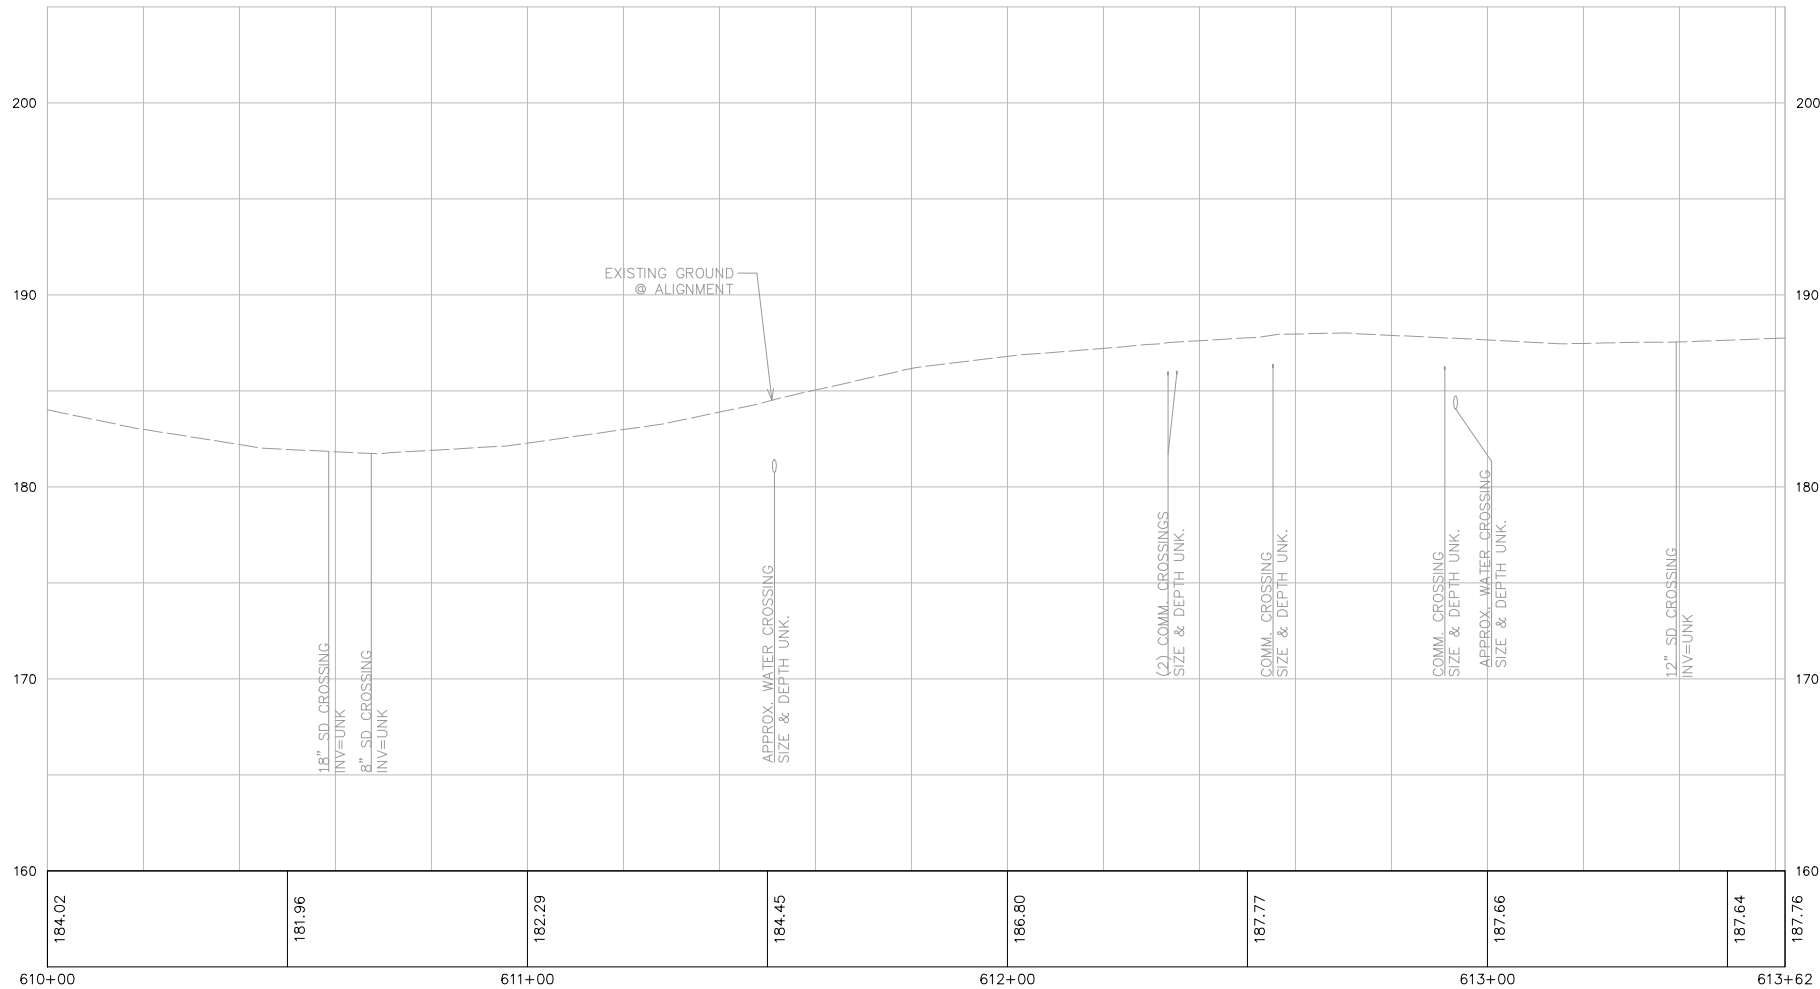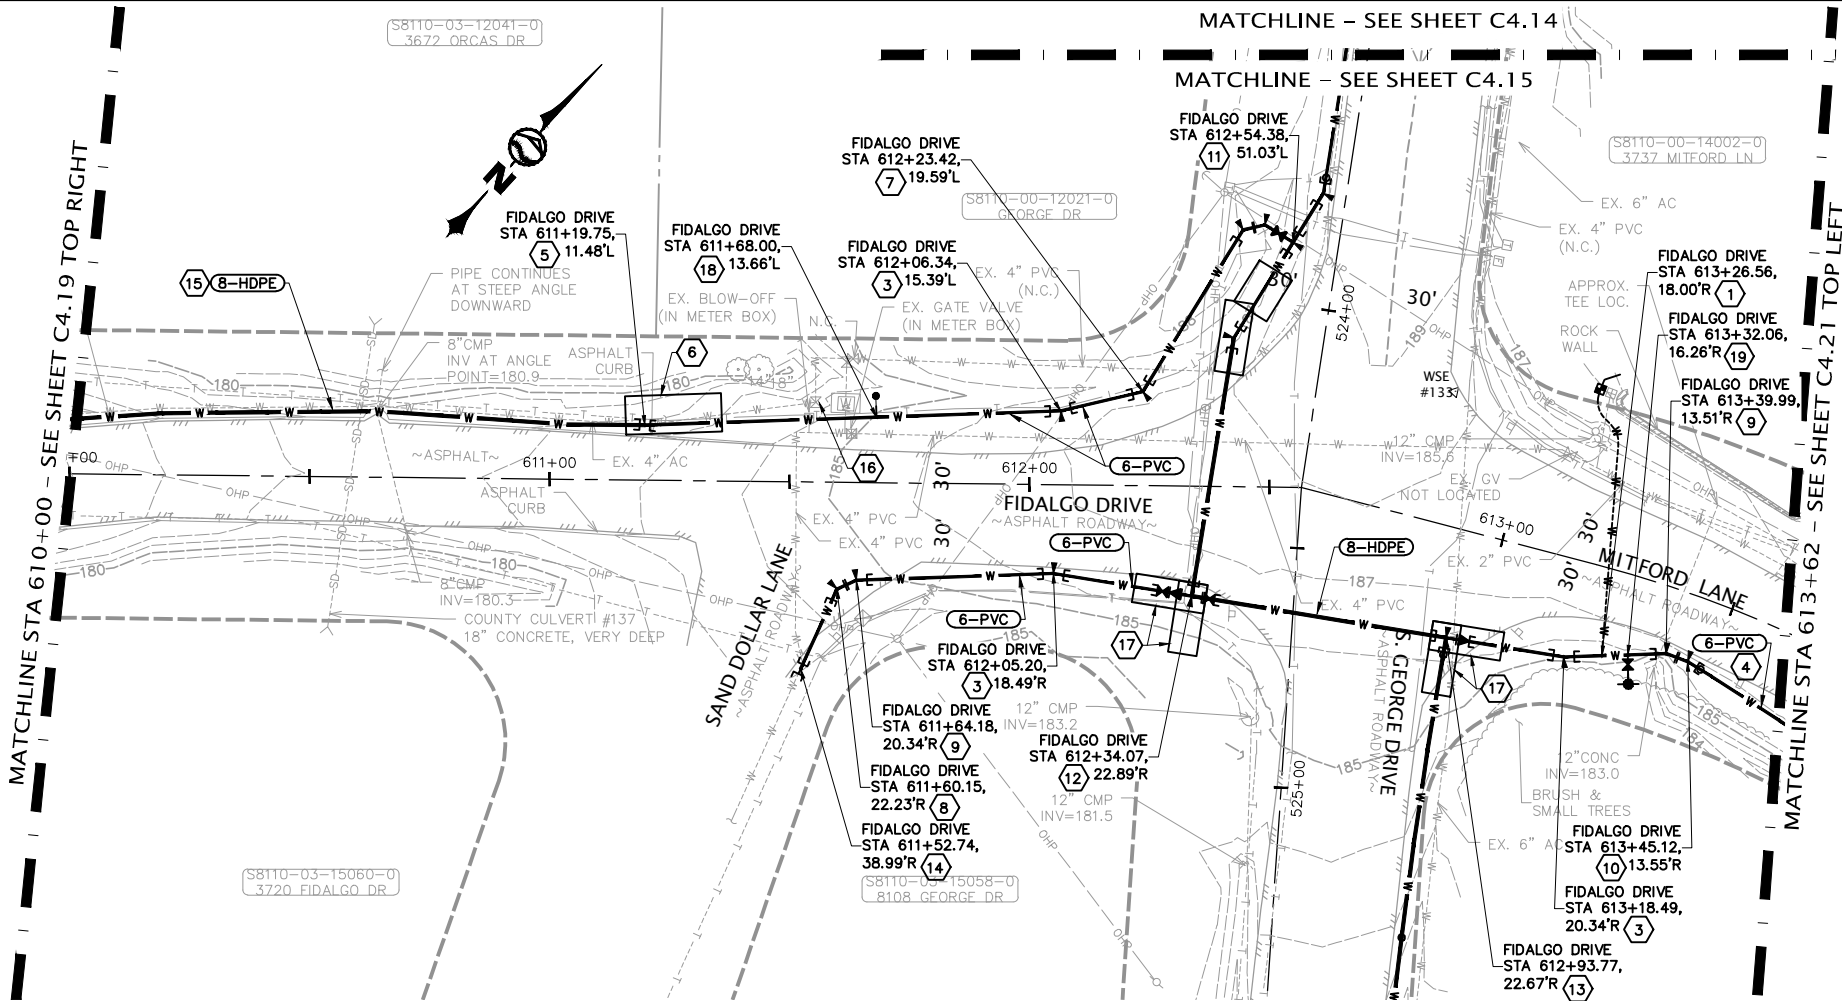

SHEET NOTES:

1) EX. SUPPLY TO MITFORD LANE & SAND DOLLAR LANE AND AREAS DOWNSTREAM IS FROM FIDALGO DRIVE AND THROUGH THE EXISTING PRV VAULT (TO BE REPLACED). ISOLATION OF THE EXISTING FIDALGO DRIVE MAIN TO BE PIPE-BURSTED CANNOT OCCUR UNTIL THE NEW PRV VAULT AND ASSOCIATED WATER MAINS ARE COMPLETE AND IN OPERATION SUCH THAT MITFORD LANE AND SAND DOLLAR LANE IS SUPPLIED THROUGH THE NEW PRV VAULT.

NO.	REVISIONS	BY	DATE
1	KEYED NOTES		
2	= SERVICE CONNECTION PER	X	X
3	= 6" 22-1/2" BEND MJxMJ, THRUST BLOCKING		
4	= 6" 11-1/4" BEND MJxMJ, THRUST BLOCKING		
5	= MIN. 175' RADIUS		
6	= TRANSITION & REDUCE FROM 8" HDPE TO 6" PVC		
7	= PIPE BURST ACCESS PIT		
8	= 6" 45' BEND MJxMJ, THRUST BLOCKING		
9	= 6" 45' BEND FLxMJ, THRUST BLOCKING		
10	= 6" 22-1/2" BEND FLxMJ, THRUST BLOCKING		
11	= 6" 11-1/4" BEND FLxMJ, THRUST BLOCKING		
12	= 6" TEE MJxMJxFL, 6" GV FLxFL, 6" 45' BEND FLxFL, 6" 45' BEND FLxMJ, THRUST BLOCKING		
13	= 8" TEE FLxMJxFL, 8" GV FLxMJ, 8" GV FLxFL, 8"x6" REDUCER FLxMJ, THRUST BLOCKING		
14	= 8" TEE FLxMJxMJ, 8"x6" REDUCER FLxMJ, THRUST BLOCKING		
15	= CONNECT TO EX. 4" PVC		
16	= STATIC PIPE-BURSTING INSTALLATION, HDPE FITTINGS & ADAPTERS AS REQUIRED		
17	= CLOSE EX. GV, SEE NOTE 1		
18	= HDD ACCESS PIT		
19	= BLOW-OFF ASS'Y PER	X	X
	= HYDRANT ASS'Y PER	X	X

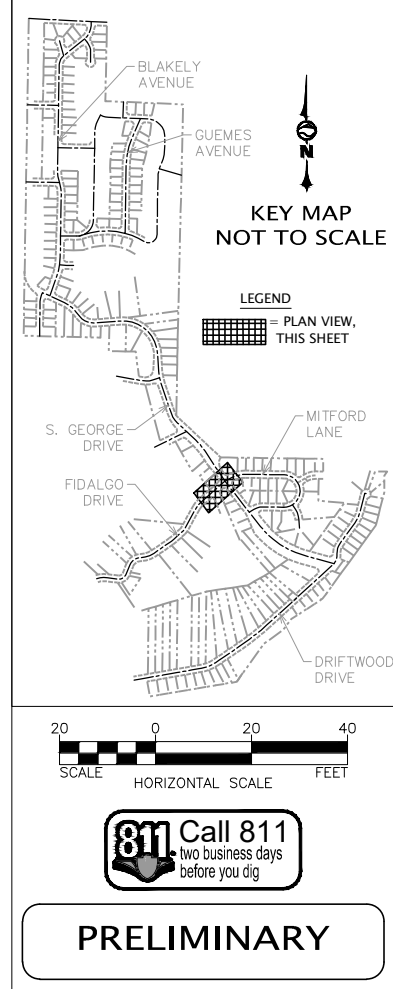



DESIGNED BY	XXX	DRAWN BY	JGS	CHECKED BY	CDS
DATE	12-8-22	SCALE	AS SHOWN	JOB NUMBER	2022-013
SHEET	C4.20	PAGE	X	OF	X
SCATCHET HEAD WATER DISTRICT		WATER SYSTEM IMPROVEMENTS		FIDALGO DRIVE/MITFORD LANE - STA 610+00 TO STA 613+62	
WHIDBEY ISLAND					

WILSON ENGINEERING


WILSONENGINEERING.COM

PRELIMINARY

PLOT SETTINGS: AutoCAD PDF (General Documentation).pc3, ANSI full bleed B (17.00 x 11.00 inches), Portrait, 1:2, WE APWA_UNSCREENED.ctb
W:\2022-2023-013 SCATCHET HEAD WD WATER IMPROVEMENTS_MM\DWG_V2019_NAD83_NAD88\2022_2022-013 C4-18-C4-23 FIDALGO PLAN & PROFILES.DWG - 12/8/2022 2:06 PM - Jeff Smith

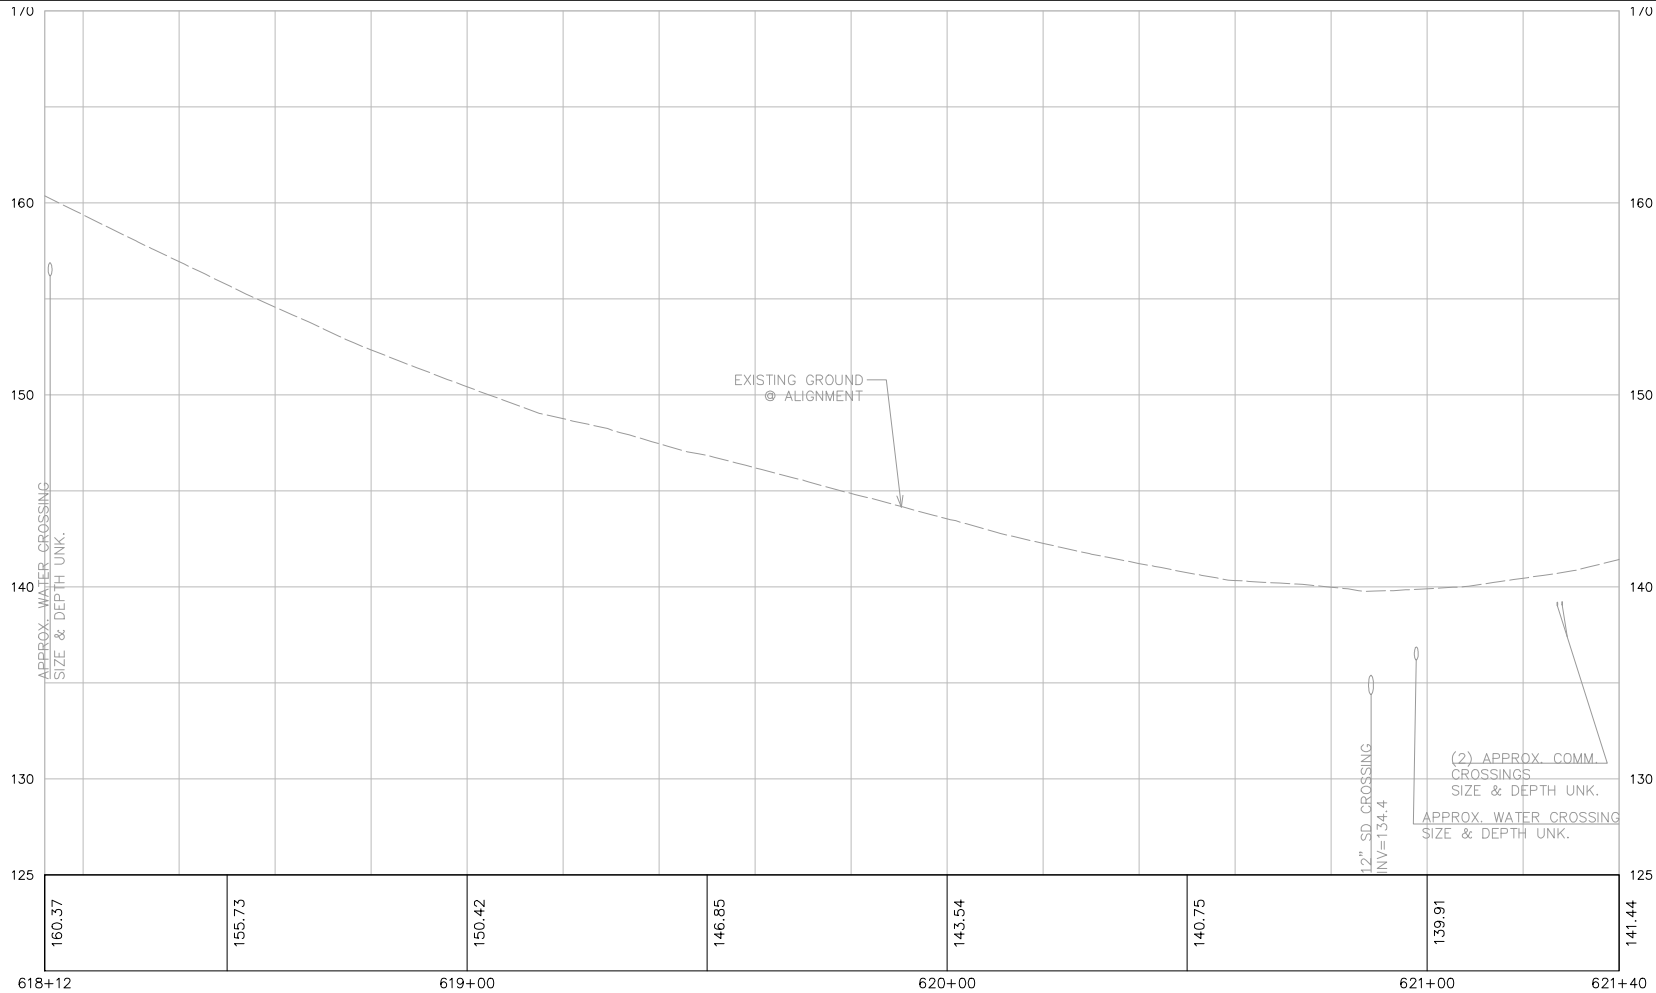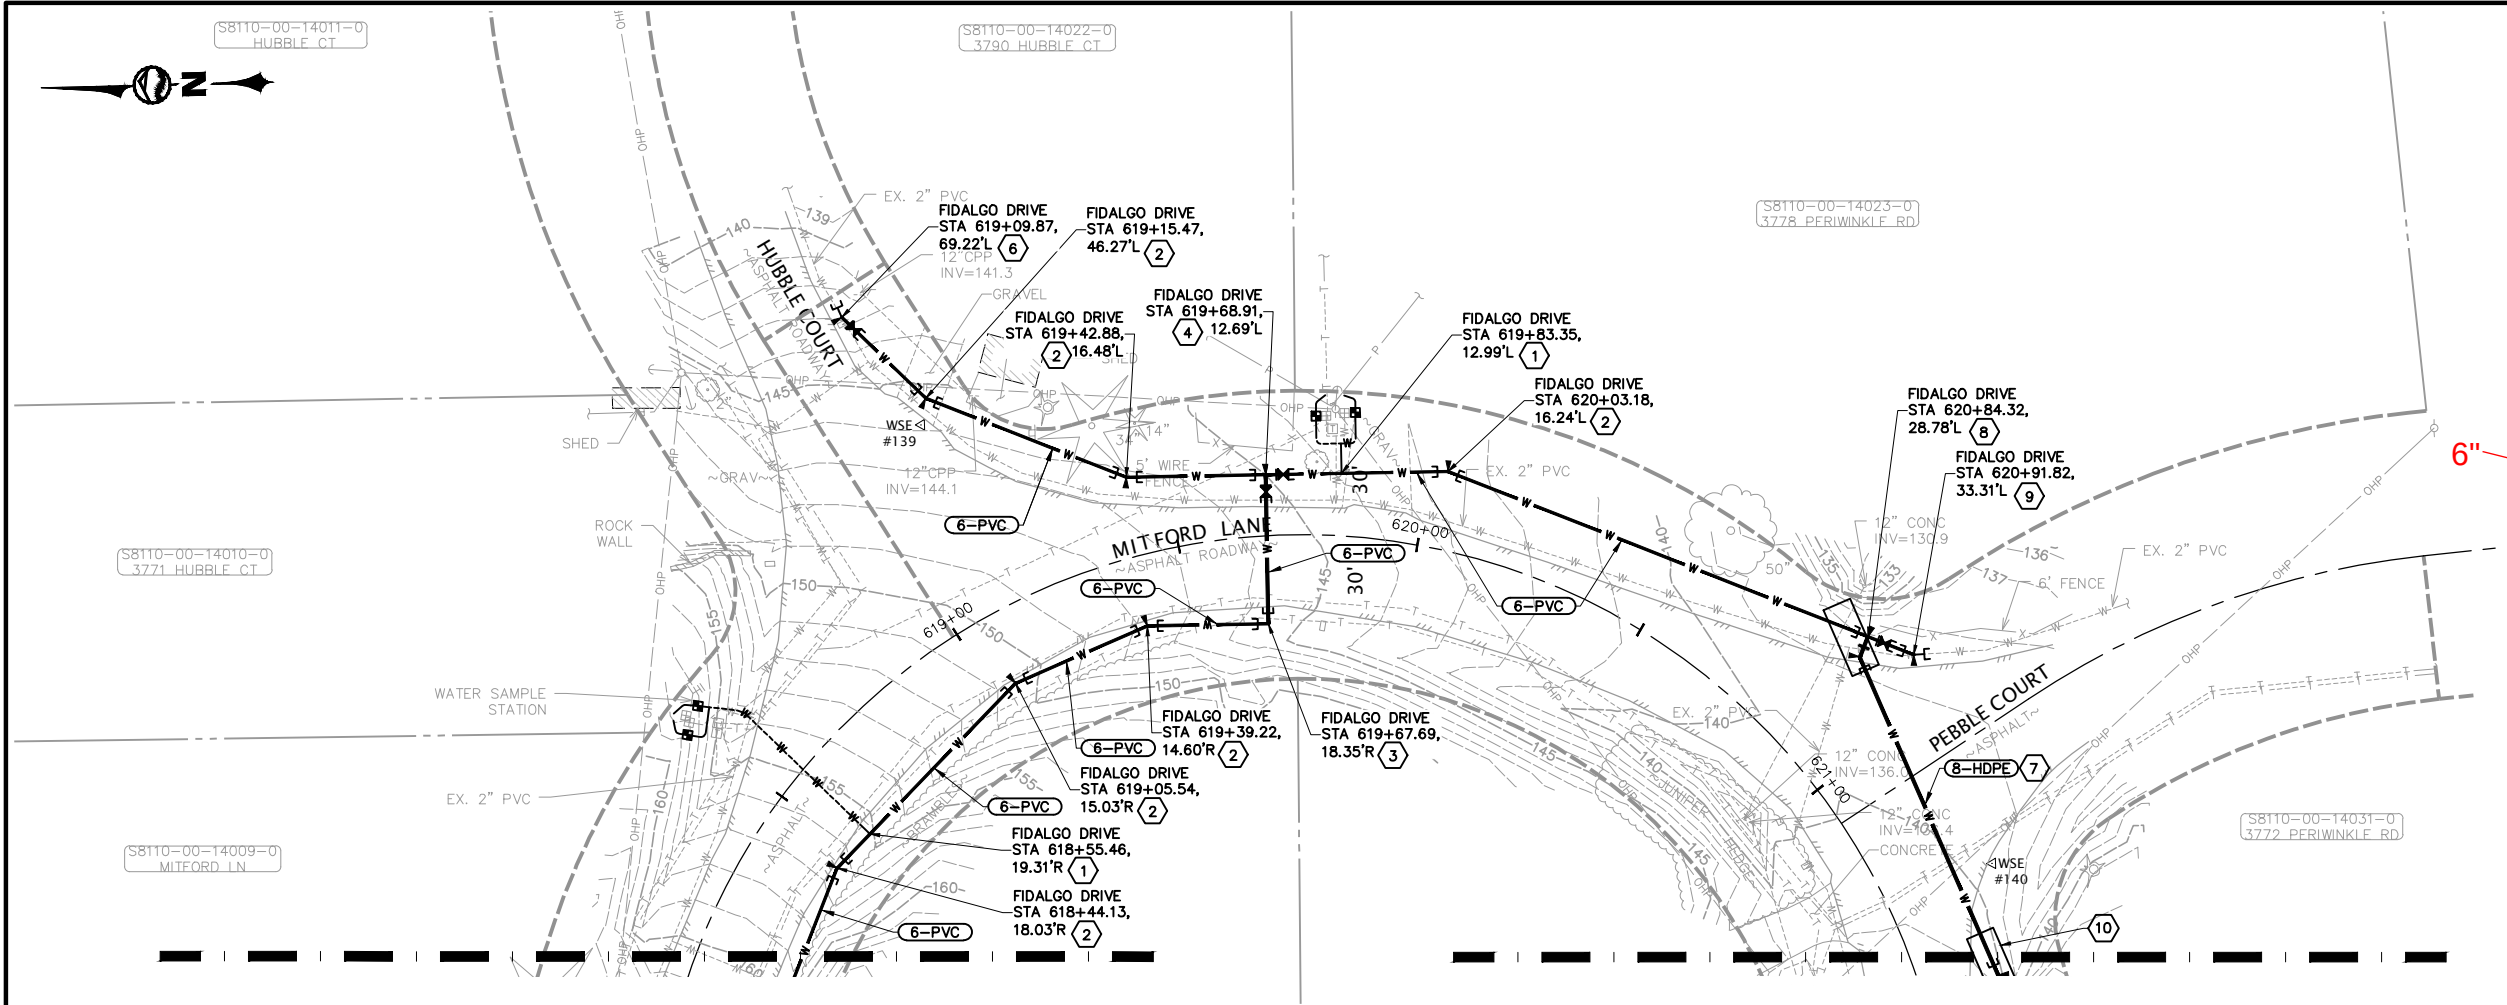

NO.	REVISIONS	BY	DATE
1	KEYED NOTES		
2	= SERVICE CONNECTION PER	X	X
3	= 6" 22-1/2" BEND MJxMJ, THRUST BLOCKING		
4	= 6" 90° BEND MJxMJ, THRUST BLOCKING		
5	= 6" TEE FLxFLxMJ, 6" GV FLxMJ, 6" GV FLxMJ, THRUST BLOCKING		
6	= 6" 45° BEND MJxMJ		
7	= CONNECT TO EX. 2" REDUCERS & FITTINGS AS REQUIRED. 6" 22-1/2" BEND MJxFL, 6" GV FLxMJ		
8	= 8" HDPE INSTALLED BY HORIZONTAL DIRECTIONAL DRILLING. HDPE ADAPTERS & FITTINGS AS REQUIRED		
9	= 6" x 8" TEE FLxFLxMJ, 8" 45° BEND FLxMJ, 6" GV FLxMJ, THRUST BLOCKING		
10	= 6" 22-1/2" BEND MJxMJ, CONNECT TO EX. 2", REDUCERS & FITTINGS AS REQUIRED		
11	= HDD ACCESS PIT		

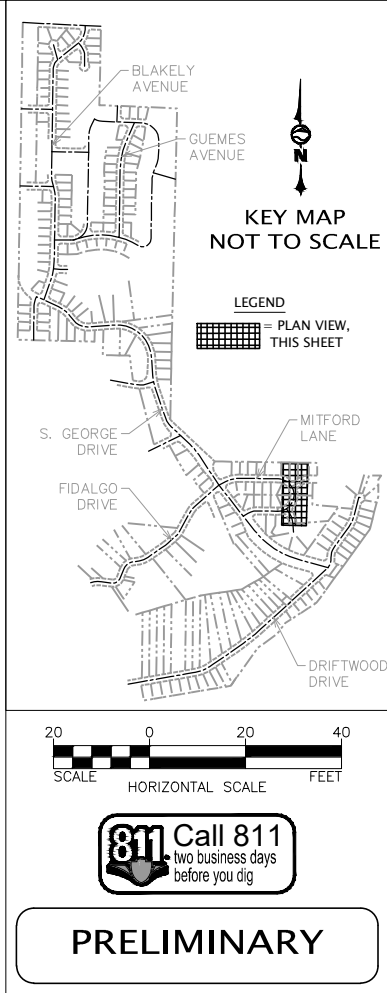

WILSON
ENGINEERING

WILSONENGINEERING.COM

PRELIMINARY

DESIGNED BY
XXX
DRAWN BY
JGS
CHECKED BY
CDS

SCATCHET HEAD WATER DISTRICT

WASHINGTON

WATER SYSTEM IMPROVEMENTS

MITFORD LANE - STA 618+12 TO STA 621+40

SHEET
C4.22



DATE
12-8-22

SCALE
AS SHOWN

JOB NUMBER
2022-013

PAGE
X

OF
X

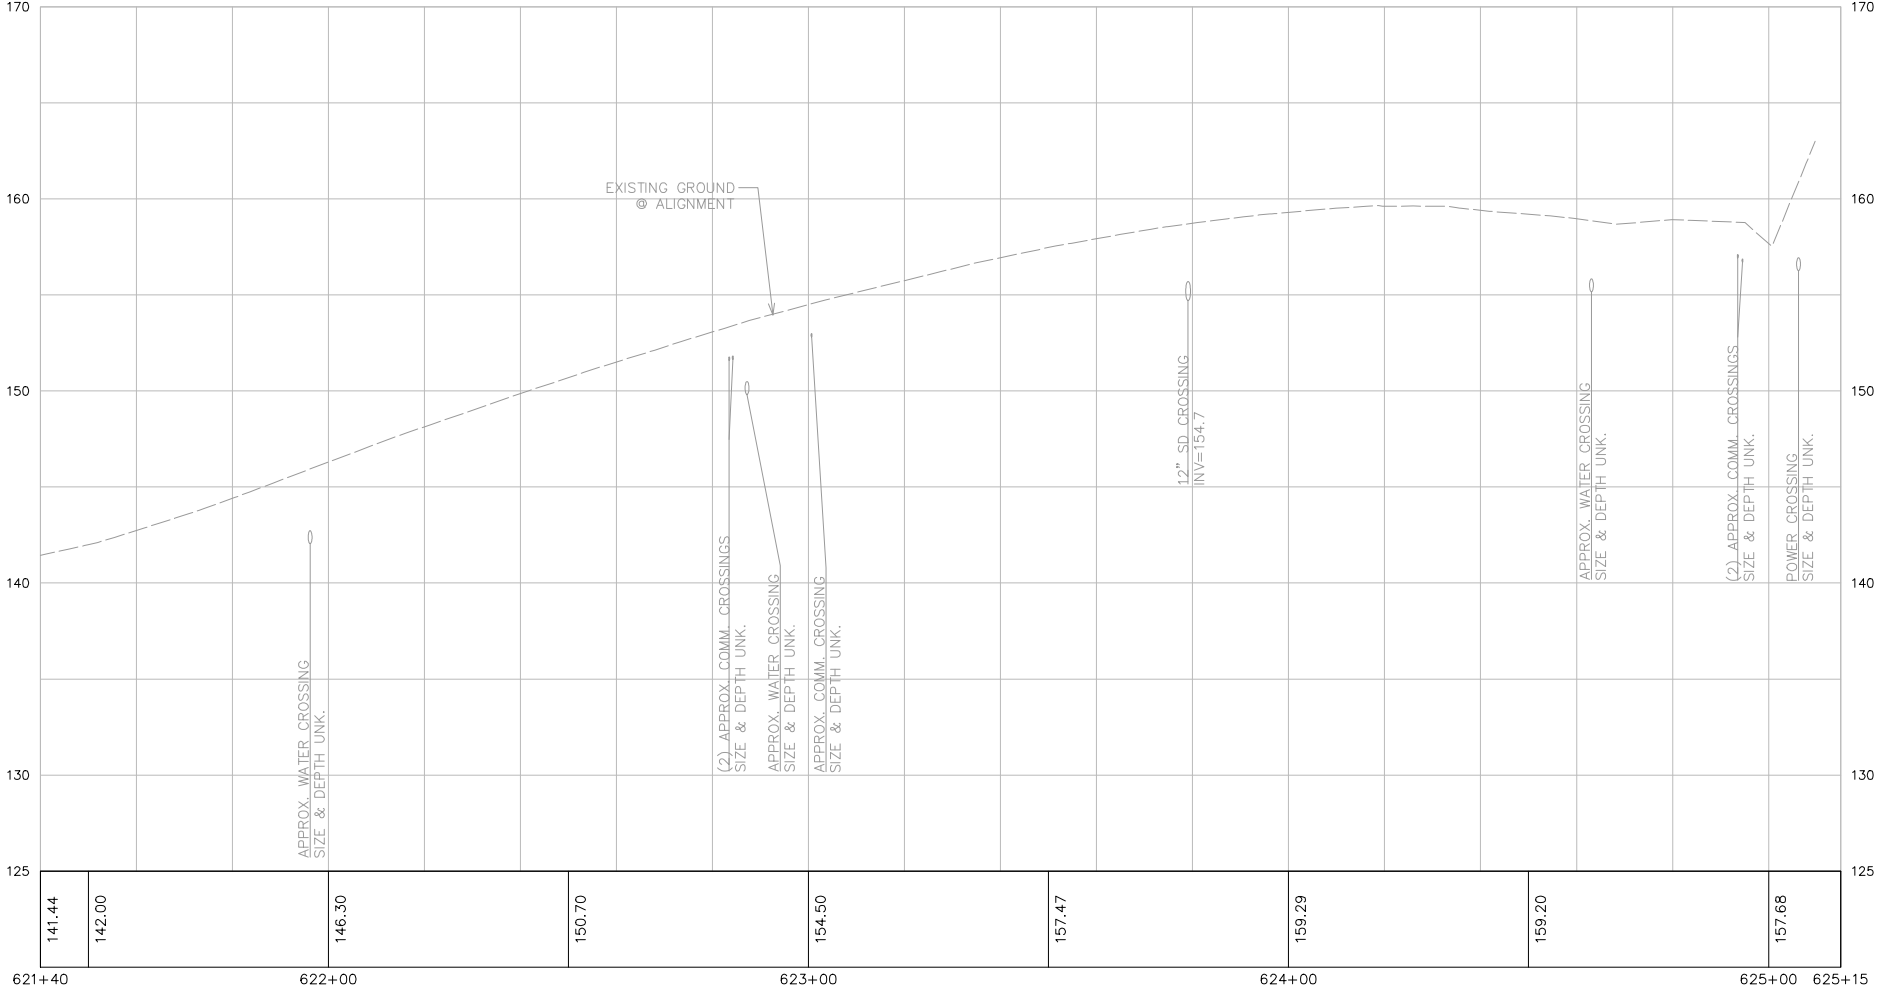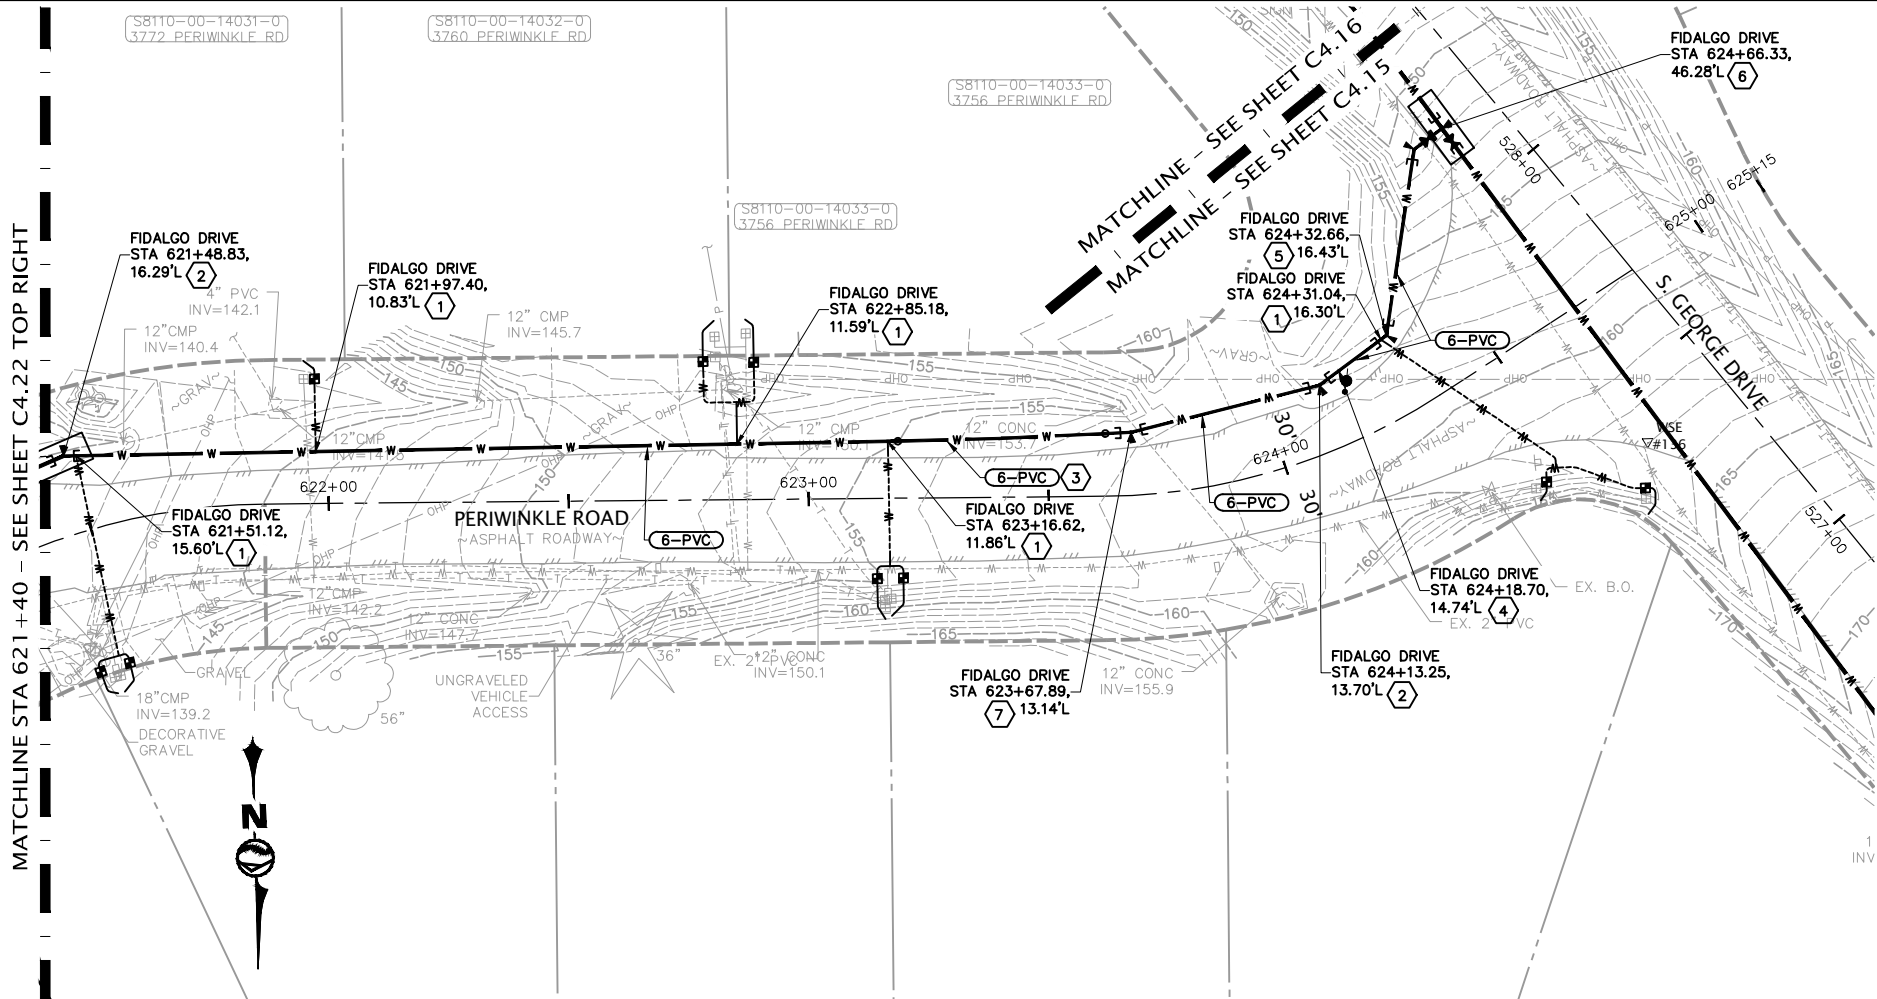

NO.	REVISIONS	BY	DATE

KEYED NOTES

- ① = SERVICE CONNECTION PER $\frac{X}{X}$
- ② = 6" 22-1/2" BEND MxMJ, THRUST BLOCKING
- ③ = MIN. 175' RADIUS
- ④ = COMBINATION AIR/VACUUM RELIEF VALVE. LOCATE AT HIGH POINT PER $\frac{X}{X}$
- ⑤ = 6" 45' BEND MxMJ, THRUST BLOCKING
- ⑥ = 8"x6" TEE FLxFLxMJ, 8" GV FLxFL, 6" GV FLxFL, 6" 45' BEND FLxMJ, THRUST BLOCKING
- ⑦ = 6" 11-1/4" BEND MxMJ, THRUST BLOCKING

KEY MAP NOT TO SCALE

LEGEND

- = PLAN VIEW, THIS SHEET

SCALE

20 0 20 40
SCALE HORIZONTAL SCALE FEET

811 Call 811
two business days before you dig

PRELIMINARY



SHEET		DATE	SCALE		JOB NUMBER	
C4.23		12-8-22	AS SHOWN		2022-013	
PAGE		WHIDBEY ISLAND		OF		
C4.23		SCATCHET HEAD WATER DISTRICT		X		
		WATER SYSTEM IMPROVEMENTS		X		
		PERIWINKLE ROAD - STA 621+40 TO 625+15				

WILSON ENGINEERING

WILSONENGINEERING.COM

PRELIMINARY

PLOT SETTINGS: AutoCAD PDF (General Documentation).pc3, ANSI full bleed B (17.00 x 11.00 inches), Portrait, 1:2, WE APWA_UNSCREENED.ctb
W:\2022\2022-013 SCATCHET HEAD WD WATER IMPROVEMENTS.MMM\DWG_V2019_NAD83_NAD88\2022_2022-013 C4.24-C4.28 DRIFTWOOD PLAN & PROFILES.DWG - 12/8/2022 2:07 PM - Jeff Smith

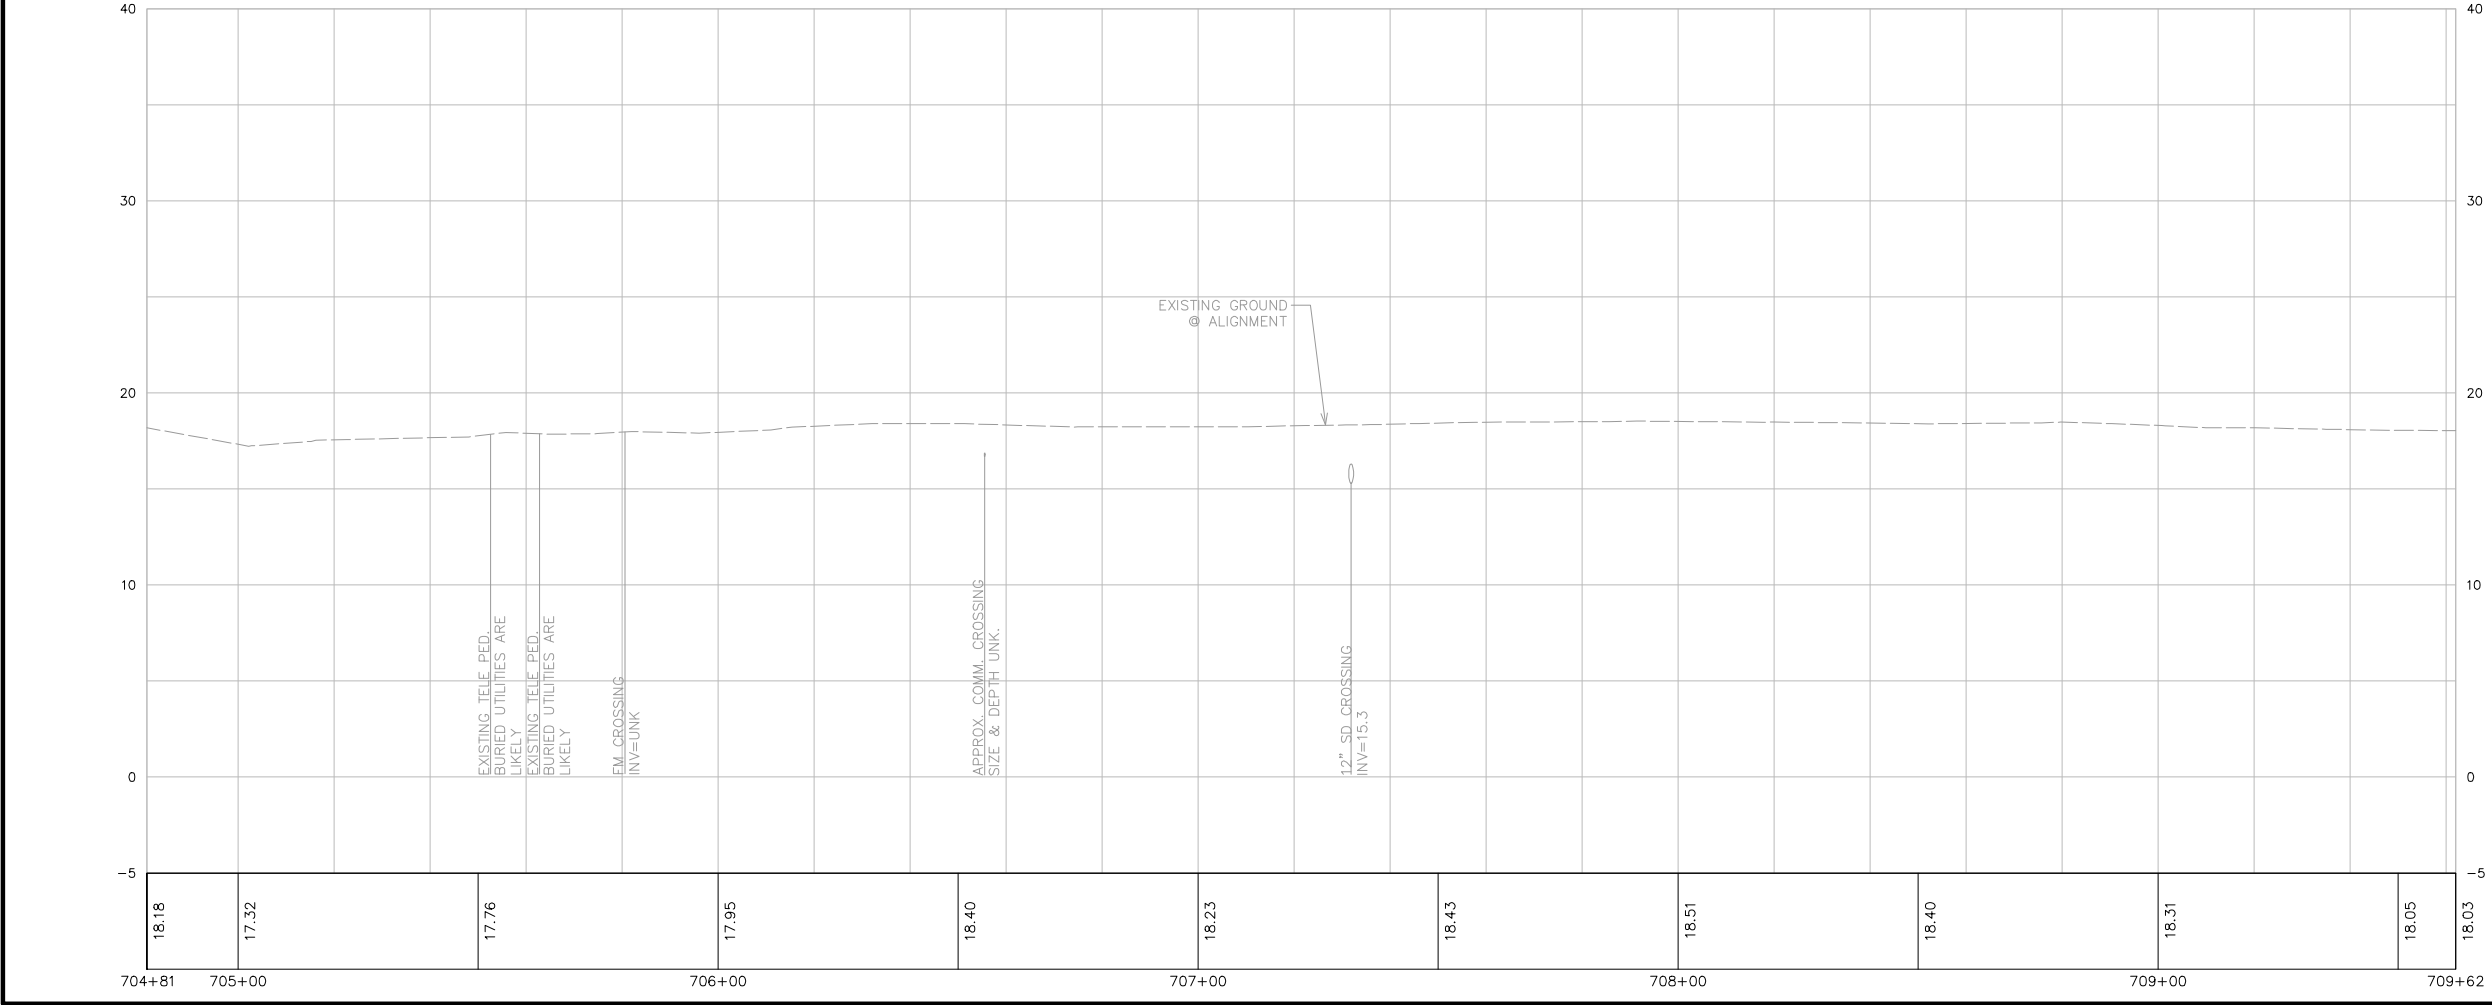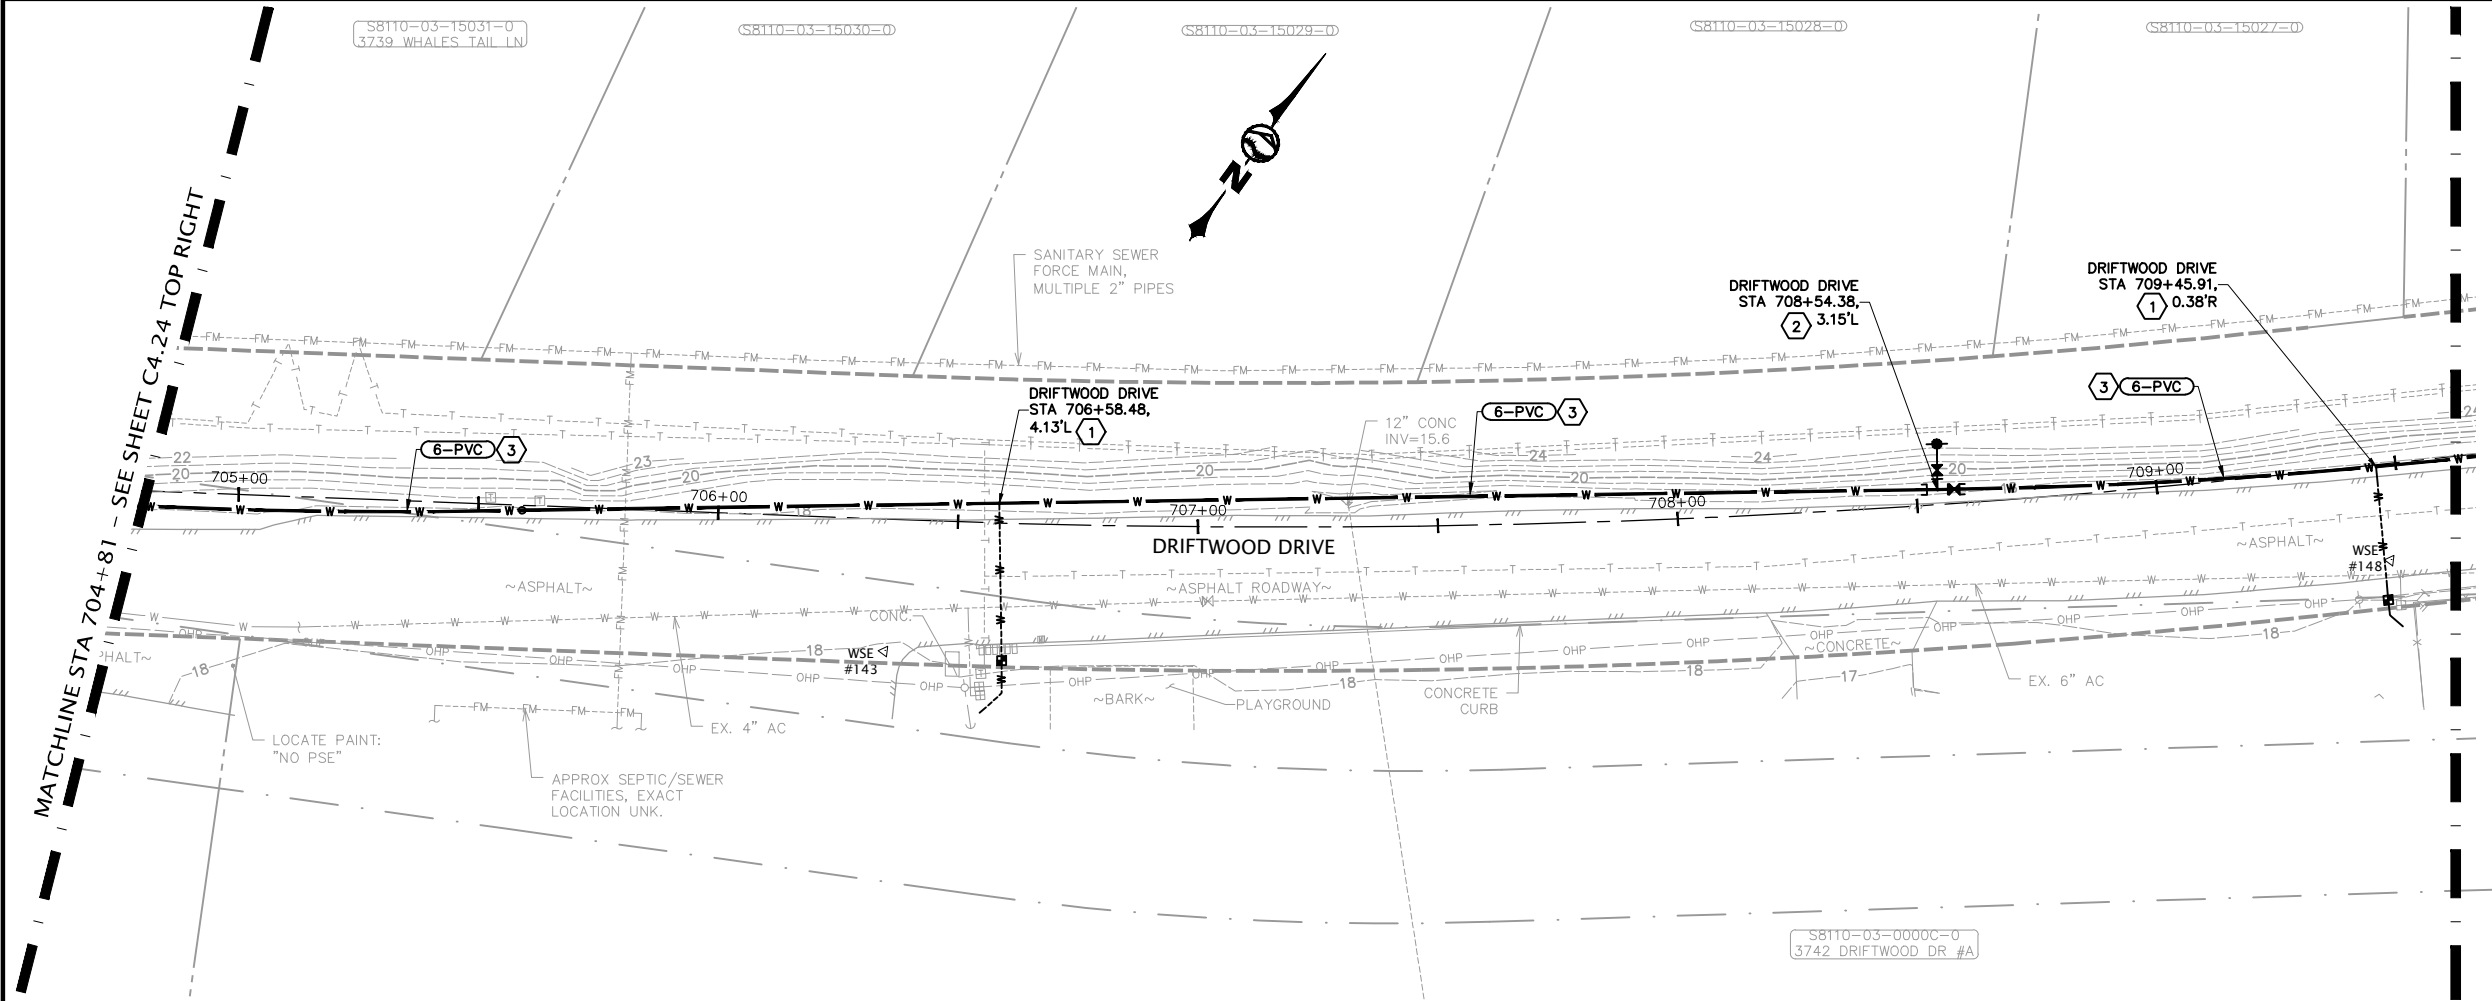

NO.	REVISIONS	BY	DATE

KEYED NOTES

- ① = SERVICE CONNECTION PER $\frac{X}{X}$
- ② = 6" GV FLxMJ, HYDRANT ASS'Y PER $\frac{X}{X}$
- ③ = 175' MIN RADIUS

KEY MAP
NOT TO SCALE

LEGEND
[Hatched Box] = PLAN VIEW, THIS SHEET



SCALE
20 0 20 40
SCALE HORIZONTAL SCALE FEET

811 Call 811
two business days before you dig

PRELIMINARY

WILSON ENGINEERING  WILSONENGINEERING.COM	DESIGNED BY XXX	DRAWN BY JGS	CHECKED BY CDS
	SCATCHET HEAD WATER DISTRICT		
	WASHINGTON		
C4.25	DATE 12-8-22	SCALE AS SHOWN	JOB NUMBER 2022-013
	WATER SYSTEM IMPROVEMENTS		
	DRIFTWOOD DRIVE - STA 704+81 TO STA 709+62		
PAGE	X	OF	X

PLOT SETTINGS: AutoCAD PDF (General Documentation).pc3, ANSI full bleed B (17.00 x 11.00 inches), Portrait, 1:2, WE APWA_UNSCREENED.ctb
W:\2022\2022-013 SCATCHET HEAD WD WATER IMPROVEMENTS.MMM\DWG_V2019_NAD83_NAD88\2022_013 C4.24-C4.28 DRIFTWOOD PLAN & PROFILES.DWG - 12/8/2022 2:08 PM - Jeff Smith

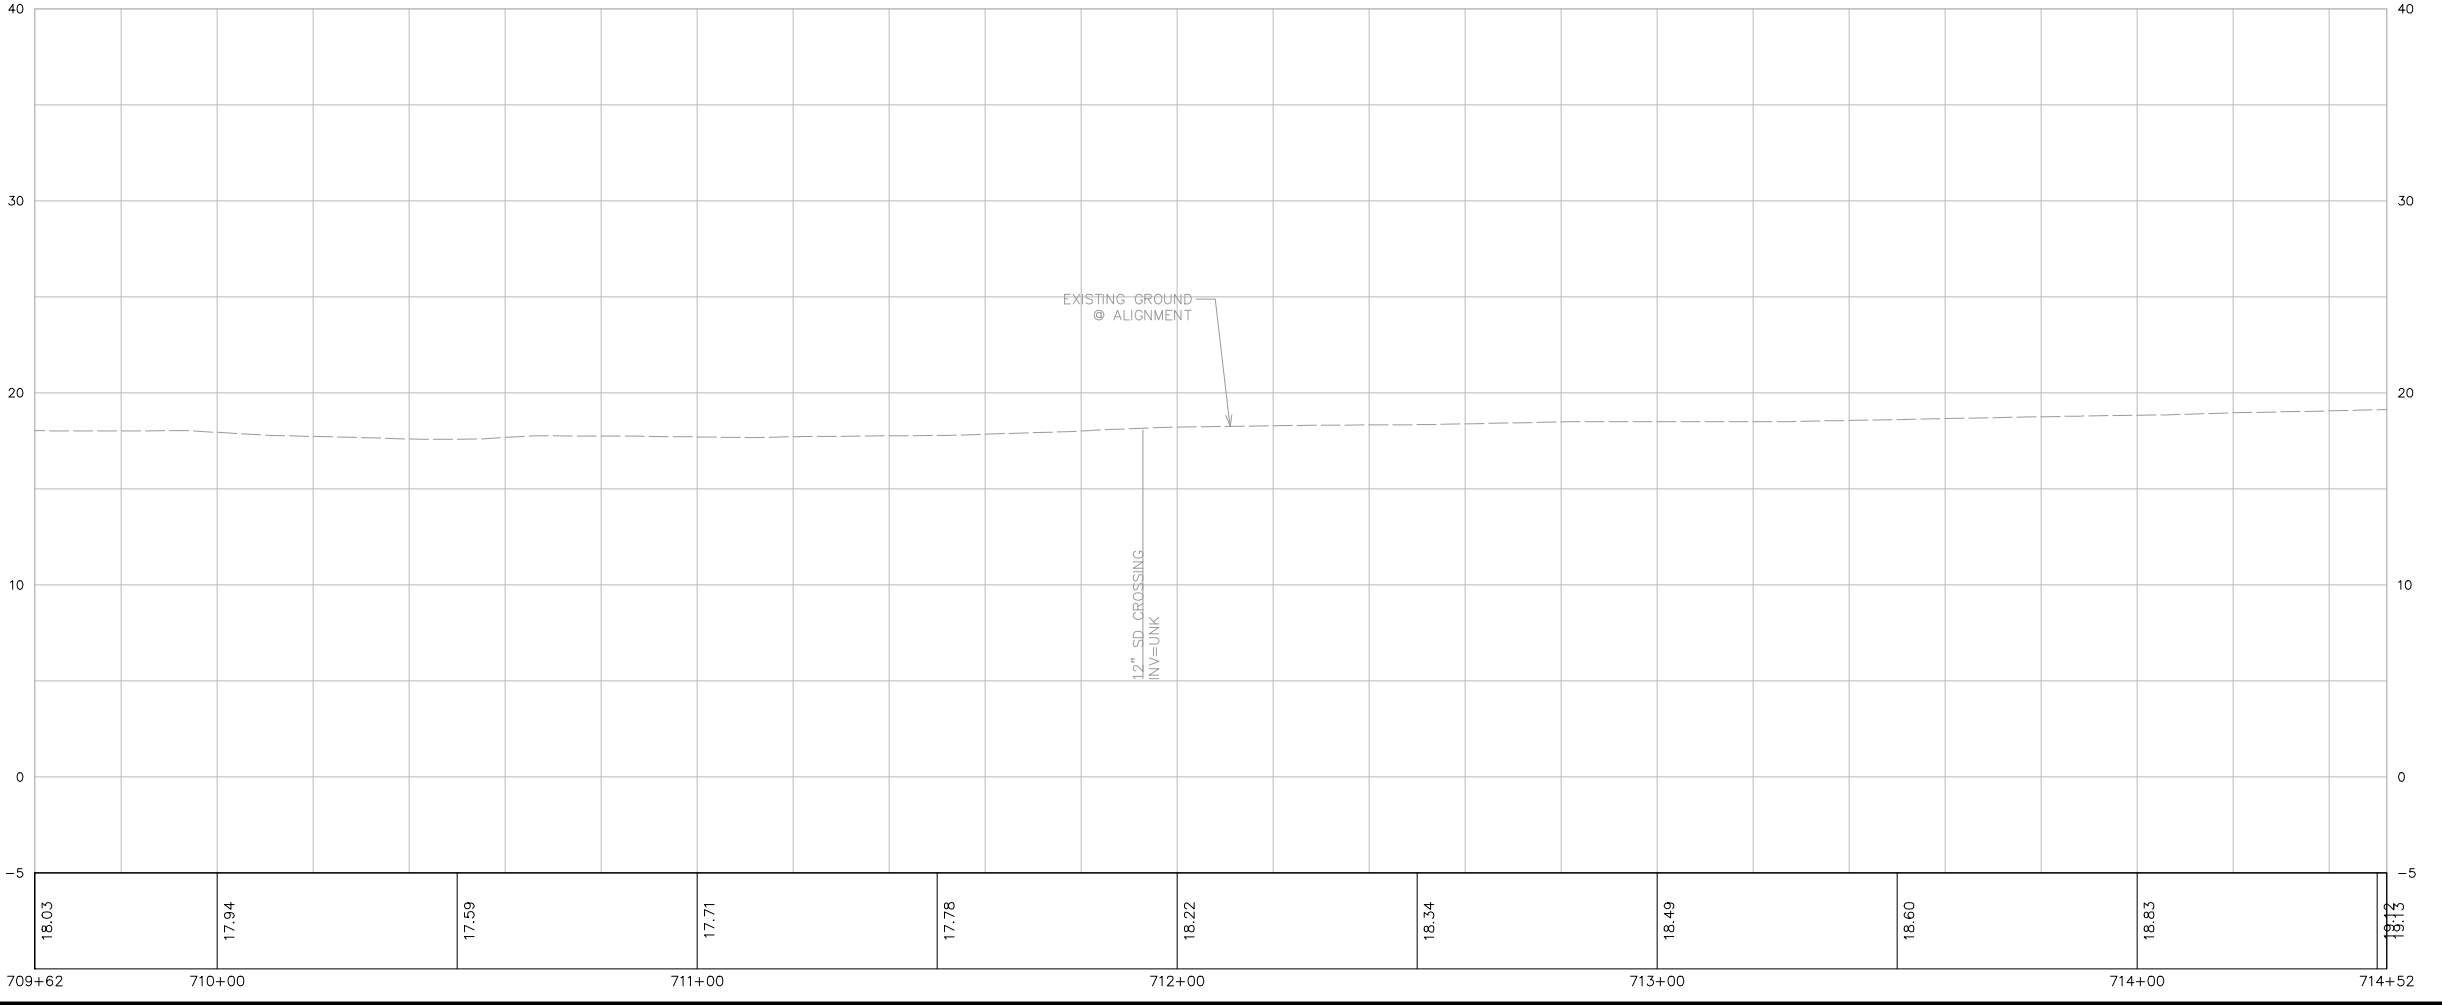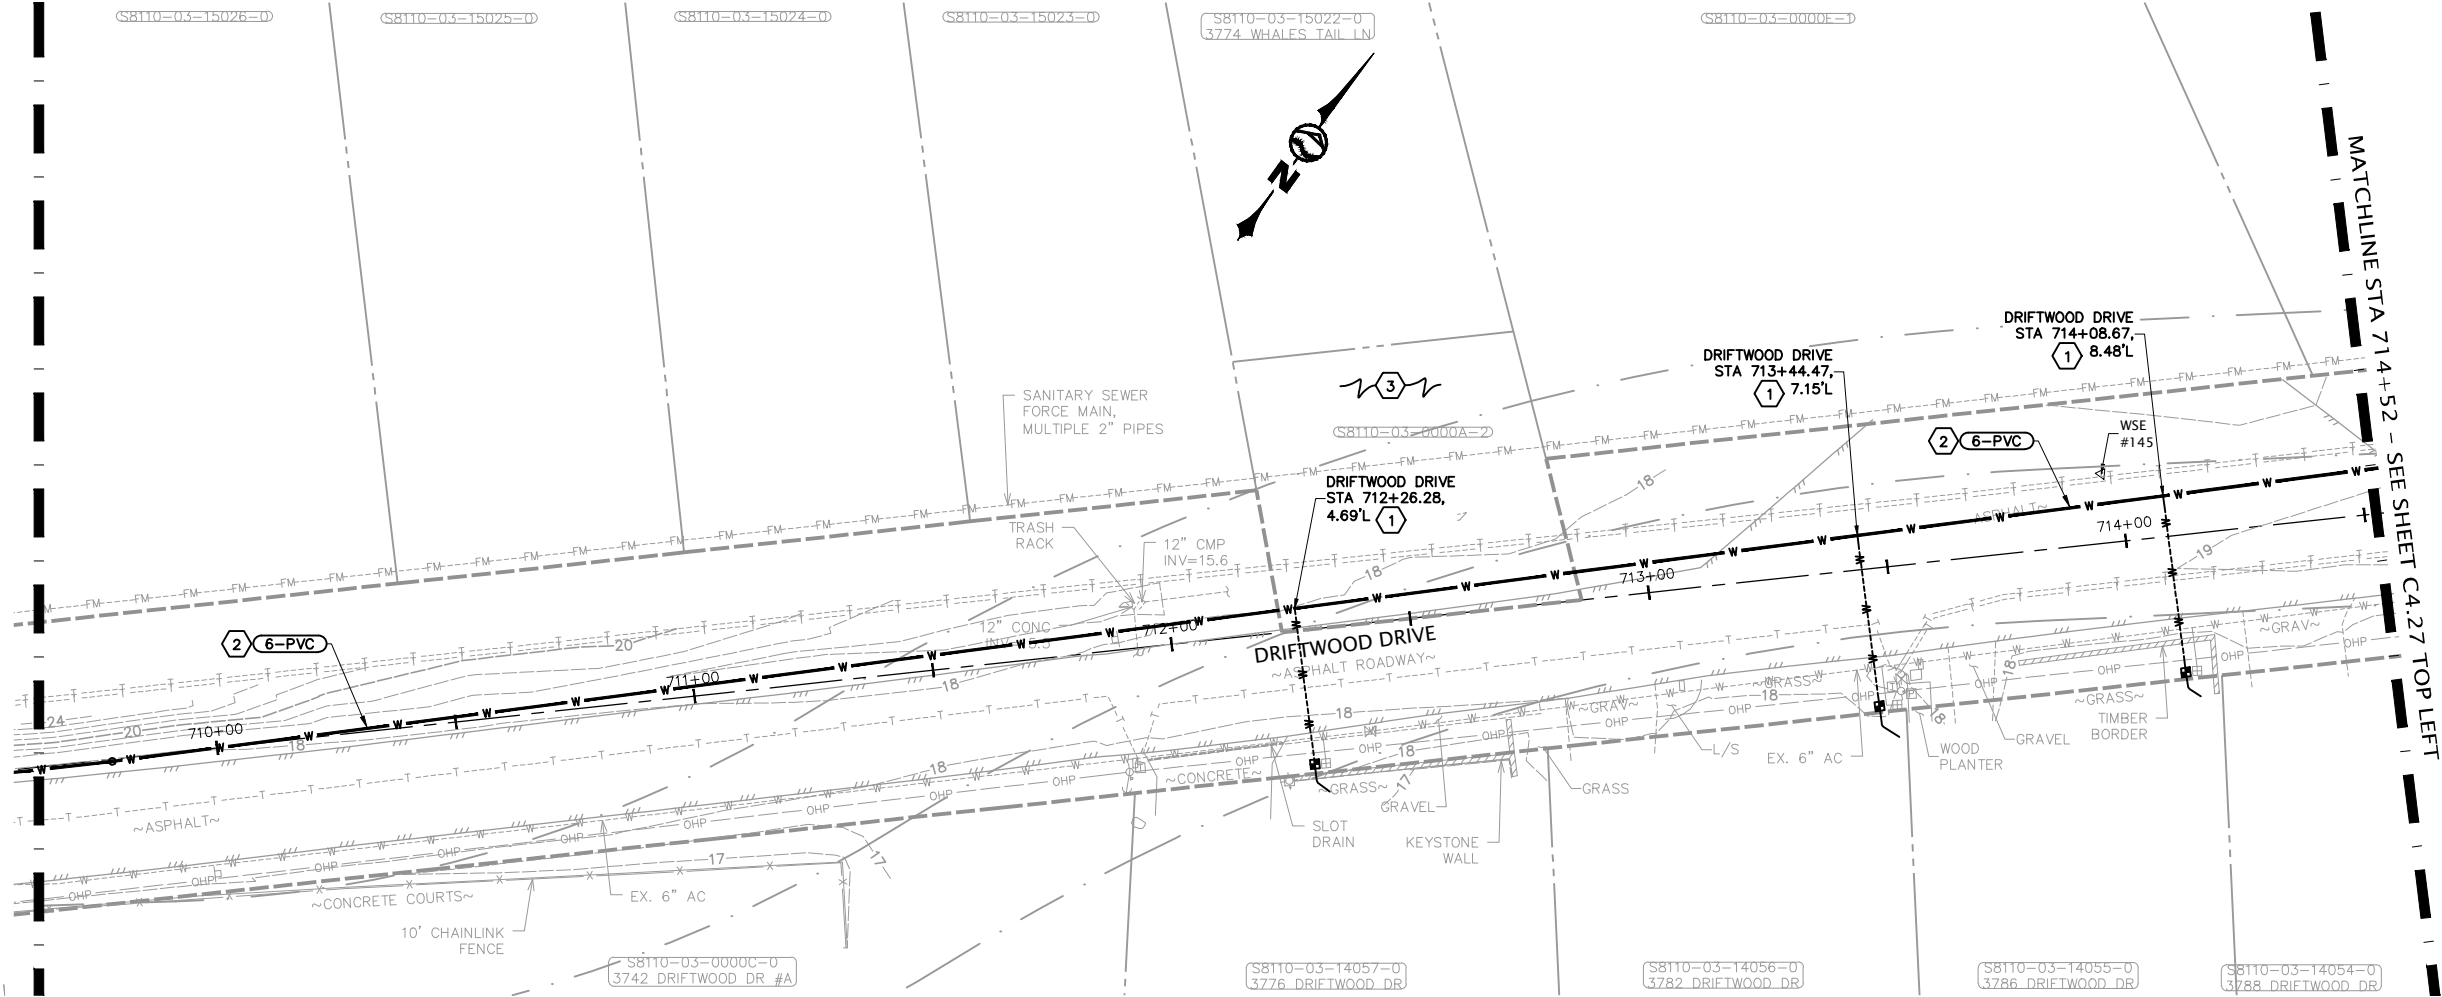

NO.

REVISIONS

BY

DATE

KEYED NOTES

1 = SERVICE CONNECTION PER

2 = 175' MIN. RADIUS

3 = SCATCHET HEAD WATER DISTRICT PROPERTY

KEY MAP
NOT TO SCALE

LEGEND
PLAN VIEW, THIS SHEET

20 0 20 40
SCALE HORIZONTAL SCALE FEET

811 Call 811
two business days
before you dig

PRELIMINARY

WILSON
ENGINEERING

WILSONENGINEERING.COM

DESIGNED BY
XXX

DRAWN BY
JGS

CHECKED BY
CDS

SCATCHET HEAD WATER DISTRICT

WASHINGTON

WHIDBEY ISLAND

WATER SYSTEM IMPROVEMENTS

DRIFTWOOD DRIVE - STA 709+62 TO STA 714+52

SHEET
C4.26

DATE
12-8-22



SCALE
AS SHOWN

JOB NUMBER
2022-013


PAGE
X

OF
X

PLOT SETTINGS: AutoCAD PDF (General Documentation).pc3, ANSI full bleed B (17.00 x 11.00 inches), Portrait, 1:2, WE APWA_UNSCREENED.ctb
W:\2022-2023-013 SCATCHET HEAD WD WATER IMPROVEMENTS.MMM\DWG_V2019_NAD83_NAD88\2022-013 C4.24-C4.28 DRIFTWOOD PLAN & PROFILES.DWG - 12/8/2022 2:08 PM - Jeff Smith

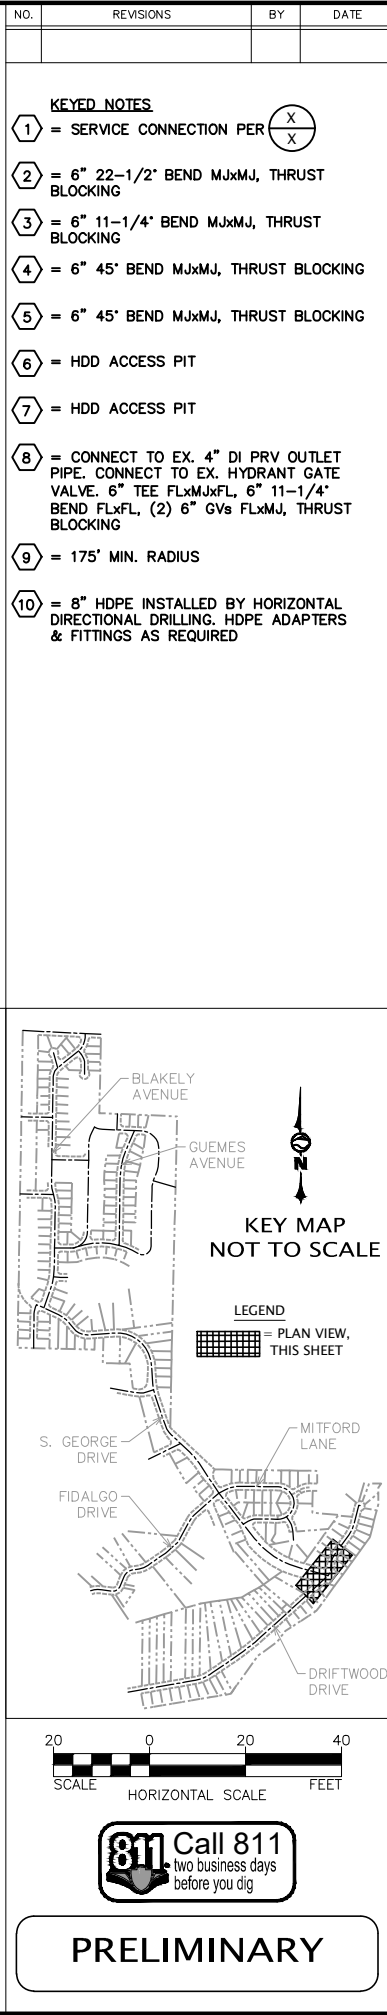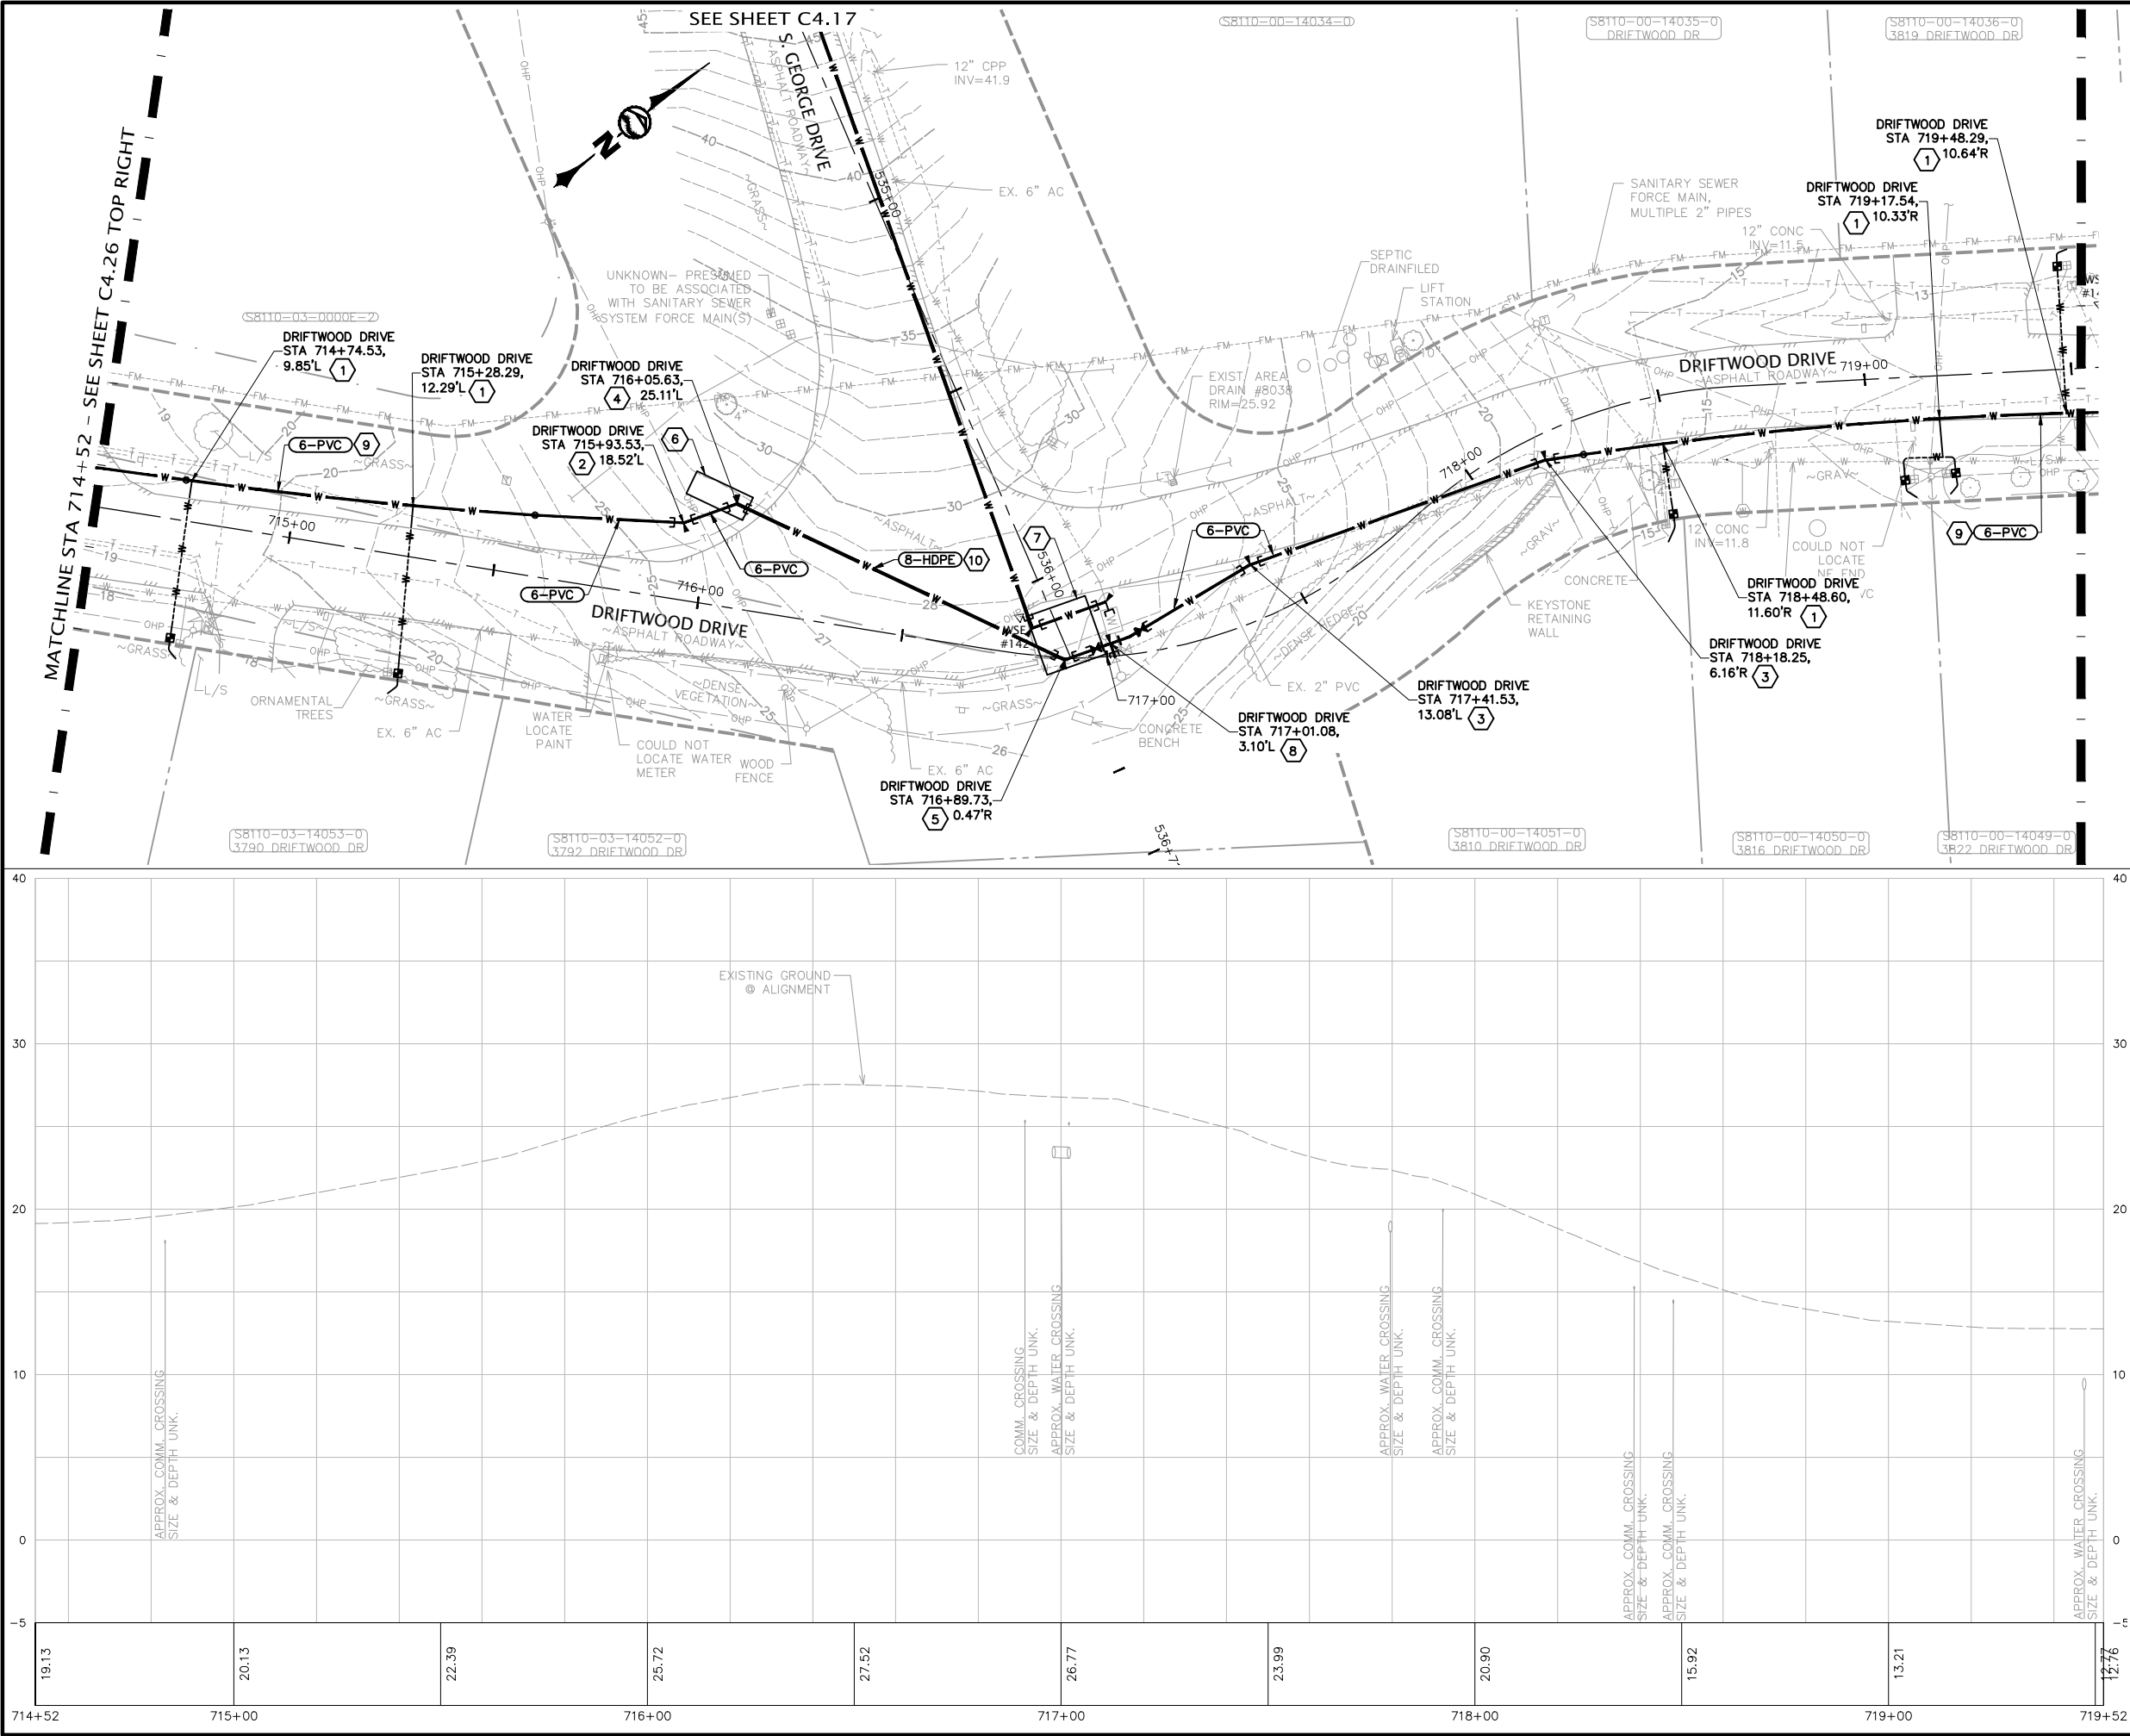

NO.		REVISIONS		BY	DATE
WILSON ENGINEERING WILSONENGINEERING.COM PRELIMINARY DESIGNED BY XXX DRAWN BY JGS CHECKED BY CDS					
SCATCHET HEAD WATER DISTRICT					
WASHINGTON					
WATER SYSTEM IMPROVEMENTS					
DRIFTWOOD DRIVE - STA 714+52 TO STA 719+52					
DATE 12-8-22		SCALE AS SHOWN		JOB NUMBER 2022-013	
SHEET C4.27		PAGE X OF X			

 

NO.	REVISIONS	BY	DATE

KEYED NOTES

① = SERVICE CONNECTION PER

② = 6" 11-1/4" BEND MJxMJ, THRUST BLOCKING

③ = 175' MIN RADIUS

④ = BLOW-OFF ASS'Y PER

**KEY MAP
NOT TO SCALE**

LEGEND

= PLAN VIEW,
THIS SHEET

SCALE HORIZONTAL SCALE FEET

Call 811

two business days
before you dig

PRELIMINARY

